


SCOPE OF WORK:

- I. KITCHEN AREA
- II. LPG STOCK ROOM
- III. MULTI-PURPOSE HALL
- IV. FIRE EXIT LADDER / ALARM
- V. ELECTRICAL WORKS
- VI. FIRE ALARM SYSTEM
- VII. SMOKE DETECTOR, EMERGENCY LIGHTS & EXIT SIGN
- VIII. MECHANICAL WORKS
- IX. SIGNAGES AND MAPS

TABLE OF CONTENT:

|               |                                                                                                                                                                                                                                                           |              |                                                                                                                                                                                                                                      |
|---------------|-----------------------------------------------------------------------------------------------------------------------------------------------------------------------------------------------------------------------------------------------------------|--------------|--------------------------------------------------------------------------------------------------------------------------------------------------------------------------------------------------------------------------------------|
| A 1<br>12 23  | LOCATION PLAN<br>SITE DEVT. PLAN                                                                                                                                                                                                                          | E 1<br>11 23 | KITCHEN LIGHTING LAYOUT<br>KITCHEN POWER LAYOUT<br>PANEL BOARD CABINET ELEVATION<br>PANEL BOARD CABINET DETAIL                                                                                                                       |
| A 2<br>12 23  | GROUND FLOOR PLAN<br>SECOND FLOOR PLAN<br>BLOW UP PLAN<br>FRONT ELEVATION<br>WALL FOOTING DETAIL                                                                                                                                                          | E 2<br>11 23 | LOAD SCHEDULE<br>RISER DIAGRAM                                                                                                                                                                                                       |
| A 3<br>12 23  | BLOW UP PLAN 1 (OLD BLDG.)<br>BLOW UP PLAN 2 (OLD BLDG.)<br>BLOW UP PLAN 3 9OLD BLDG.)<br>BLOW UP PLAN 1 REAR ELEVATION<br>BLOW UP PLAN 2 FRONT ELEVATION<br>BLOW UP PLAN 3 FRONT ELEVATION<br>FIRE EXIT LADDER - A DETAIL<br>FIRE EXIT LADDER - B DETAIL | E 3<br>1 23  | LOWER BASEMENT SMOKE DETECTOR/FIRE ALARM/<br>EMERGENCY LIGHT/SIGNAGES LAYOUT (NEW BLDG.)<br>FIRE ALARM LAYOUT (NEW BLDG.)                                                                                                            |
| A 4<br>12 23  | KITCHEN FLOOR PLAN (EXISTING)<br>KITCHEN FLOOR PLAN (PROPOSED)                                                                                                                                                                                            | E 4<br>1 23  | UPPER BASEMENT SMOKE DETECTOR/FIRE ALARM/<br>EMERGENCY LIGHT/SIGNAGES LAYOUT (NEW BLDG.)                                                                                                                                             |
| A 5<br>12 23  | SECTION THRU LINE - A<br>SECTION THRU LINE - B<br>SECTION THRU LINE - C<br>SECTION THRU LINE - D                                                                                                                                                          | E 5<br>1 23  | GROUND FLOOR SMOKE DETECTOR/FIRE ALARM/<br>EMERGENCY LIGHT/SIGNAGES LAYOUT (NEW BLDG.)<br>FIRE ALARM LAYOUT (NEW BLDG.)                                                                                                              |
| A 6<br>12 23  | KITCHEN OFFICE FLOOR PLAN (PROPOSED)<br>SECTION THRU LINE - A<br>SECTION THRU LINE - B<br>SECTION THRU LINE - C<br>SECTION THRU LINE - D<br>CABINET SECTION                                                                                               | E 6<br>1 23  | SECOND FLOOR SMOKE DETECTOR/FIRE ALARM/<br>EMERGENCY LIGHT/SIGNAGES LAYOUT (NEW BLDG.)                                                                                                                                               |
| A 7<br>12 23  | SCHEDULE OF DOORS & WINDOWS                                                                                                                                                                                                                               | E 7<br>1 23  | ROOF DECK EMERGENCY LIGHT LAYOUT                                                                                                                                                                                                     |
| A 8<br>12 23  | REFLECTED CEILING PLAN (KITCHEN)                                                                                                                                                                                                                          | E 8<br>1 23  | GROUND FLOOR SMOKE DETECTOR/FIRE ALARM/<br>EMERGENCY LIGHT/SIGNAGES LAYOUT (OLD BLDG.)<br>SECOND FLOOR SMOKE DETECTOR/FIRE ALARM/<br>EMERGENCY LIGHT/SIGNAGES LAYOUT (OLD BLDG.)                                                     |
| A 9<br>12 23  | ROOF DECK FLOOR PLAN<br>KITCHEN SINK COUNTER PLAN<br>FRONT ELEVATION<br>SECTION - X<br>DETAIL OF DOOR<br>SEWER LINE LAYOUT / SEWER LINE ISOMETRIC<br>WATER LINE LAYOUT / WATER LINE ISOMETRIC<br>LEGEND                                                   | P 1<br>2     | KITCHEN SEWER LINE LAYOUT<br>KITCHEN WATER LINE LAYOUT                                                                                                                                                                               |
| A 10<br>12 23 | SECOND FIRE EXIT FLOOR PLAN NEW BLDG.<br>DETAIL OF FIRE EXIT MAP                                                                                                                                                                                          | P 2<br>2 23  | KITCHEN SEWER LINE ISOMETRIC<br>KITCHEN WATER LINE ISOMETRIC<br>ROOF DECK KITCHENETTE SEWER LINE LAYOUT<br>ROOF DECK KITCHENETTE WATER LINE LAYOUT<br>KITCHENETTE SEWER LINE ISOMETRIC<br>KITCHENETTE WATER LINE ISOMETRIC<br>LEGEND |
| A 11<br>12 23 | LOWER BASEMENT FIRE EXIT FLOOR PLAN NEW BLDG.<br>UPPER BASEMENT FIRE EXIT FLOOR PLAN NEW BLDG.                                                                                                                                                            |              |                                                                                                                                                                                                                                      |
| A 12<br>12 23 | GROUND FIRE EXIT FLOOR PLAN OLD BLDG.<br>SECOND FIRE EXIT FLOOR PLAN OLD BLDG.                                                                                                                                                                            | M 1<br>1 23  | GROUND FLOOR KITCHEN DUCTING LAYOUT (PROPOSED)<br>SECOND FLOOR DUCTING LAYOUT NEW OLD BLDG. (PROPOSED)<br>ROOF DECK DUCTING LAYOUT                                                                                                   |

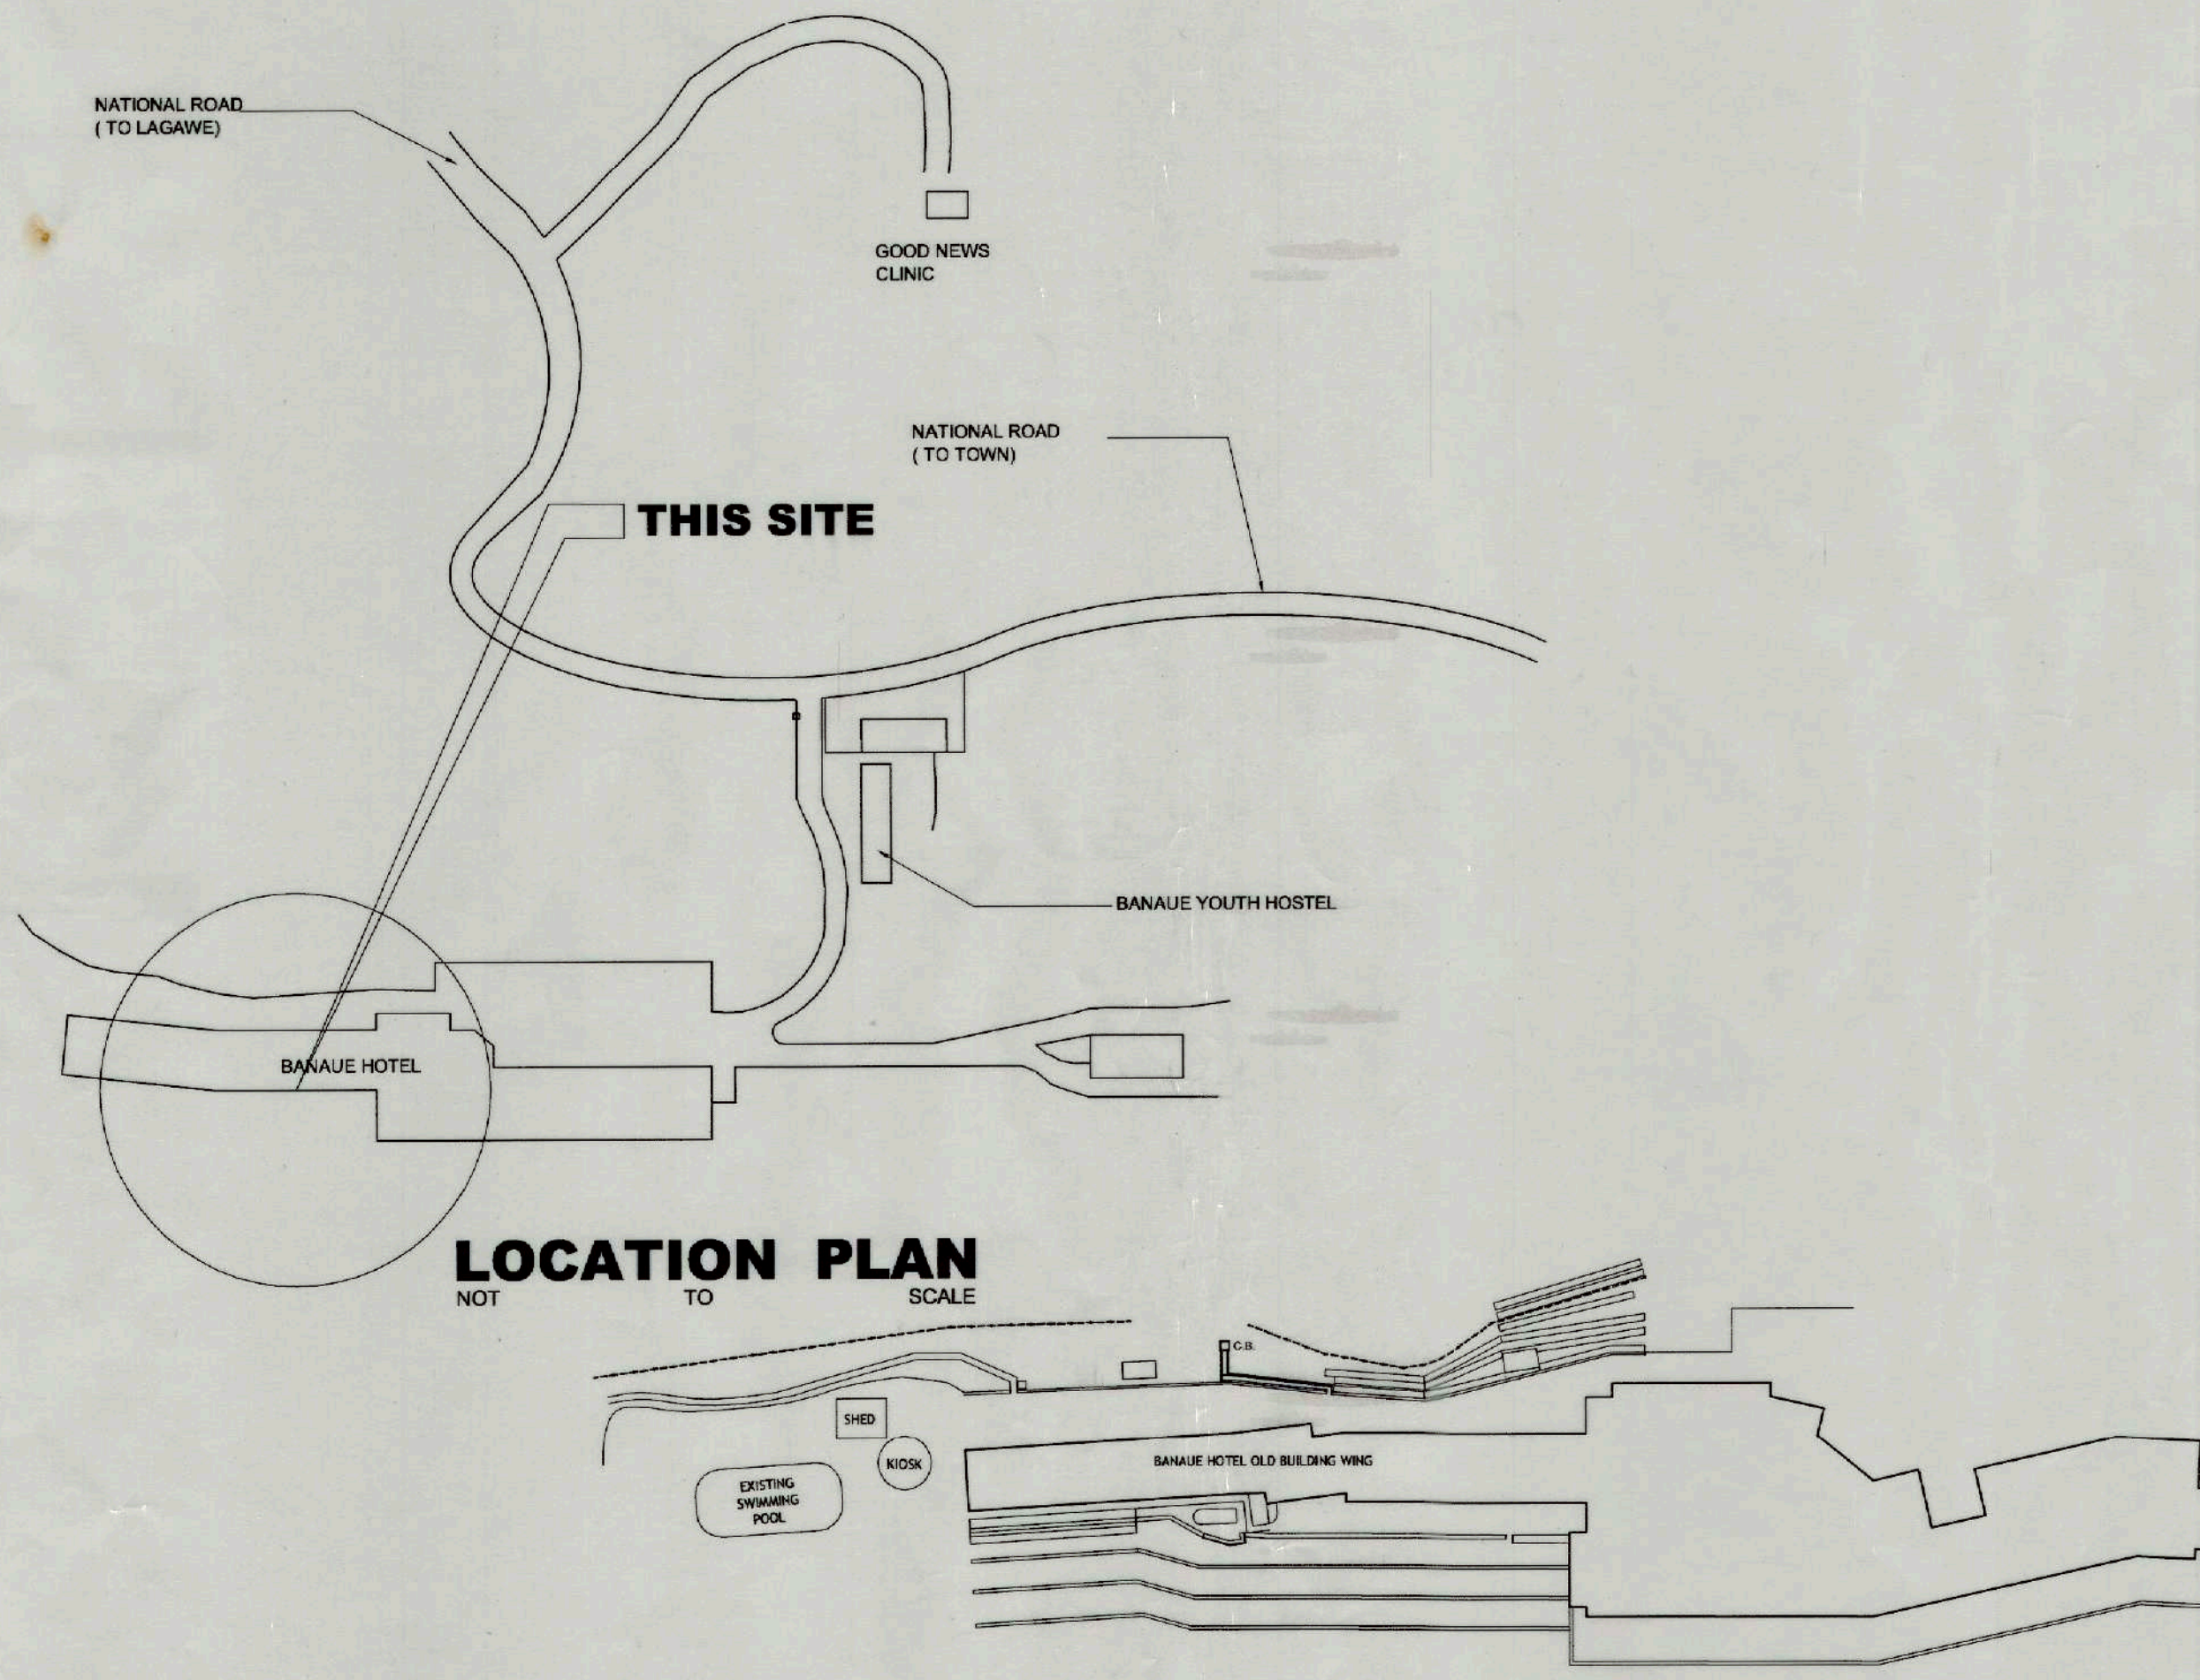

SITE DEVT. PLAN  
SCALE 1:1000 MTS.

CONFORME :  
  
MARLON PRIETO  
Resident Manager  
Banaue Hotel & Youth Hostel

REPUBLIC OF THE PHILIPPINES  
DPWH

OFFICE OF THE BUILDING OFFICIALS

DISTRICT/CITY/MUNICIPALITY

LAND USE AND ZONING

LINE AND GRADE

ARCHITECTURAL

STRUCTURAL

SANITARY


ELECTRICAL

MECHANICAL

|                                                                                                                                |                                                                    |                                            |                                                         |                                                               |                                                                                  |                           |                 |                                                                                                                                       |           |
|--------------------------------------------------------------------------------------------------------------------------------|--------------------------------------------------------------------|--------------------------------------------|---------------------------------------------------------|---------------------------------------------------------------|----------------------------------------------------------------------------------|---------------------------|-----------------|---------------------------------------------------------------------------------------------------------------------------------------|-----------|
| <br><b>TIEZA</b><br>TOURISM INFRASTRUCTURE<br>AND ENTERPRISE ZONE AUTHORITY<br>142 AMORSOLO ST. LEGASPI VILLAGE<br>MAKATI CITY | PROJECT TITLE/LOCATION                                             | PROJECT EVALUATION AND PLANNING DEPARTMENT |                                                         |                                                               | RECOMMENDING APPROVAL:                                                           | APPROVED BY:              | SHEET CONTENTS: | R.A. 545                                                                                                                              | SHEET NO. |
|                                                                                                                                | EMERGENCY WORKS FOR COMPLIANCE<br>WITH FIRE DEPARTMENT REQUIREMENT | PREPARED BY:<br>ODONILLO B. SAN JUAN       | CHECKED BY:<br>RADY E. ADAME                            | REVIEWED BY:<br>AMELITA S. CAGANDA                            | <br>NESTOR M. DOMALANTA                                                          | <br>POCHOLO J. D. PARAGAS | AS SHOWN        | THIS DRAWING IS<br>THE PROPERTY OF<br>TOURISM ENTERPRISE<br>ZONE AUTHORITY AND<br>CANNOT BE REPRO-<br>DUCED WITHOUT<br>THEIR CONSENT. |           |
|                                                                                                                                | BANAUE, IFUGAO                                                     | DRAWN BY: O.B. SAN JUAN                    | OFFICER IN CHARGE<br>PROJECT PLANNING & DESIGN DIVISION | OFFICER IN CHARGE<br>PROJECT EVALUATION & PLANNING DEPARTMENT | ASSISTANT CHIEF OPERATING OFFICER<br>Architectural & Engineering Services Sector | CHIEF OPERATING OFFICER   | REVISIONS:      |                                                                                                                                       |           |
|                                                                                                                                |                                                                    | DATE:                                      |                                                         |                                                               |                                                                                  |                           |                 |                                                                                                                                       |           |


CAR-17-04



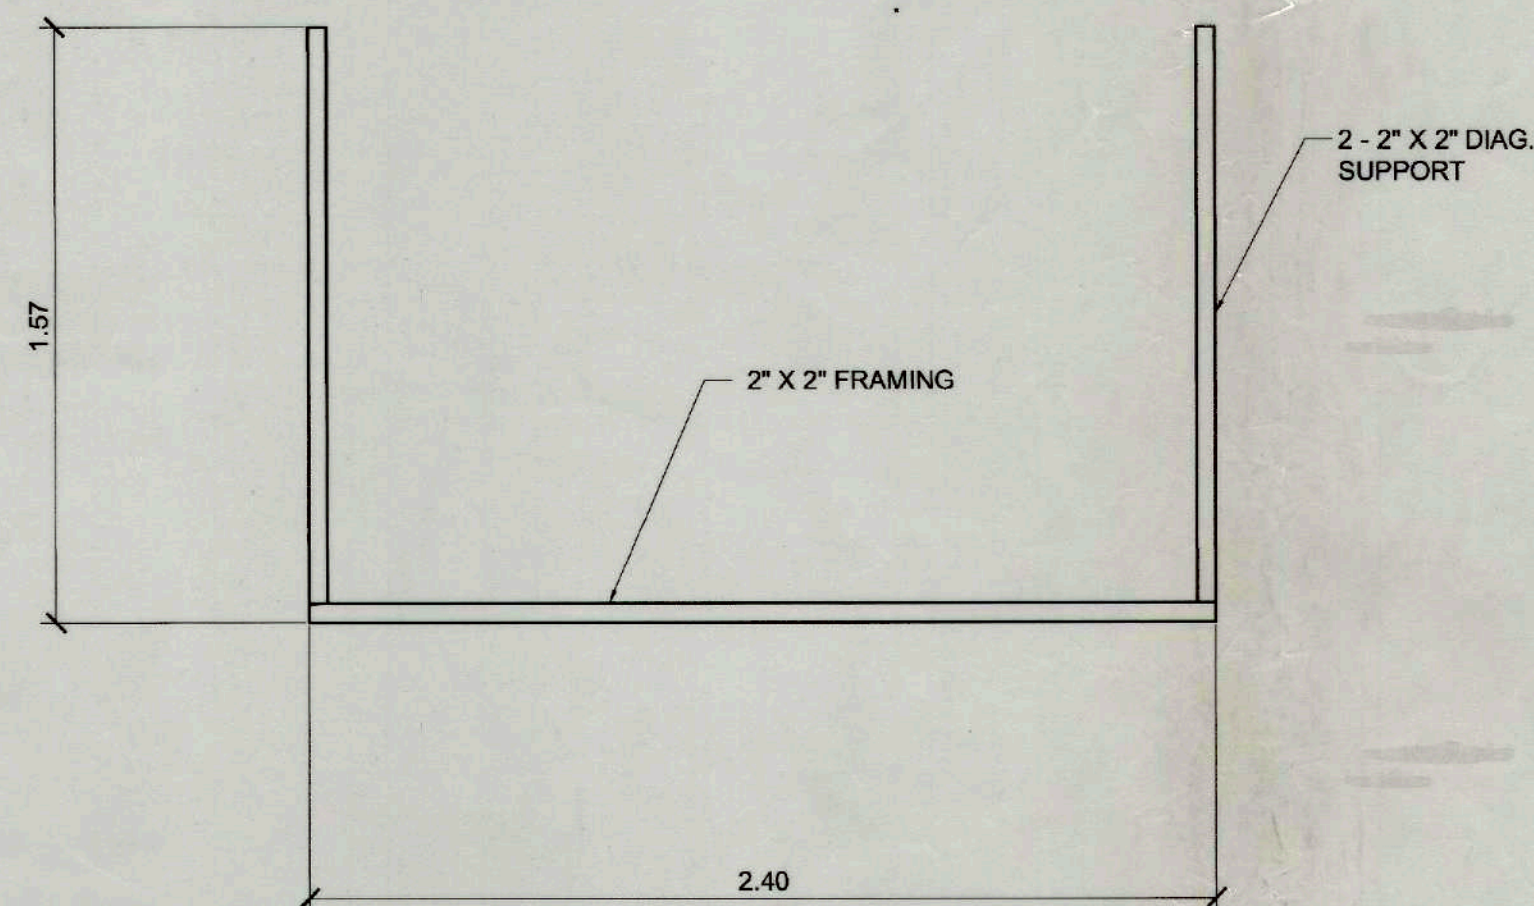


**TOP VIEW**

SCALE 1 : 20 MTS

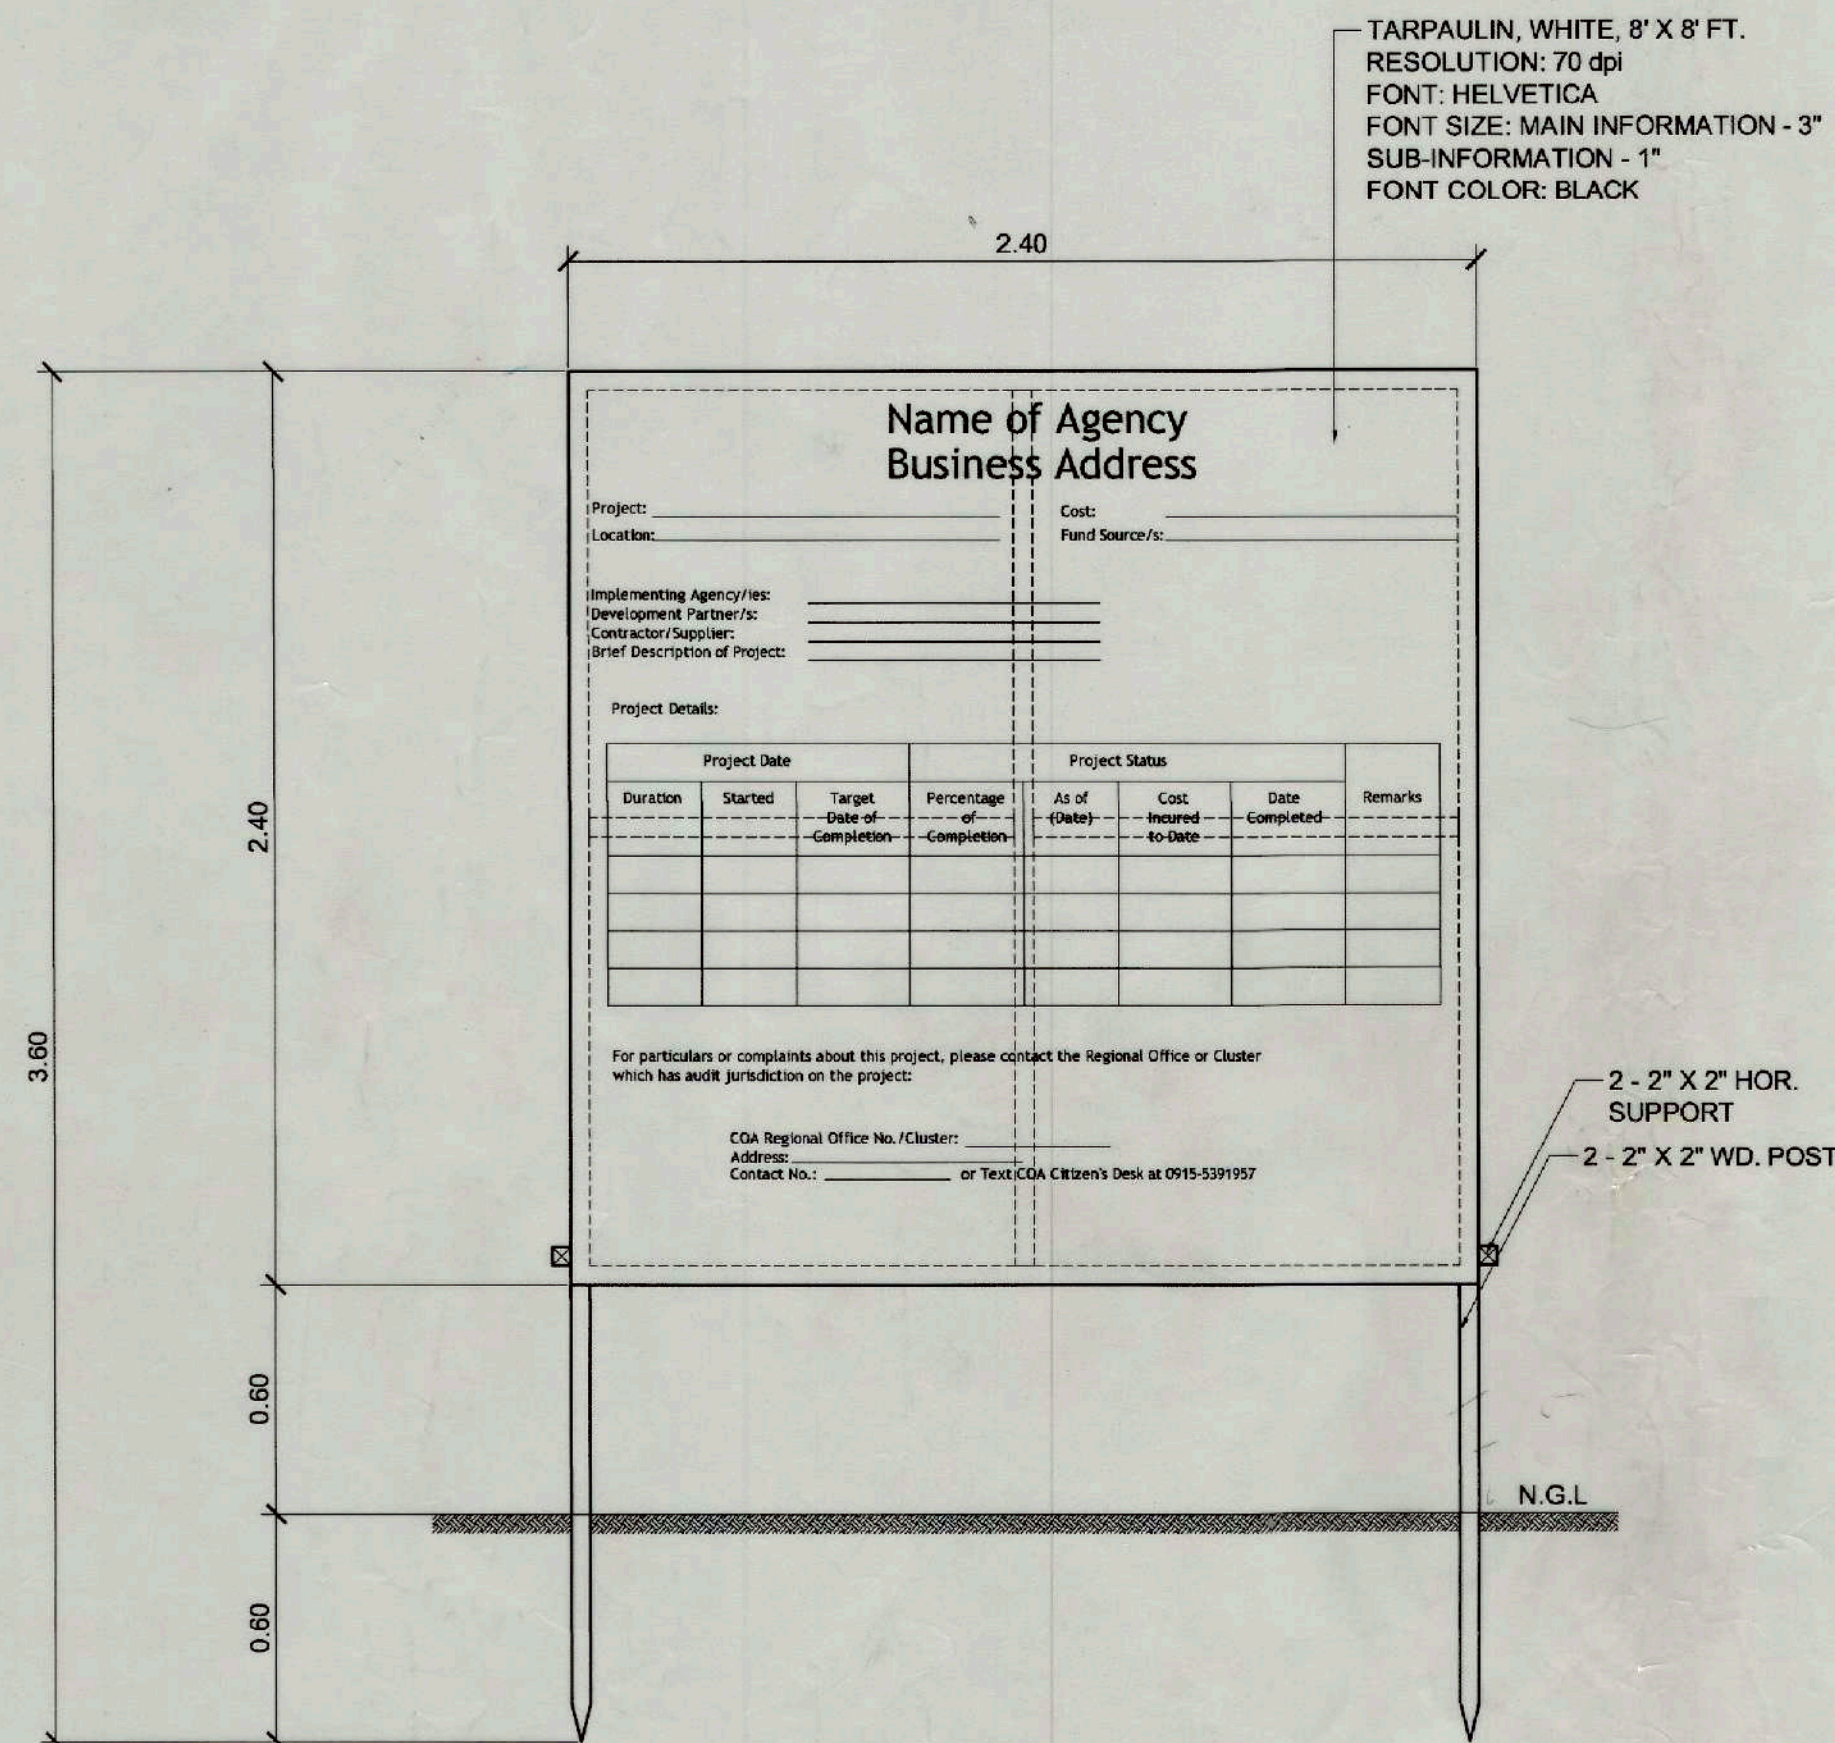

**FRONT ELEVATION**

SCALE 1 : 20 MTS

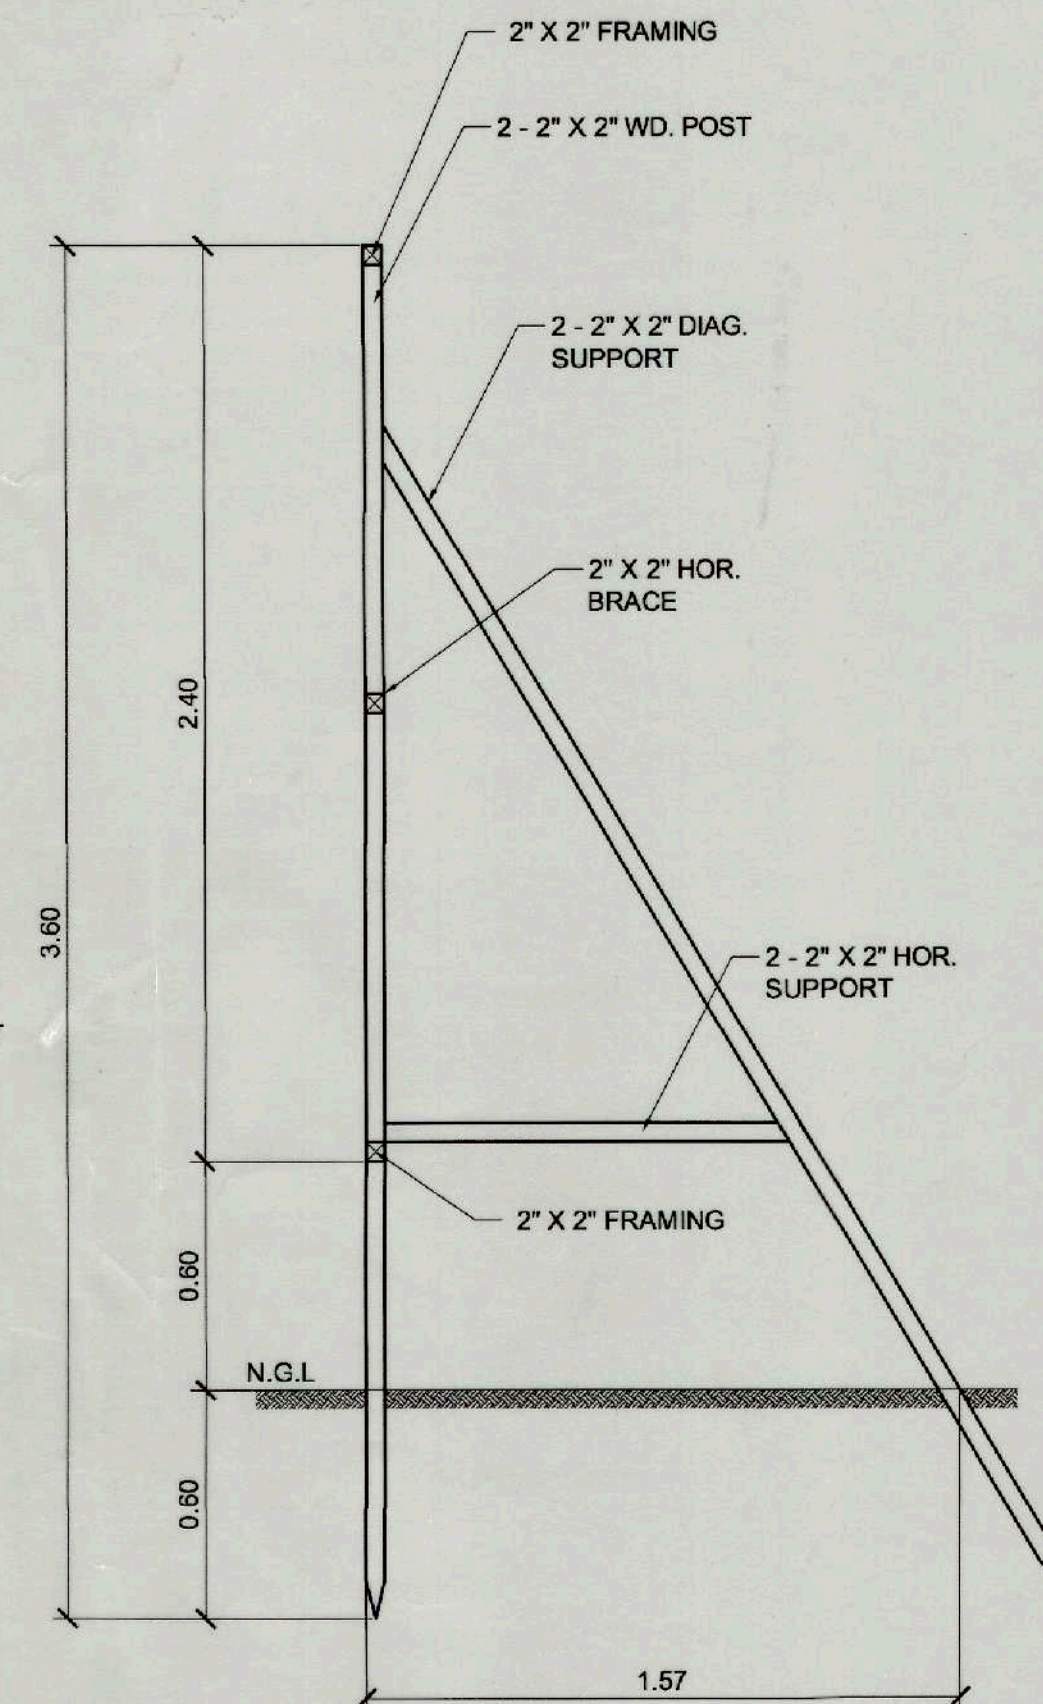

**SECTION**

SCALE 1 : 20 MTS



**TIEZA**  
TOURISM INFRASTRUCTURE  
AND ENTERPRISE ZONE AUTHORITY  
142 AMORSOLO ST. LEGASPI VILLAGE  
MAKATI CITY

PROJECT TITLE/LOCATION  
**EMERGENCY WORKS FOR COMPLIANCE  
WITH FIRE DEPARTMENT REQUIREMENT**  
BANAUE, IFUGAO

**PROJECT EVALUATION AND PLANNING DEPARTMENT**

PREPARED BY: *[Signature]*  
ODONILO B. SAN JUAN  
CHECKED BY: *[Signature]*  
RADY E. ADAME  
REVIEWED BY: *[Signature]*  
AMELITA S. CAGANDA

RECOMMENDING APPROVAL:  
*[Signature]*  
NESTOR M. DOMALANTA  
ASSISTANT CHIEF OPERATING OFFICER  
Architectural & Engineering Services Sector

APPROVED BY:  
*[Signature]*  
POCHOLO J. D. PARAGAS  
CHIEF OPERATING OFFICER


SHEET CONTENTS:  
AS SHOWN  
REVISIONS:

R.A. 545  
THIS DRAWING IS  
THE PROPERTY OF  
TOURISM ENTERPRISE  
ZONE AUTHORITY AND  
CANNOT BE REPRO-  
DUCED WITHOUT  
THEIR CONSENT.

SHEET NO.  
A  
1


CAR-17-04



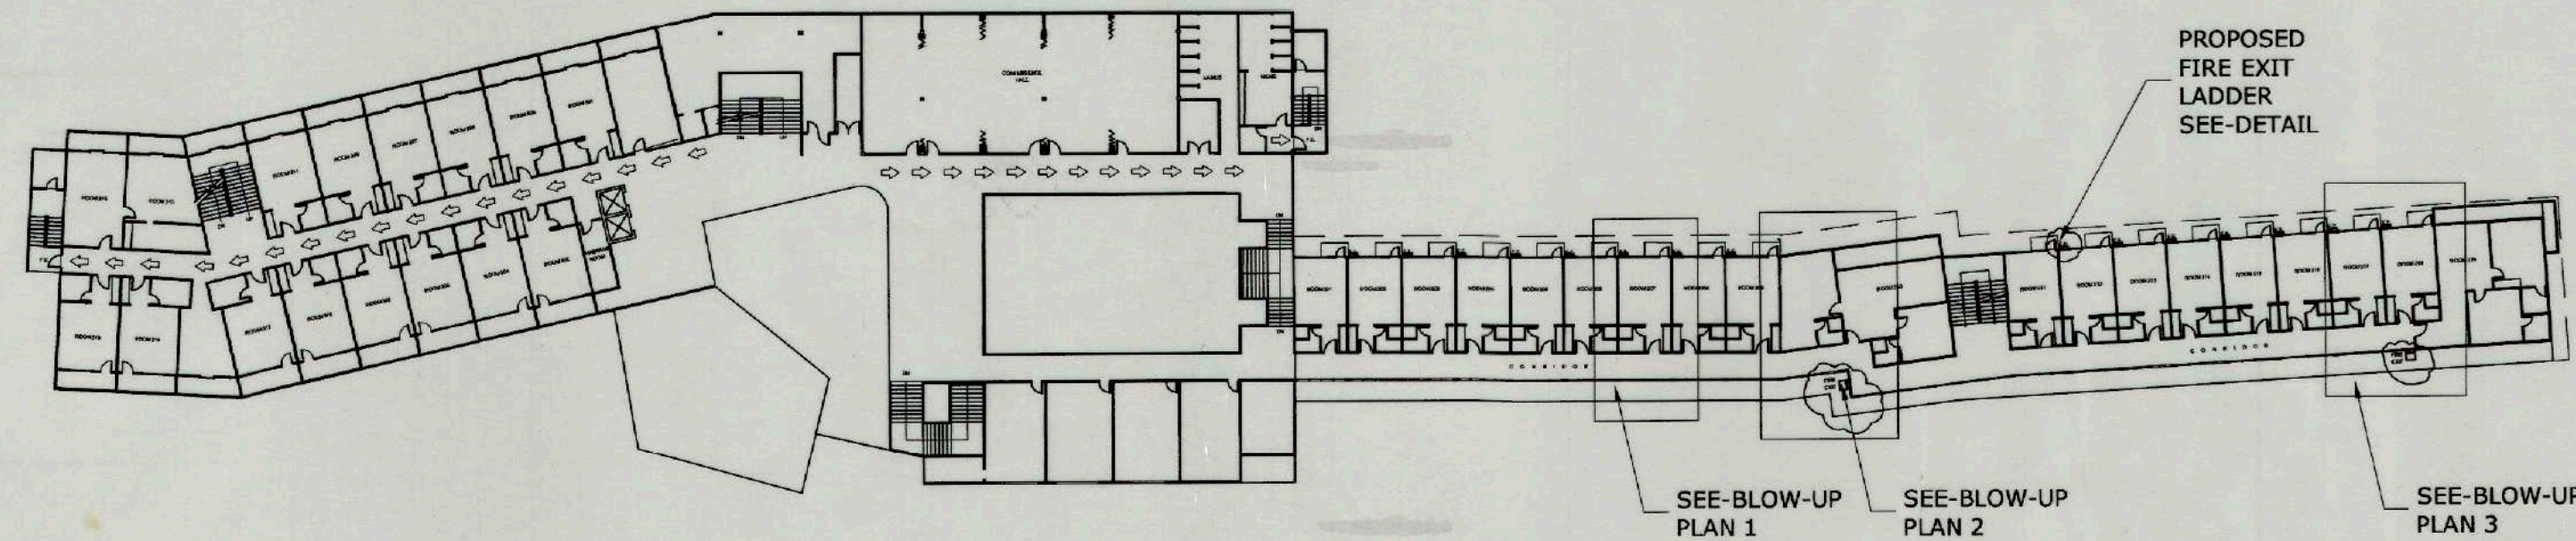


**SECOND FLOOR PLAN**

SCALE 1 : 500 MTS

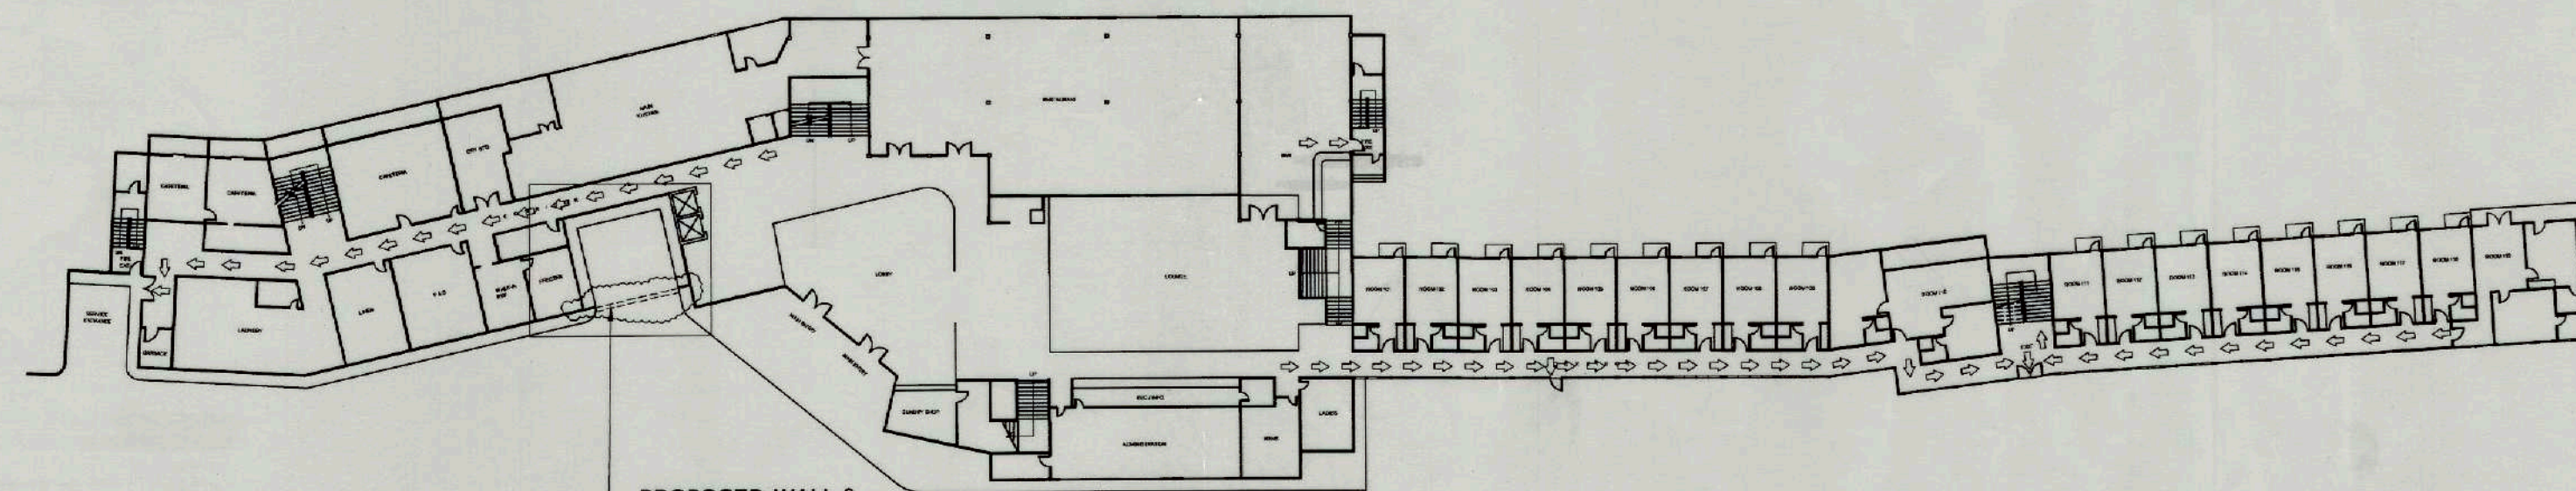


**GROUND FLOOR PLAN**

SCALE 1 : 500 MTS

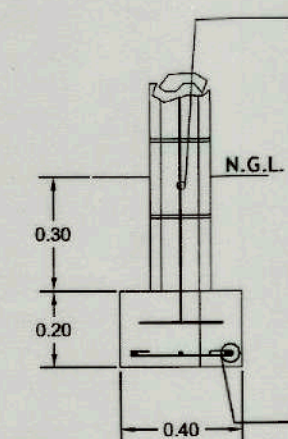


**WALL FOOTING DET.**

SCALE 1 : 20 MTS.

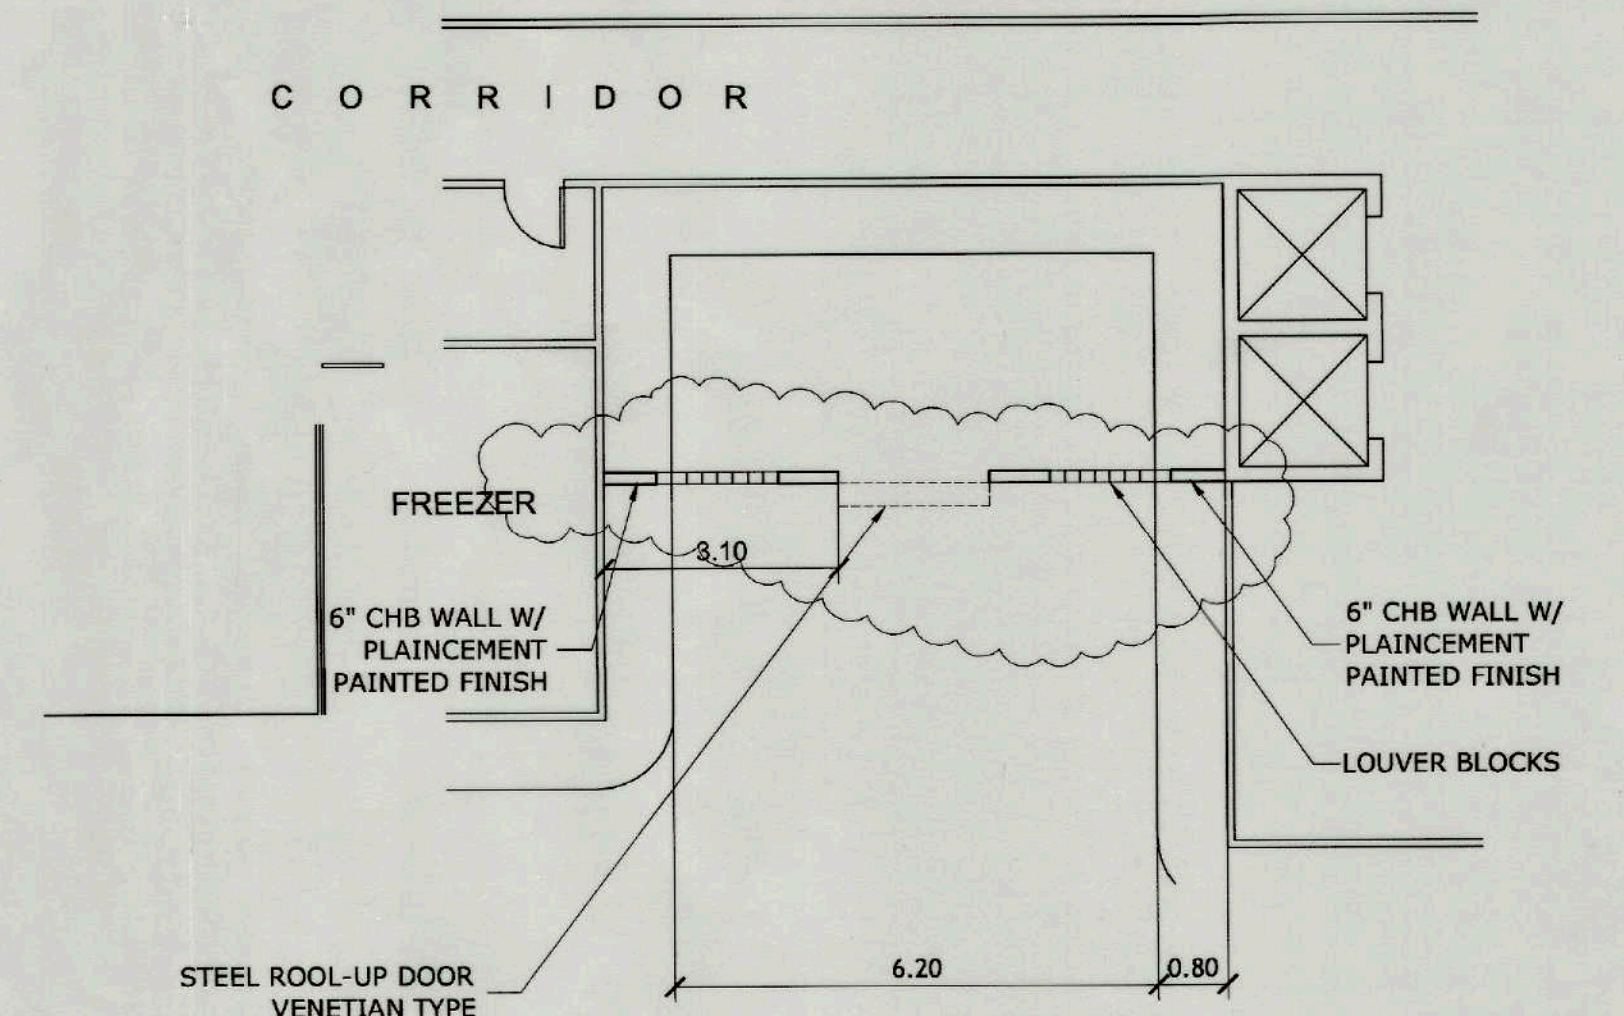

**BLOW UP PLAN**

SCALE 1 : 100 MTS

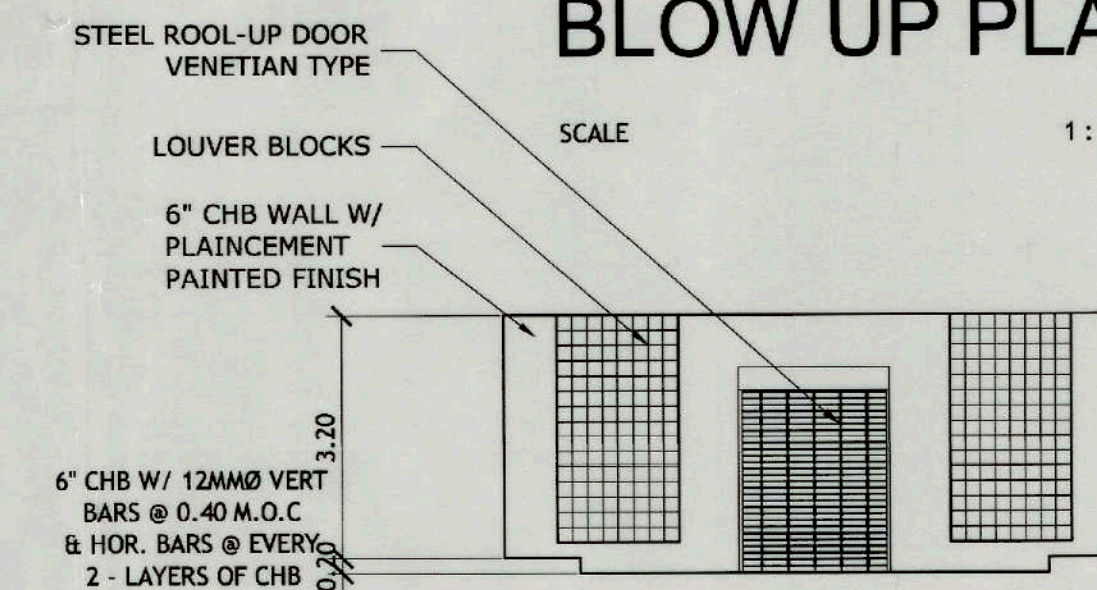

**FRONT ELEVATION**

SCALE 1 : 100 MTS

3 - 10MMØ LOPNGL. BARS  
W/ 12MMØ TRAVERSE  
BARS @ 0.30 M.O.C

CONFORME :

*[Signature]*  
**MARLON PRIETO**  
Resident Manager  
Banaue Hotel & Youth Hostel



**TIEZA**  
TOURISM INFRASTRUCTURE  
AND ENTERPRISE ZONE AUTHORITY  
142 AMORSOLO ST. LEGASPI VILLAGE  
MAKATI CITY

PROJECT TITLE/LOCATION

**EMERGENCY WORKS FOR COMPLIANCE  
WITH FIRE DEPARTMENT REQUIREMENT**

BANAUE,

IFUGAO

**PROJECT EVALUATION AND PLANNING DEPARTMENT**

PREPARED BY:

*[Signature]*  
**ODONILLO B. SAN JUAN**

DRAWN BY: O.B. SAN JUAN  
DATE:

CHECKED BY:

*[Signature]*  
**RADY E. ADAME**

OFFICER IN CHARGE  
PROJECT PLANNING & DESIGN DIVISION

REVIEWED BY:

*[Signature]*  
**AMELITA S. CAGANDA**

OFFICER-IN-CHARGE  
PROJECT EVALUATION & PLANNING DEPARTMENT

RECOMMENDING APPROVAL:

*[Signature]*  
**NESTOR M. DOMALANTA**

ASSISTANT CHIEF OPERATING OFFICER  
Architectural & Engineering Services Sector

APPROVED BY:

*[Signature]*  
**POCHOLO J. D. PARAGAS**

CHIEF OPERATING OFFICER

SHEET CONTENTS:

AS SHOWN

REVISIONS:


R.A. 545

SHEET NO.

**A 2**  
**12 23**


**CAR-17-04**



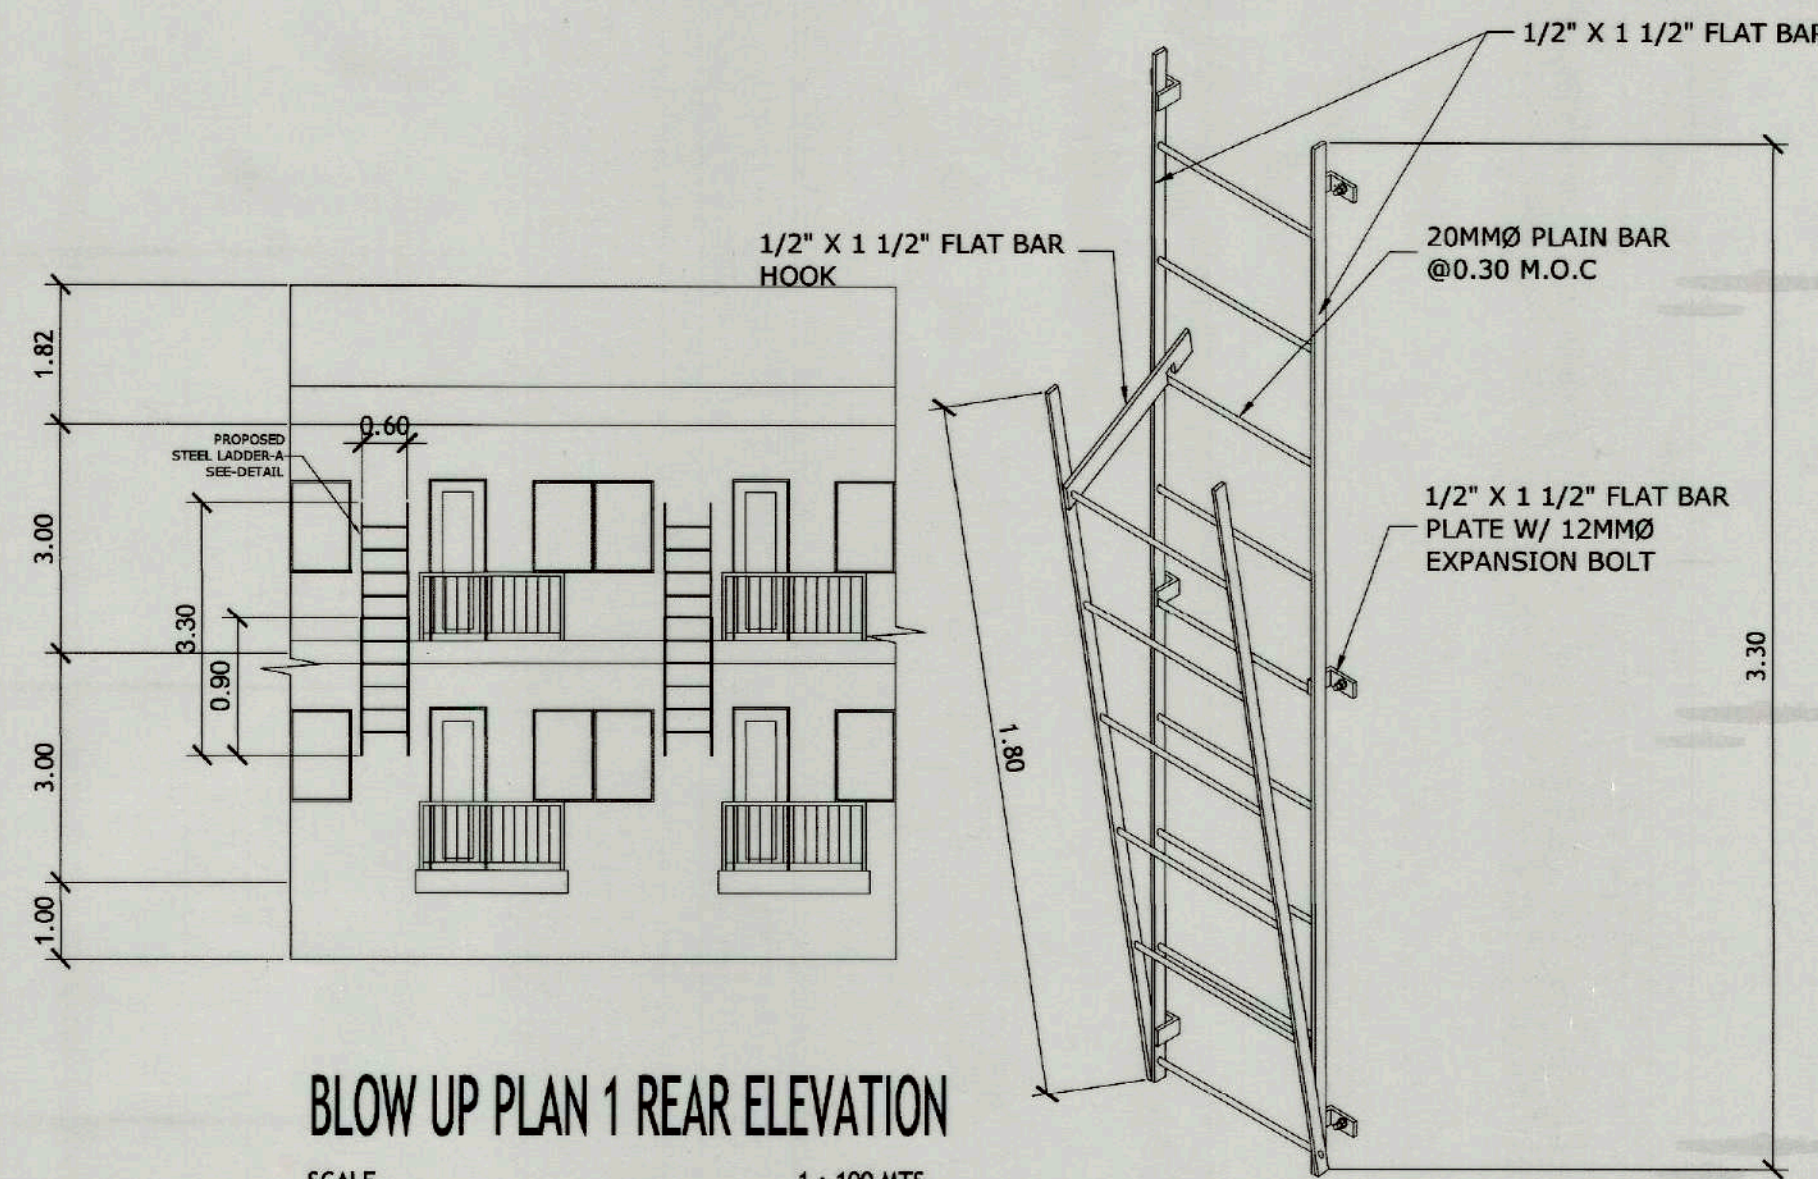


BLOW UP PLAN 1 REAR ELEVATION  
SCALE 1 : 100 MTS.


FIRE EXIT LADDER - A DETAIL  
NOT TO SCALE

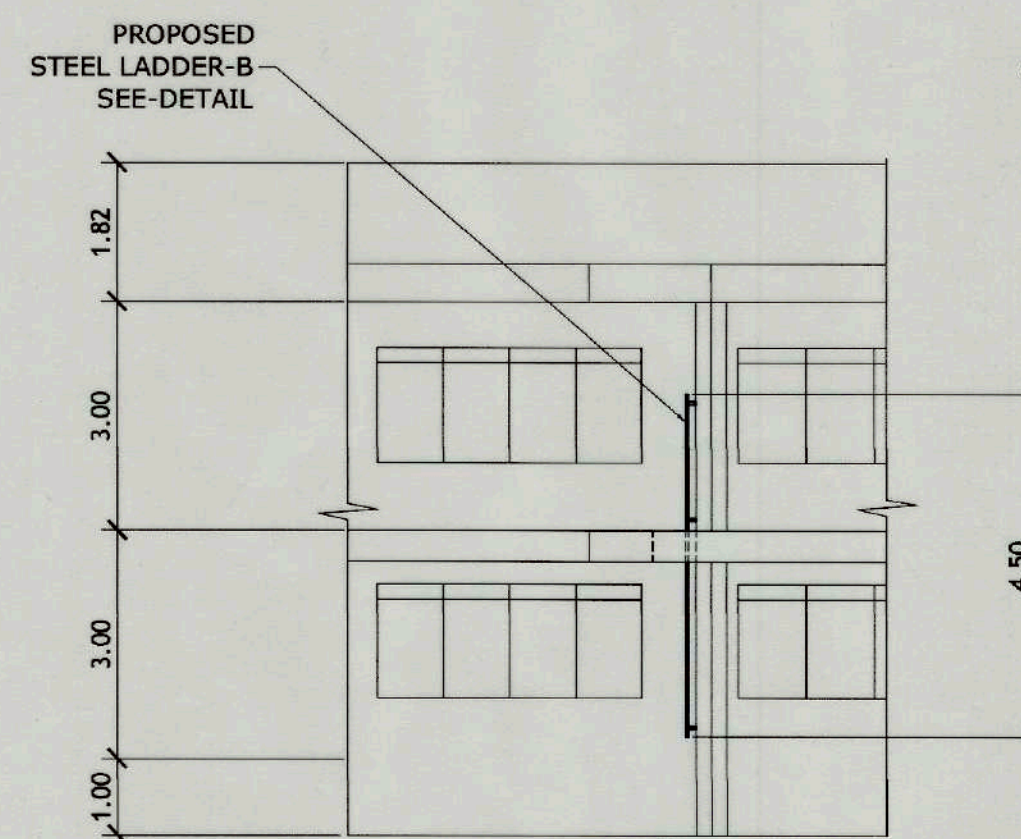


BLOW UP PLAN 2 FRONT ELEVATION  
SCALE 1 : 100 MTS.

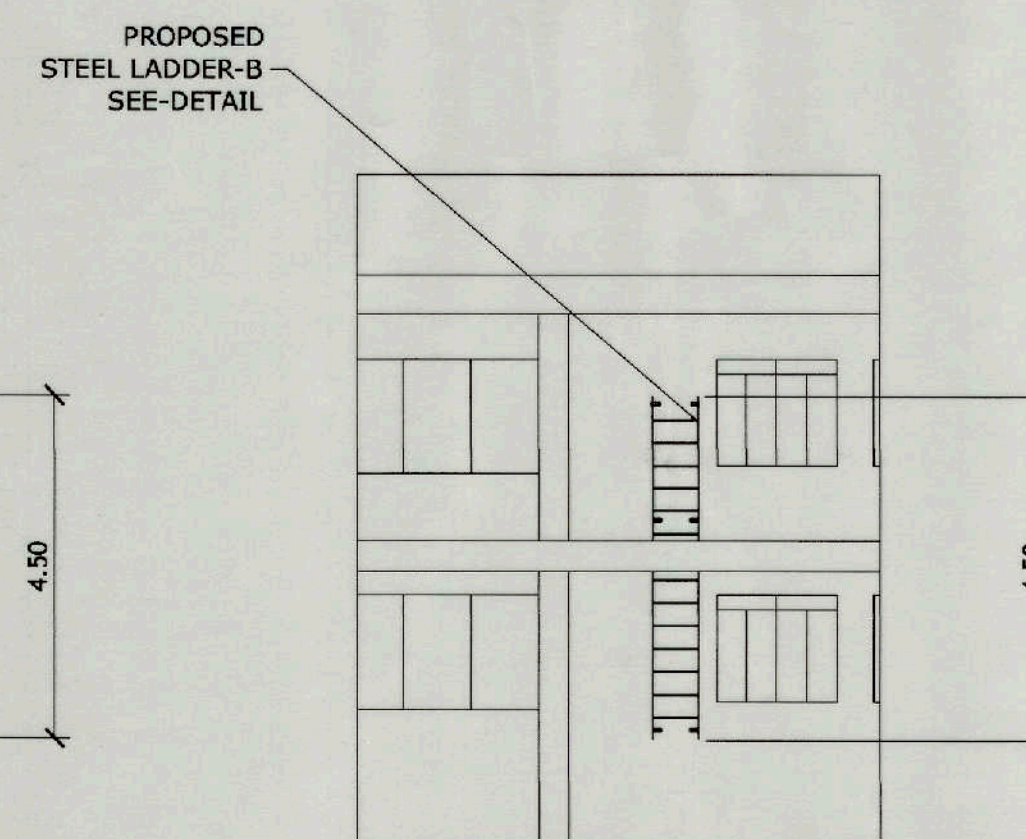


BLOW UP PLAN 3 FRONT ELEVATION  
SCALE 1 : 100 MTS.

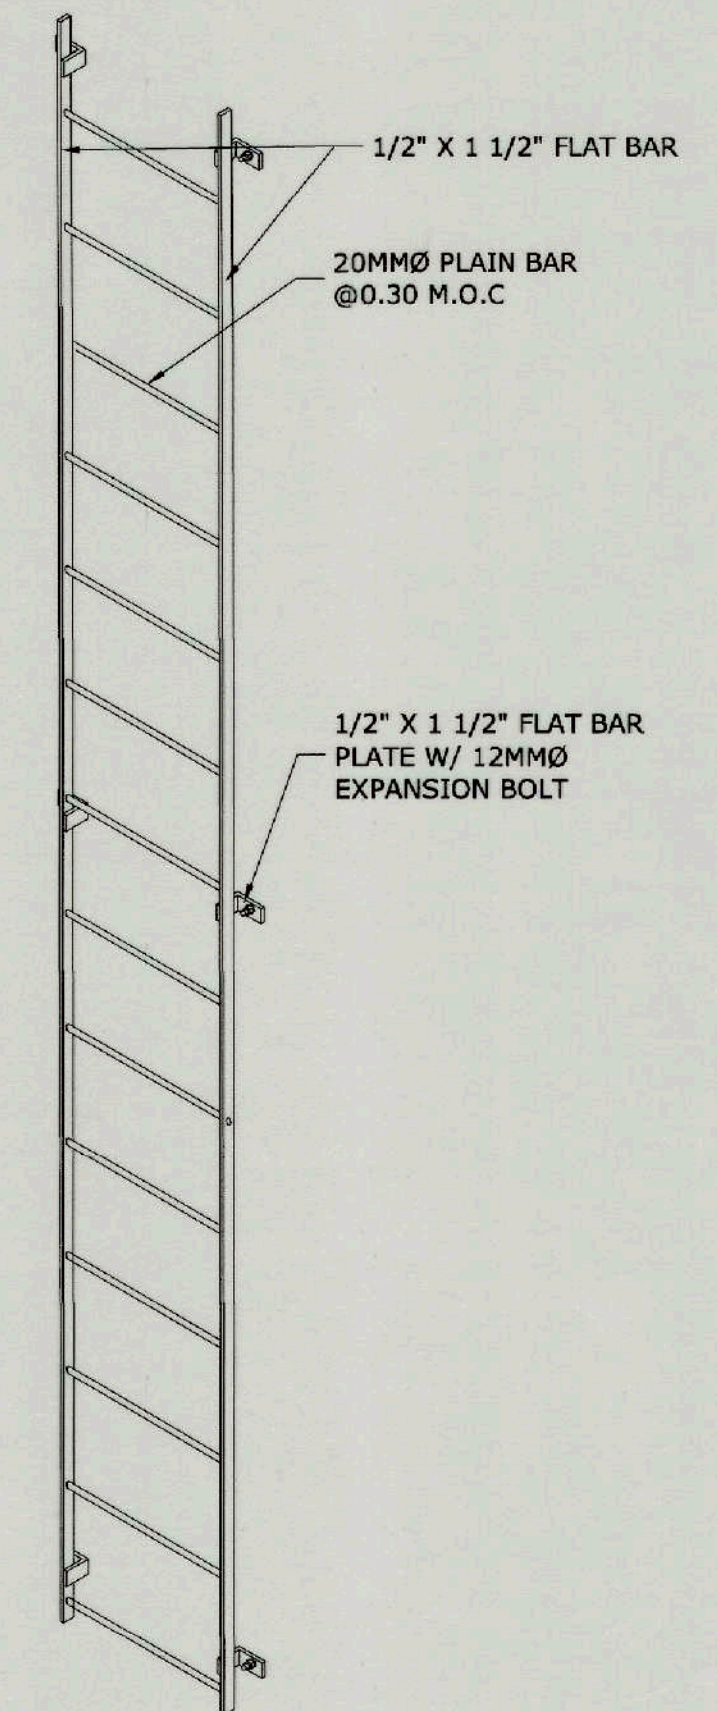


FIRE EXIT LADDER - B DETAIL  
NOT TO SCALE

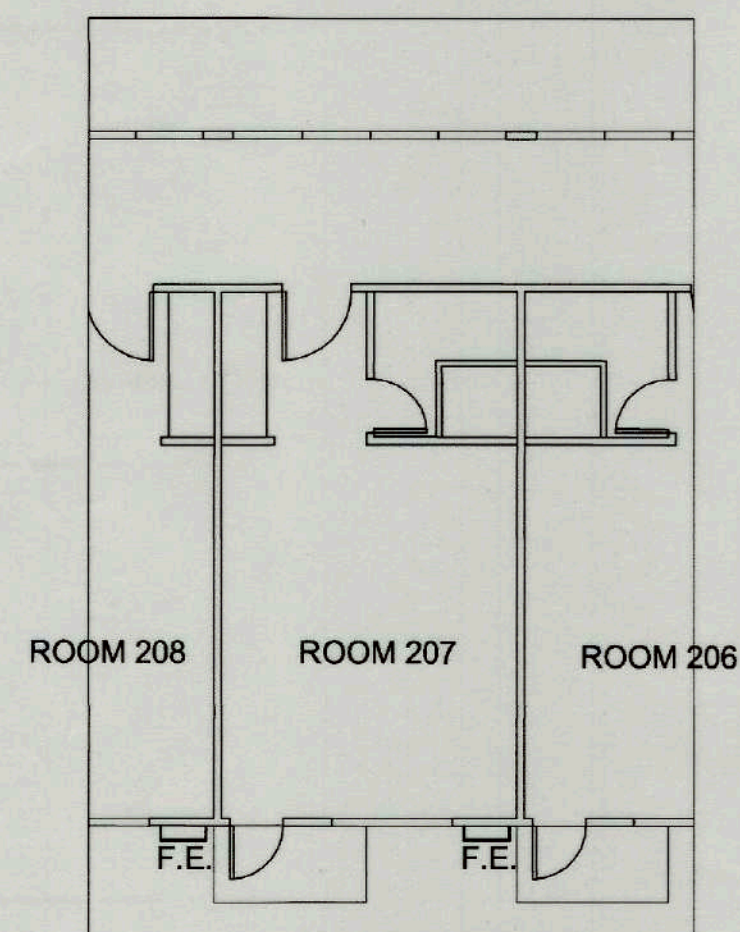

BLOW UP PLAN 1 (OLD BLDG.)  
SCALE 1 : 100 MTS.

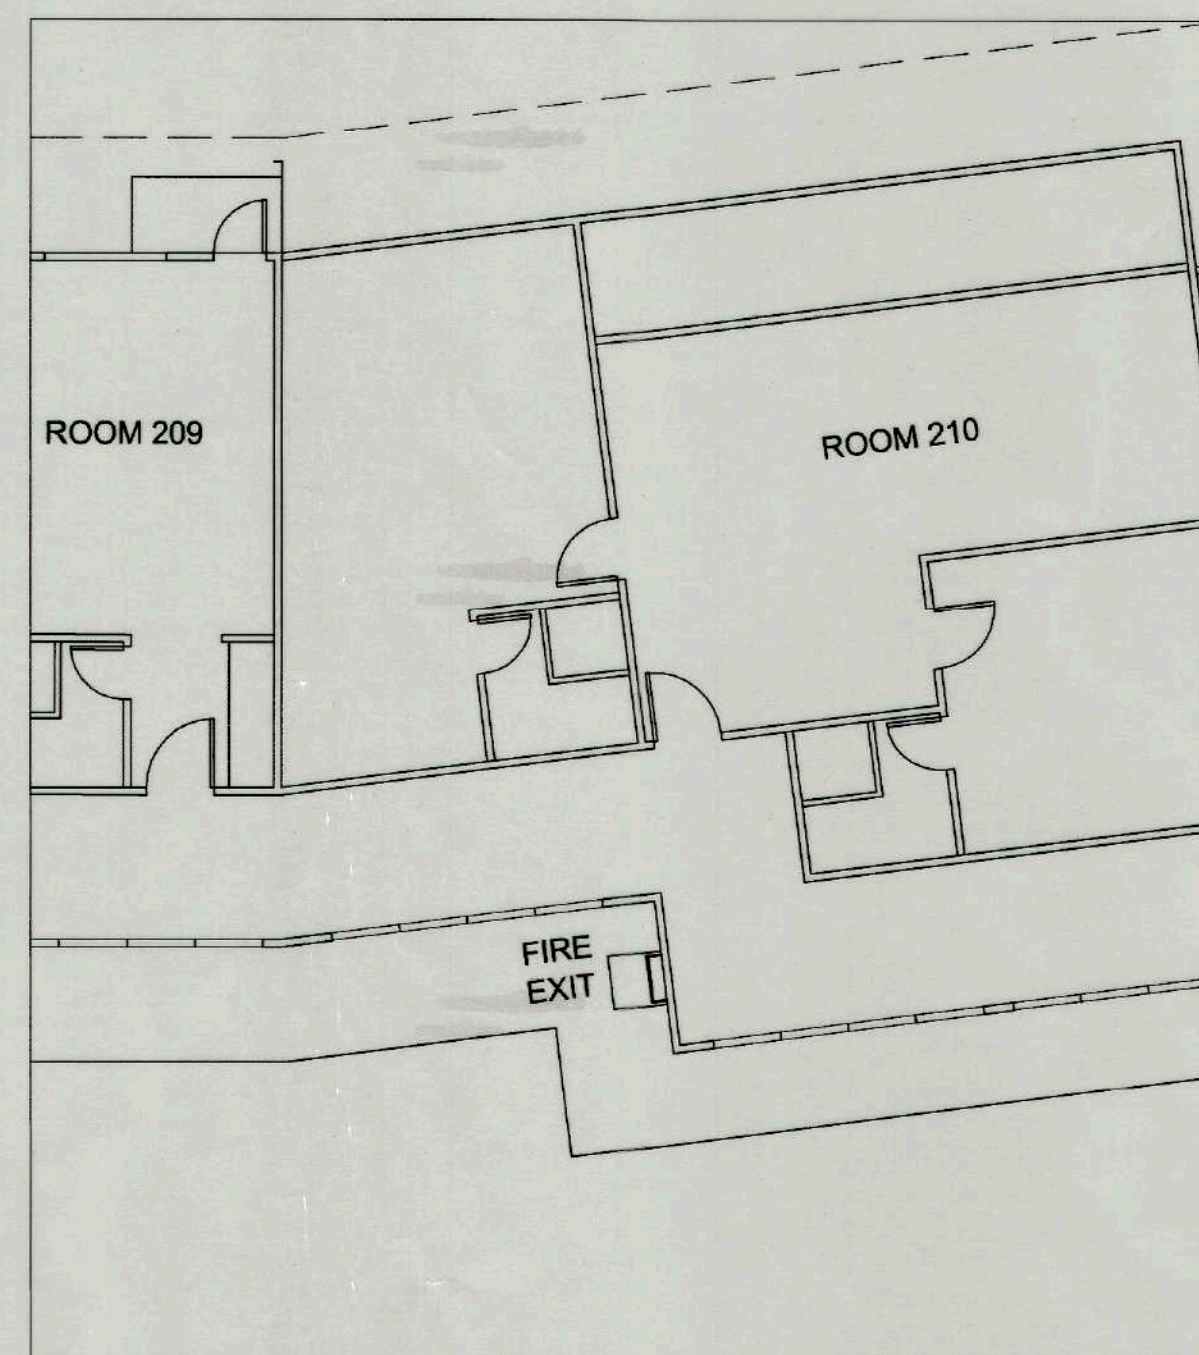

BLOW UP PLAN 2 (OLD BLDG.)  
SCALE 1 : 100 MTS.

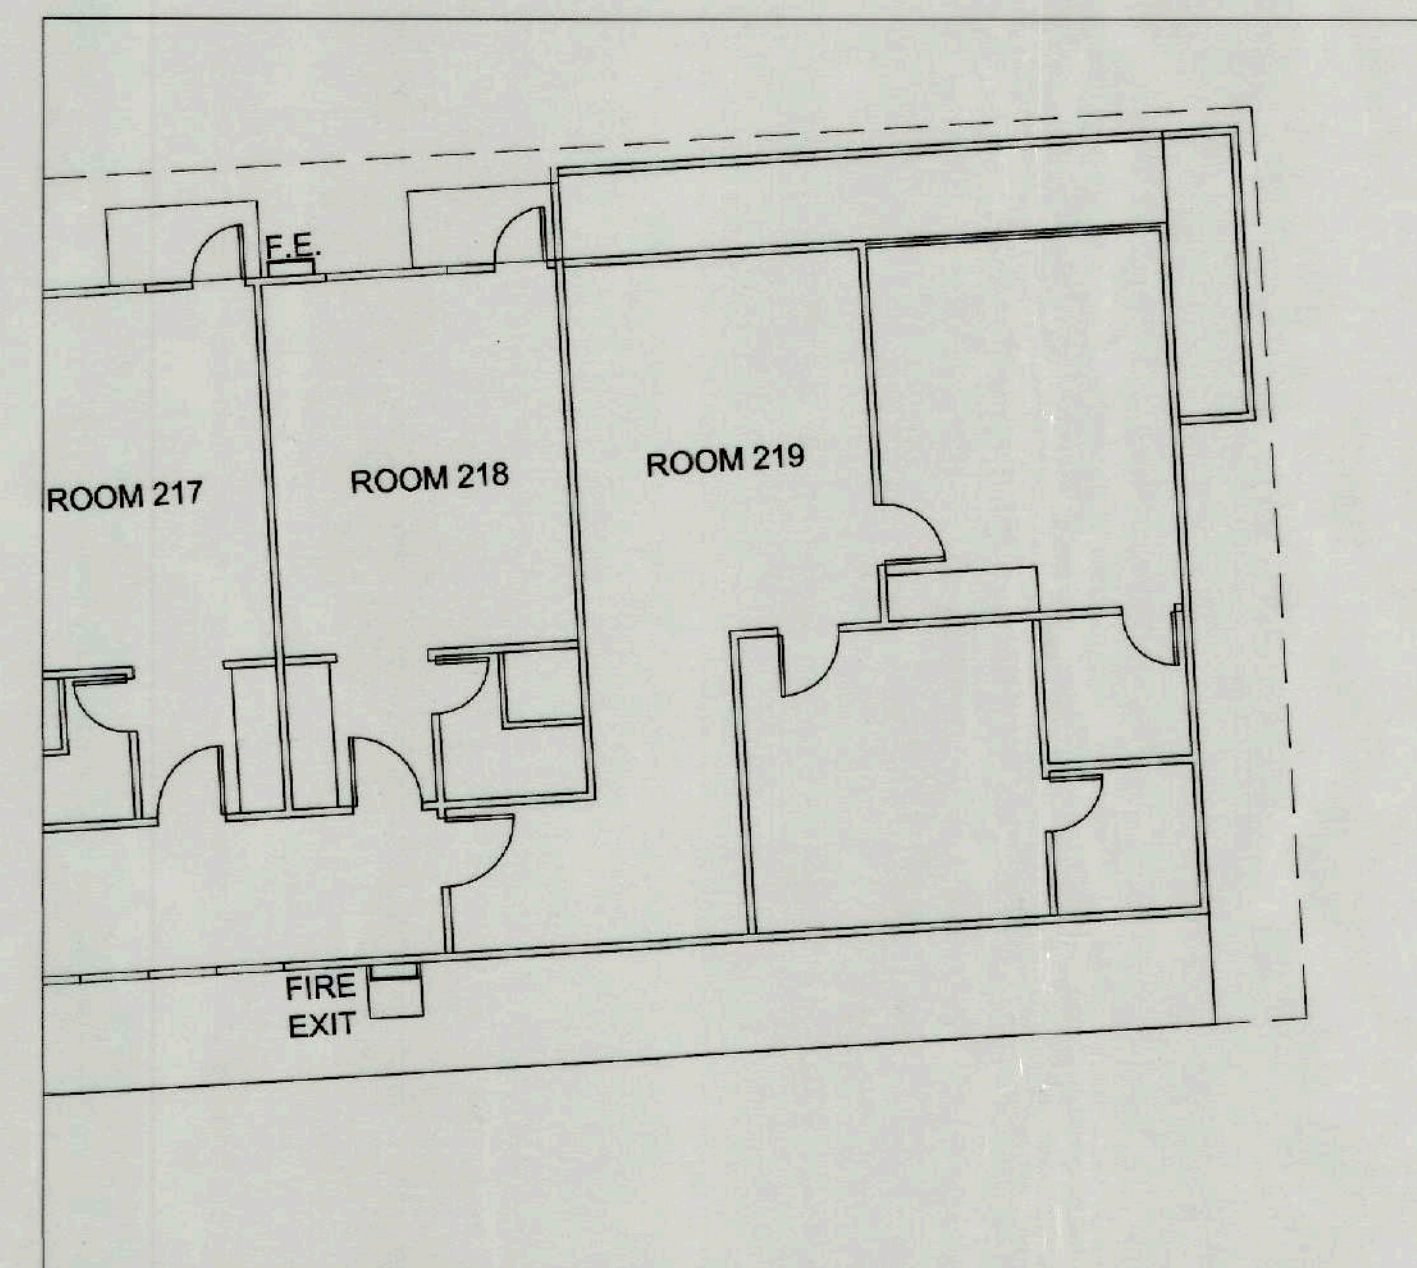

BLOW UP PLAN 3 (OLD BLDG.)  
SCALE 1 : 100 MTS.

|                                                                                                  |          |              |
|--------------------------------------------------------------------------------------------------|----------|--------------|
| CONFORME :                                                                                       |          |              |
| <br><b>MARLON PRIETO</b><br><small>Resident Manager<br/>Bananae Hotel &amp; Youth Hostel</small> |          |              |
| SHEET CONTENTS:                                                                                  | R.A. 545 | SHEET NO.    |
| AS SHOWN                                                                                         |          | A 3<br>12 23 |
| REVISIONS:                                                                                       |          |              |



**TIEZA**  
TOURISM INFRASTRUCTURE  
AND ENTERPRISE ZONE AUTHORITY  
142 AMORSOLO ST. LEGASPI VILLAGE  
MAKATI CITY

PROJECT TITLE/LOCATION  
**EMERGENCY WORKS FOR COMPLIANCE  
WITH FIRE DEPARTMENT REQUIREMENT**  
BANAUE, IFUGAO


PROJECT EVALUATION AND PLANNING DEPARTMENT

|                                          |                                                         |                                                               |
|------------------------------------------|---------------------------------------------------------|---------------------------------------------------------------|
| PREPARED BY:<br><br>ODONILLO B. SAN JUAN | CHECKED BY:<br><br>RADY E. ADAME                        | REVIEWED BY:<br><br>AMELITA S. CAGANDA                        |
| DRAWN BY:<br>O.B. SAN JUAN               | OFFICER IN CHARGE<br>PROJECT PLANNING & DESIGN DIVISION | OFFICER IN CHARGE<br>PROJECT EVALUATION & PLANNING DEPARTMENT |
| DATE:                                    |                                                         |                                                               |

|                                                                                  |                                           |
|----------------------------------------------------------------------------------|-------------------------------------------|
| RECOMMENDING APPROVAL:<br><br>NESTOR M. DOMALANTA                                | APPROVED BY:<br><br>POCHOLO J. D. PARAGAS |
| ASSISTANT CHIEF OPERATING OFFICER<br>Architectural & Engineering Services Sector | CHIEF OPERATING OFFICER                   |

CAR-17-04



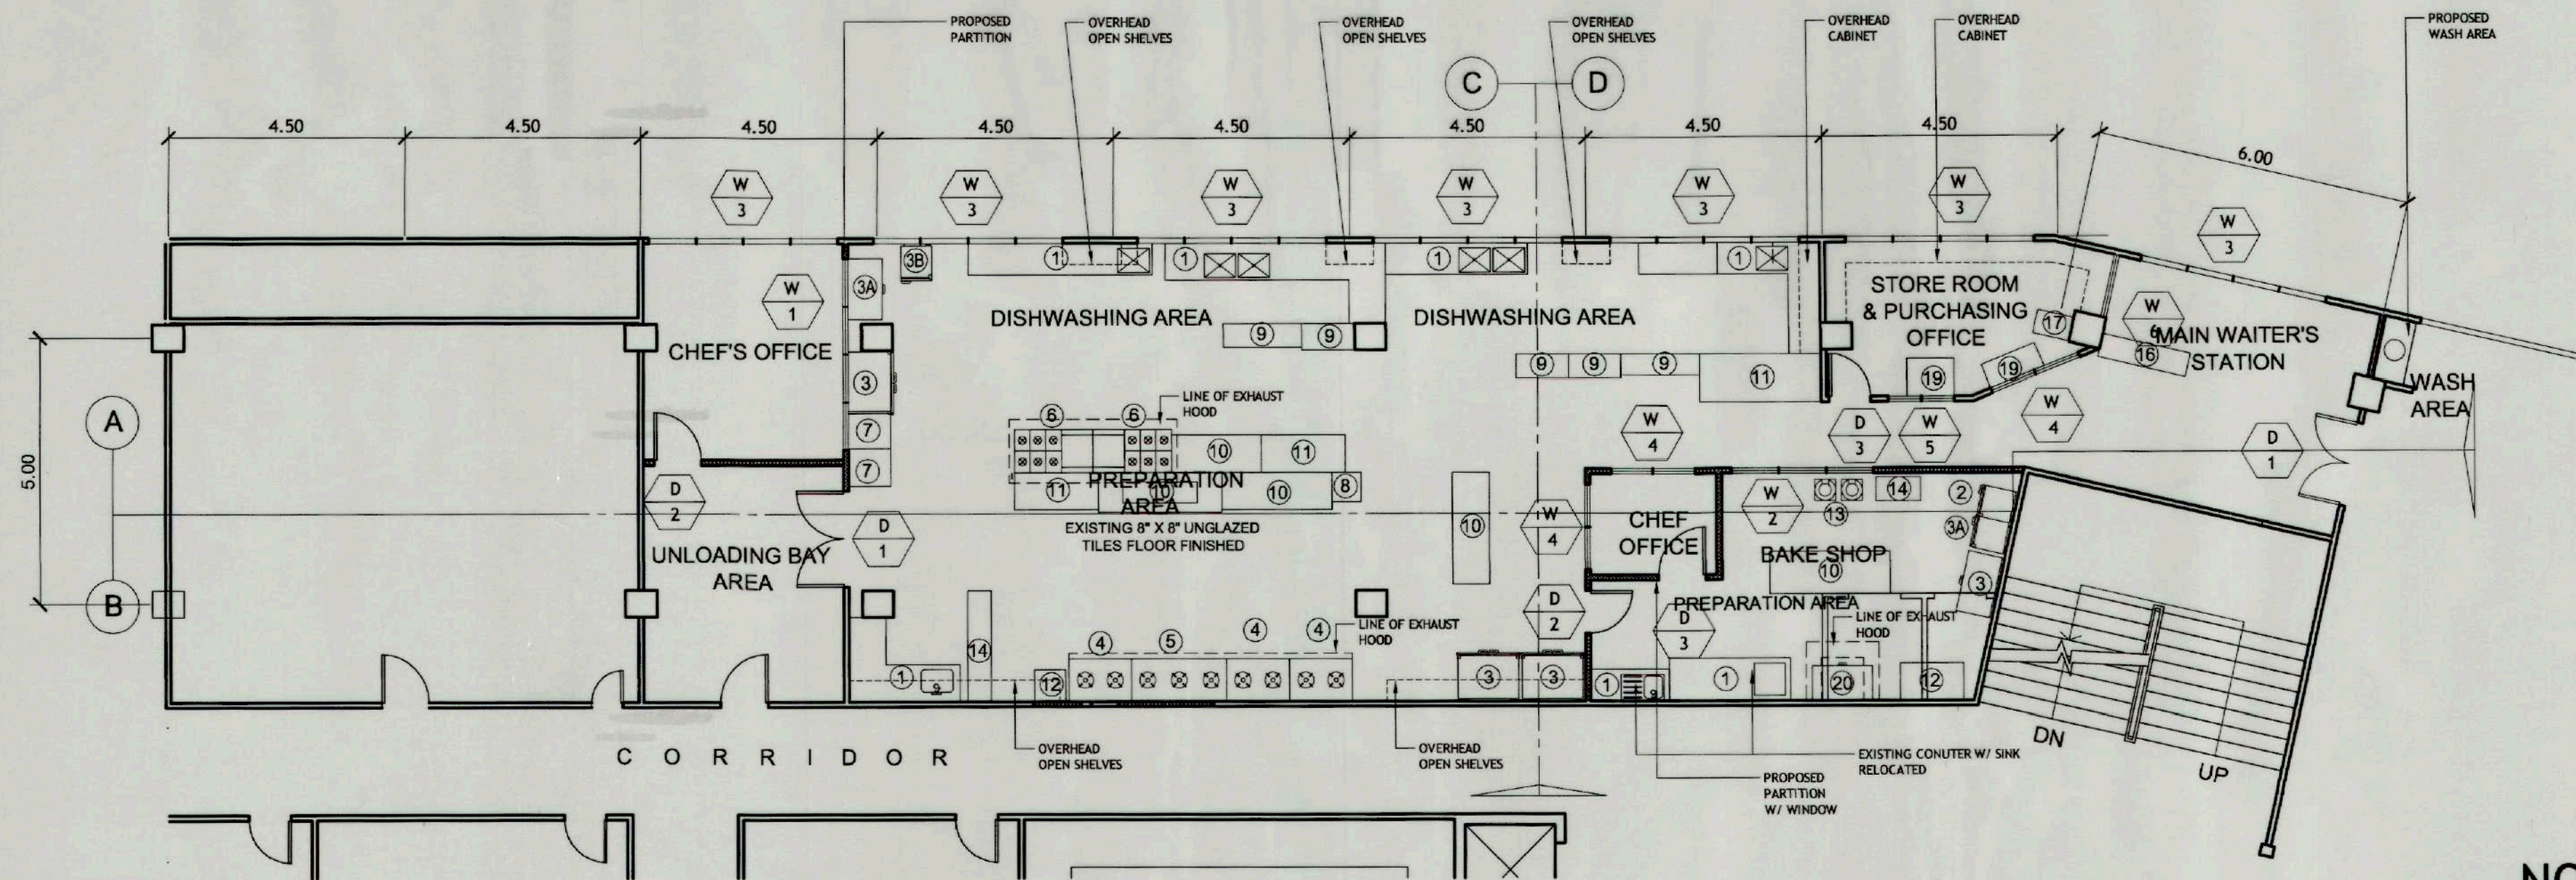


KITCHEN FLOOR PLAN (PROPOSED)

SCALE 1 : 100 MTS

NOTE: EXISTING

- ① RECEIVING SINK  
TABLE 8 - UNITS
- ② SINGLE DOOR  
REFRIGERATOR 3 - UNITS
- ③ CHILLER 4 - UNITS
- ③A CHEST FREEZER 1 - UNIT
- ③B UPRIGHT FREEZER 1 - UNIT
- ④ TWO OPEN BURNER 3 - UNITS
- ⑤ THREE OPEN BURNER 1 - UNIT
- ⑥ SIX BURNER RANGE W/  
GRILLER 2 - UNITS
- ⑦ ICE MAKER 2 - UNITS
- ⑧ CHOPPING BLOCK 1 - UNIT
- ⑨ GLASS RACK 5 - UNITS
- ⑩ WORK TABLE 3 - UNITS
- ⑪ WORK TABLE W/ BOT.  
SHELVES 1 - UNIT
- ⑫ RACK 1 - UNIT
- ⑬ DOUGH MIXER 2 - UNITS
- ⑭ POTS & PAN RACK 2 - UNITS
- ⑮ BOT. CABINET 4 - UNITS
- ⑯ COUNTER 1 - UNIT
- ⑰ FILING CABINET 1 - UNIT
- ⑱ WALL HUNG CABINET 1 - UNIT
- ⑲ OFFICE TABLE 1 - UNIT
- ⑳ OVEN 1 - UNIT

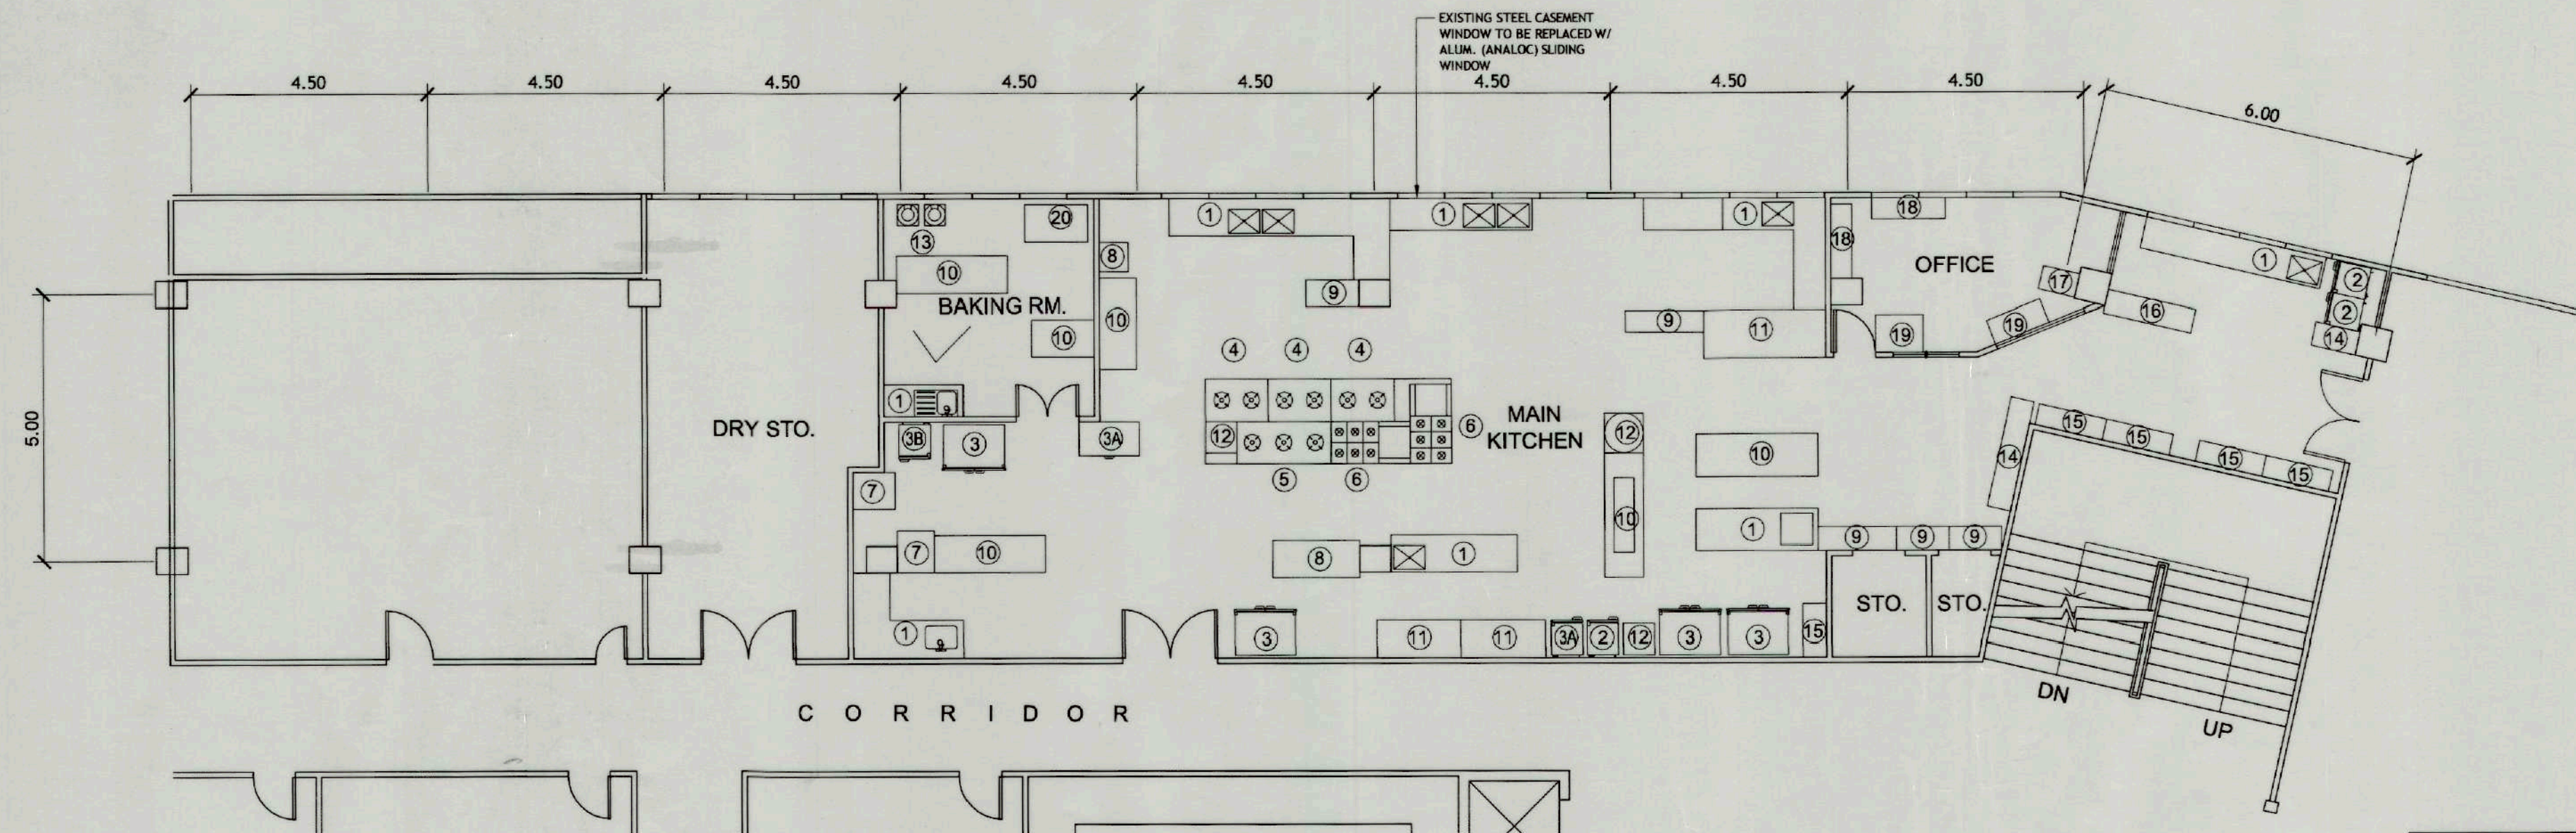

KITCHEN FLOOR PLAN (EXISTING)

SCALE 1 : 100 MTS

CONFORME :

*[Signature]*  
MARLON PRIETO  
Resident Manager  
Banaue Hotel & Youth Hostel



**TIEZA**  
TOURISM INFRASTRUCTURE  
AND ENTERPRISE ZONE AUTHORITY  
142 AMORSOLO ST. LEGASPI VILLAGE  
MAKATI CITY

PROJECT TITLE/LOCATION  
EMERGENCY WORKS FOR COMPLIANCE  
WITH FIRE DEPARTMENT REQUIREMENT  
BANAUE, IFUGAO

PROJECT EVALUATION AND PLANNING DEPARTMENT  
PREPARED BY: *[Signature]* ODDILO B. SAN JUAN  
CHECKED BY: *[Signature]* RADY E. ADAME  
REVIEWED BY: *[Signature]* AMELITA S. CAGANDA  
DRAWN BY: O.B. SAN JUAN  
DATE: \_\_\_\_\_  
OFFICER IN CHARGE  
PROJECT PLANNING & DESIGN DIVISION  
OFFICER IN CHARGE  
PROJECT EVALUATION & PLANNING DEPARTMENT

RECOMMENDING APPROVAL:  
*[Signature]*  
NESTOR M. DOMALANTA  
ASSISTANT CHIEF OPERATING OFFICER  
Architectural & Engineering Services Sector

APPROVED BY:  
*[Signature]*  
POCHOLO J. D. PARAGAS  
CHIEF OPERATING OFFICER


SHEET CONTENTS:  
AS SHOWN  
REVISIONS:

R.A. 545  
THIS DRAWING IS  
THE PROPERTY OF  
TOURISM ENTERPRISE  
ZONE AUTHORITY AND  
CANNOT BE REPRO-  
DUCED WITHOUT  
THEIR CONSENT.

SHEET NO.  
A 4  
12 23

CAR-17-04




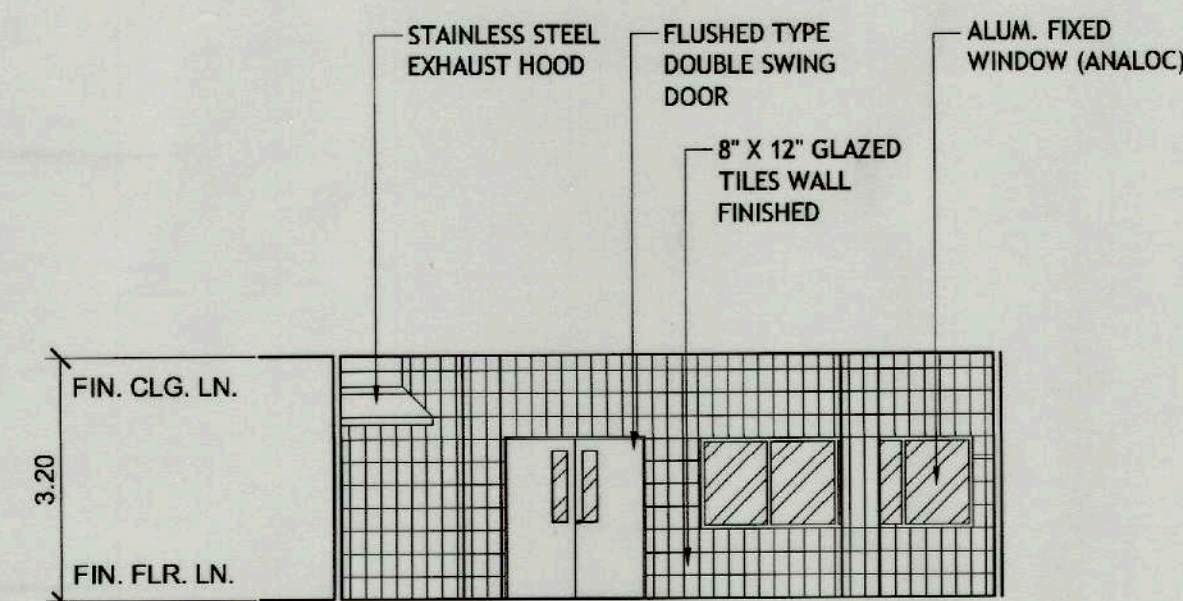

SECTION THRU LINE - C

SCALE


1 : 100 MTS

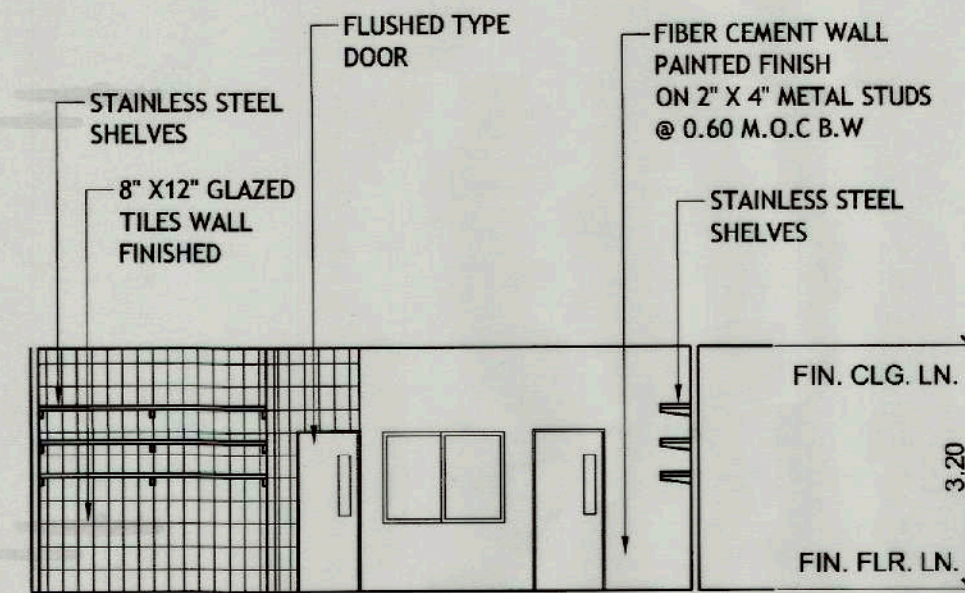

SECTION THRU LINE - D

SCALE


1 : 100 MTS

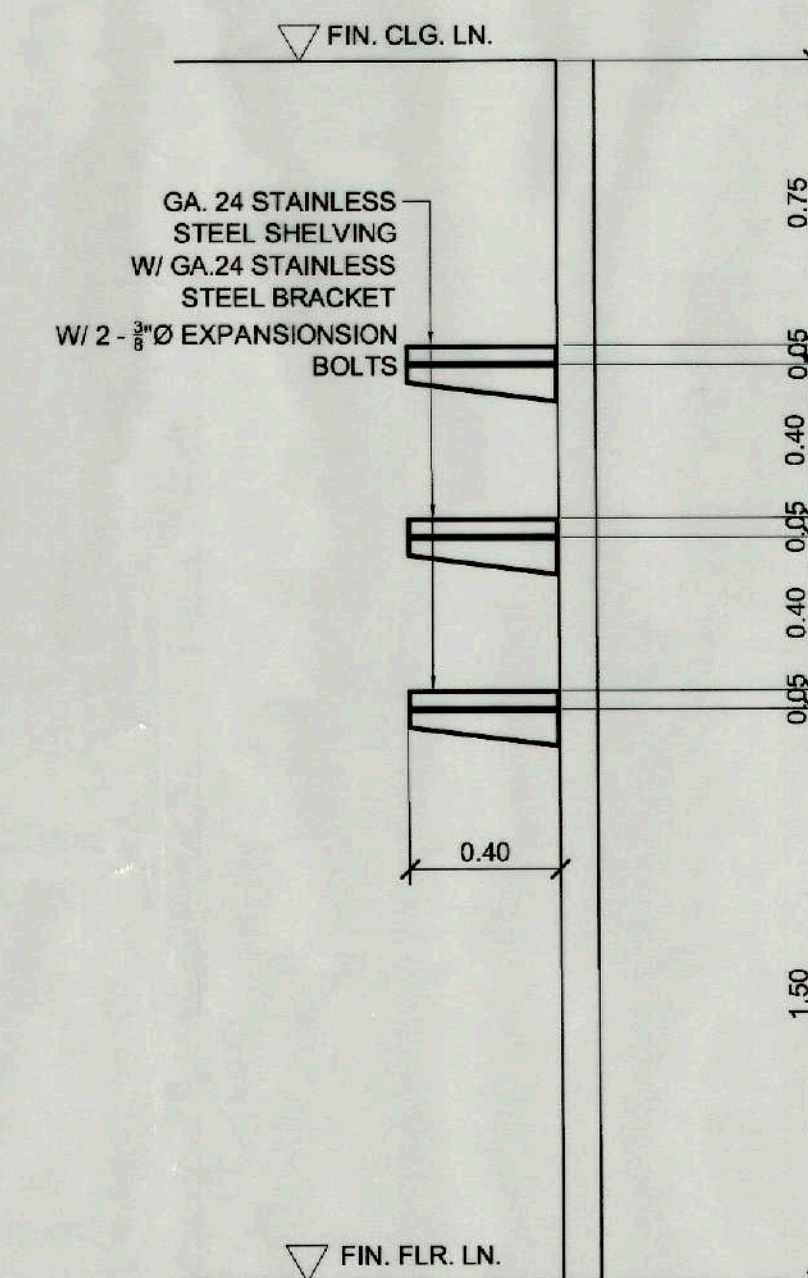

SHELVES DETAIL

SCALE


1 : 20 MTS

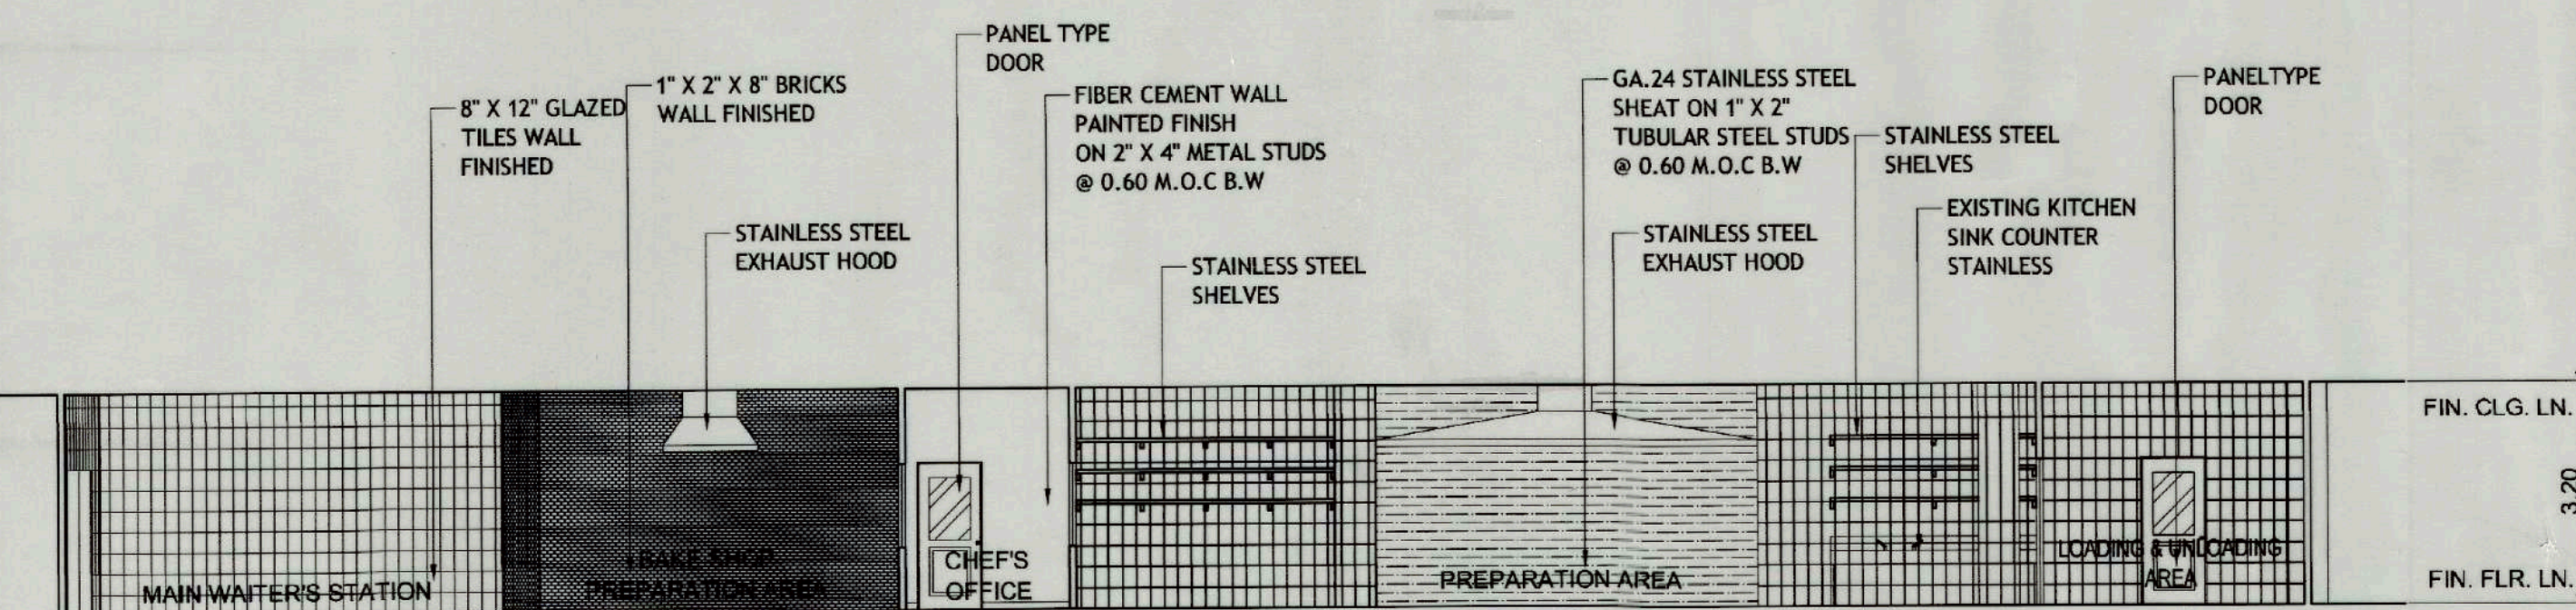

SECTION THRU LINE - B

SCALE

1 : 100 MTS

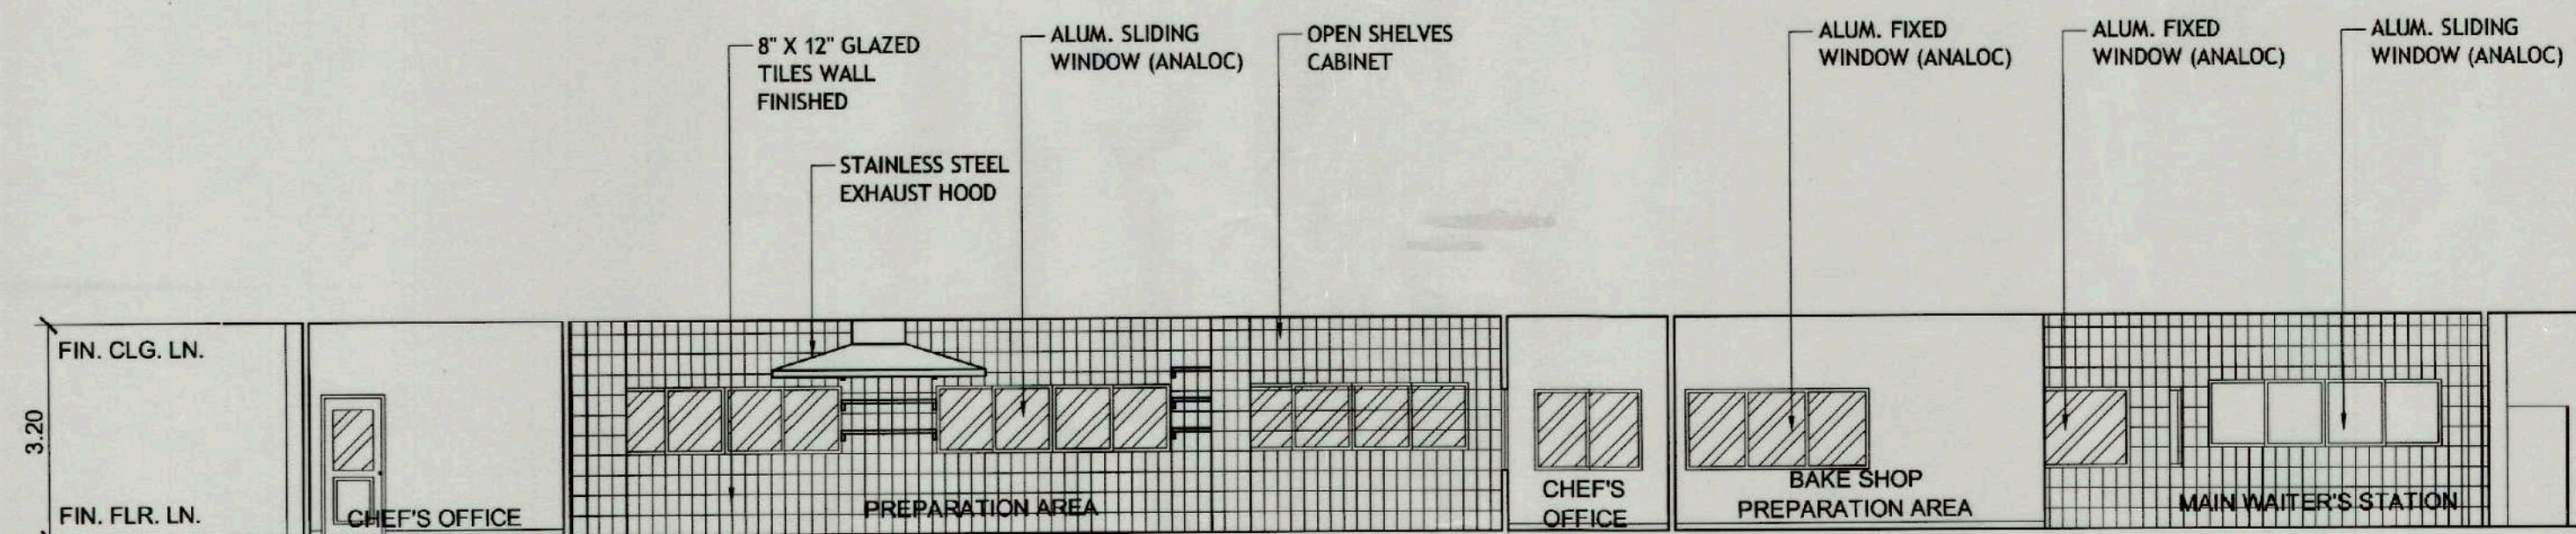

SECTION THRU LINE - A

SCALE

1 : 100 MTS

CONFORME :

*Marlon Prieto*  
MARLON PRIETO  
Resident Manager  
Banaue Hotel & Youth Hostel



**TIEZA**  
TOURISM INFRASTRUCTURE  
AND ENTERPRISE ZONE AUTHORITY  
142 AMORSOLO ST. LEGASPI VILLAGE  
MAKATI CITY

PROJECT TITLE/LOCATION

EMERGENCY WORKS FOR COMPLIANCE  
WITH FIRE DEPARTMENT REQUIREMENT

BANAUE,

IFUGAO

PROJECT EVALUATION AND PLANNING DEPARTMENT

PREPARED BY:

ODONILLO B. SAN JUAN

DRAWN BY: O.B. SAN JUAN

DATE:

CHECKED BY:

RADY E. ADAME

OFFICER IN CHARGE

PROJECT PLANNING & DESIGN DIVISION

REVIEWED BY:

AMELITA S. CAGANDA

OFFICER IN CHARGE

PROJECT EVALUATION & PLANNING DEPARTMENT

RECOMMENDING APPROVAL:

NESTOR M. DOMALANTA

ASSISTANT CHIEF OPERATING OFFICER

Architectural & Engineering Services Sector

APPROVED BY:

POCHOLO J. D. PARAGAS

CHIEF OPERATING OFFICER

SHEET CONTENTS:

AS SHOWN

R.A. 545


THIS DRAWING IS  
THE PROPERTY OF  
TOURISM ENTERPRISE  
ZONE AUTHORITY AND  
CANNOT BE REPRO-  
DUCED WITHOUT  
THEIR CONSENT.

SHEET NO.


A 5  
12 23

CAR-17-04




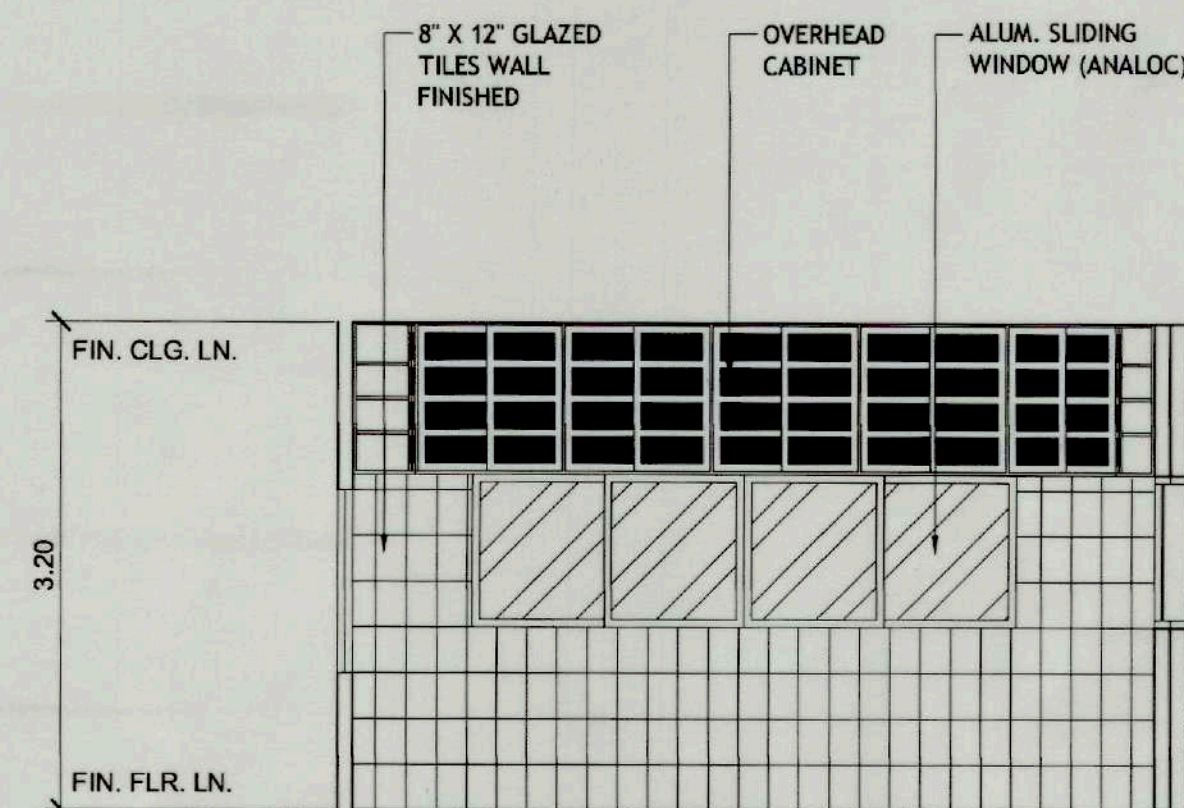


SECTION THRU LINE - A  
SCALE 1 : 50 MTS

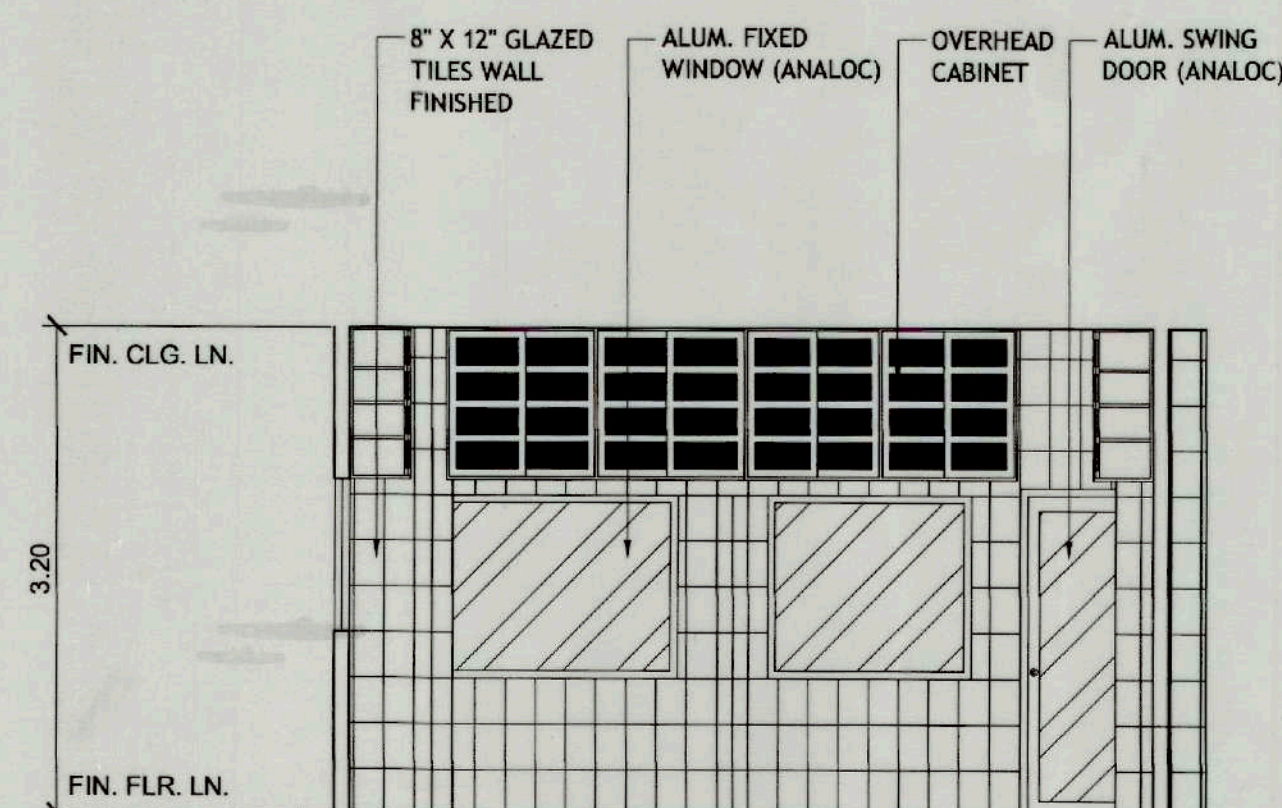


SECTION THRU LINE - B  
SCALE 1 : 50 MTS

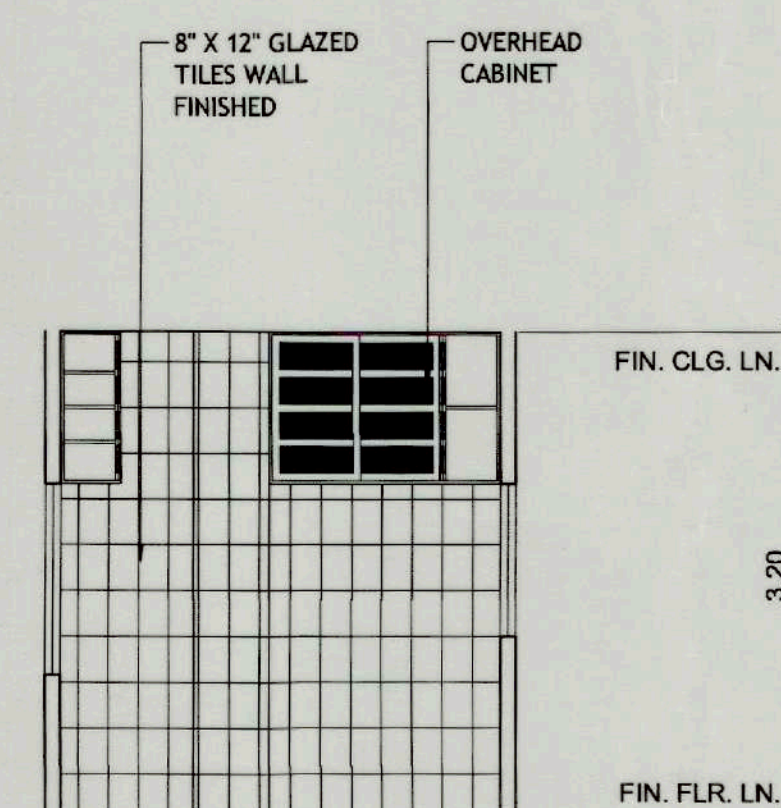


SECTION THRU LINE - C  
SCALE 1 : 50 MTS

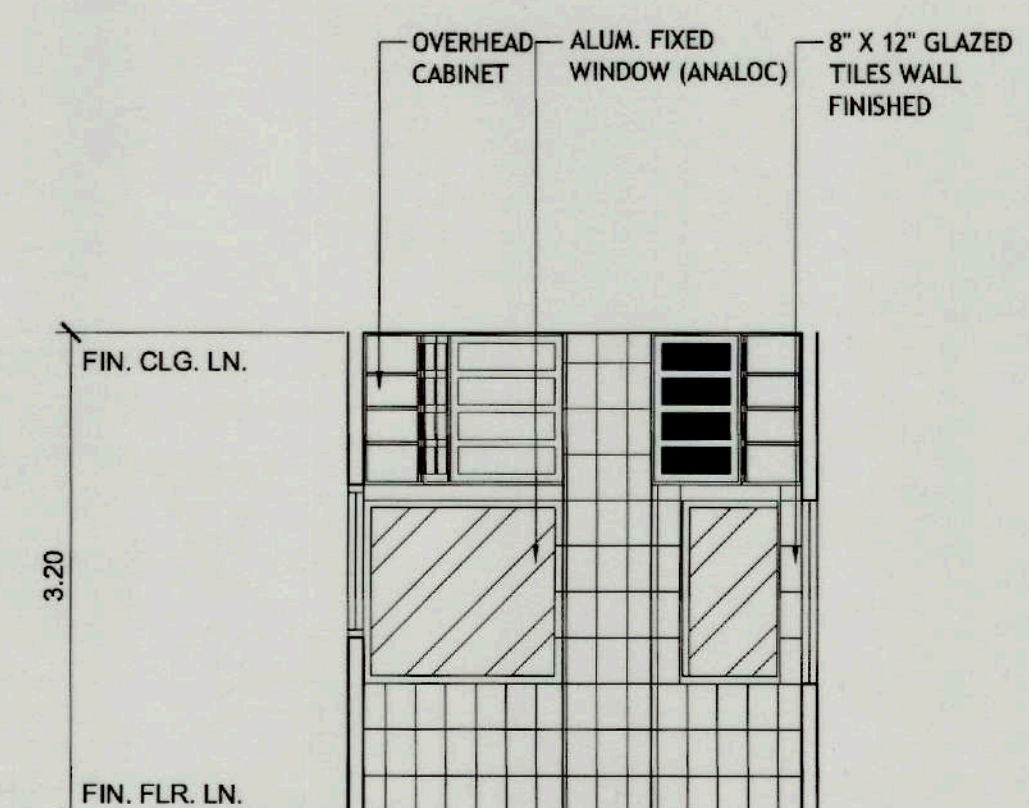

SECTION THRU LINE - D  
SCALE 1 : 50 MTS

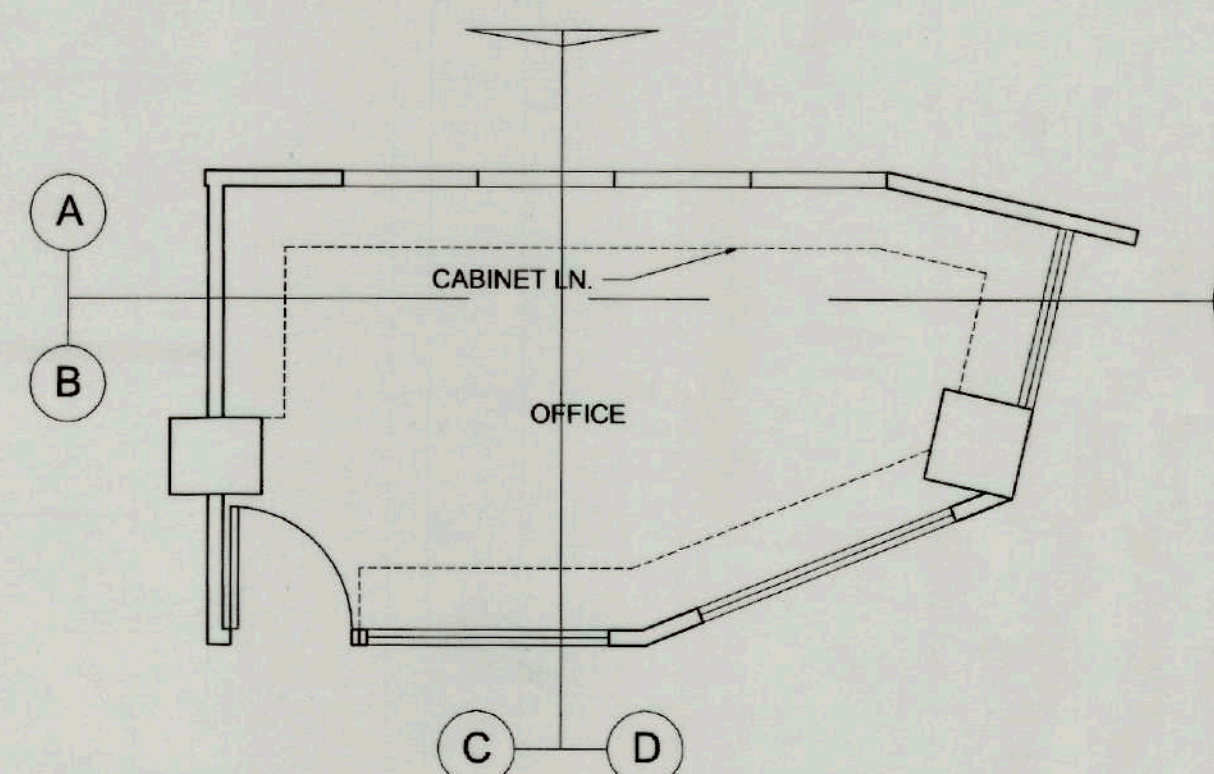

KITCHEN OFFICE FLOOR PLAN  
SCALE 1 : 50 MTS

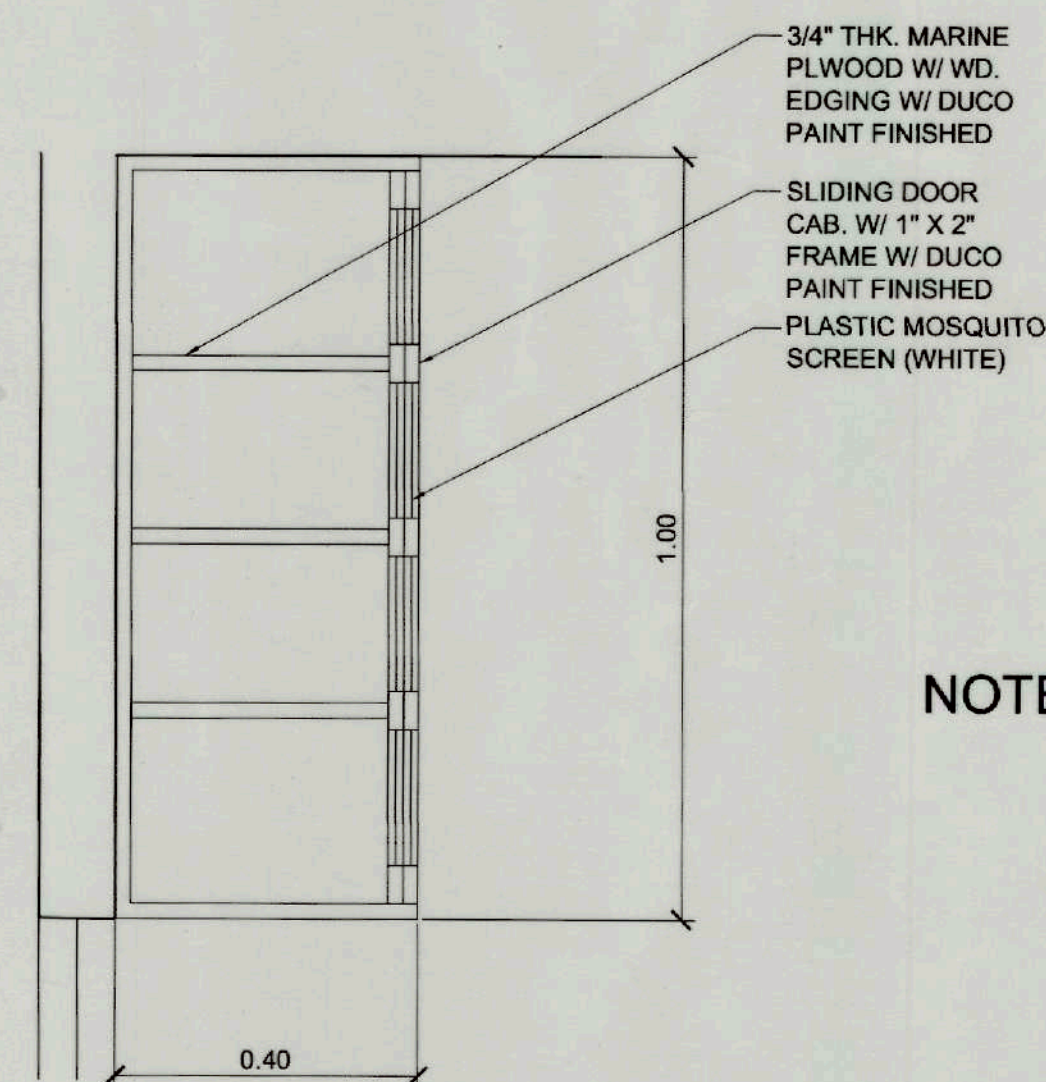

CABINET SECTION  
SCALE 1 : 10 MTS

NOTE:

1. PROVIDE ALUM. ROLLER GUIDE RAIL.
2. PROVIDE ROLLER FOR EVERY CABINET DOOR.

CONFORME :

*Marlon Prieto*  
MARLON PRIETO  
Resident Manager  
Bambue Hotel & Youth Hostel



**TIEZA**  
TOURISM INFRASTRUCTURE  
AND ENTERPRISE ZONE AUTHORITY  
142 AMORSOLO ST. LEGASPI VILLAGE  
MAKATI CITY

PROJECT TITLE/LOCATION

EMERGENCY WORKS FOR COMPLIANCE  
WITH FIRE DEPARTMENT REQUIREMENT

BANAUE,

IFUGAO

PROJECT EVALUATION AND PLANNING DEPARTMENT

PREPARED BY:  
*Odono B. San Juan*  
ODONO B. SAN JUAN

DRAWN BY: O.B. SAN JUAN  
DATE:

CHECKED BY:  
*Rady E. Adame*  
RADY E. ADAME

OFFICER IN CHARGE  
PROJECT PLANNING & DESIGN DIVISION

REVIEWED BY:  
*Amelita S. Caganda*  
AMELITA S. CAGANDA

OFFICER IN CHARGE  
PROJECT EVALUATION & PLANNING DEPARTMENT

RECOMMENDING APPROVAL:

*Nestor M. Domalanta*  
NESTOR M. DOMALANTA

ASSISTANT CHIEF OPERATING OFFICER  
Architectural & Engineering Services Sector

APPROVED BY:

*Pocholo J. D. Paragas*  
POCHOLO J. D. PARAGAS

CHIEF OPERATING OFFICER

SHEET CONTENTS:

AS SHOWN

R.A. 545

 

THIS DRAWING IS  
THE PROPERTY OF  
TOURISM ENTERPRISE  
ZONE AUTHORITY AND  
CANNOT BE REPRO-  
DUCED WITHOUT  
THEIR CONSENT.

SHEET NO.


A 6  
12 23

CAR-17-04



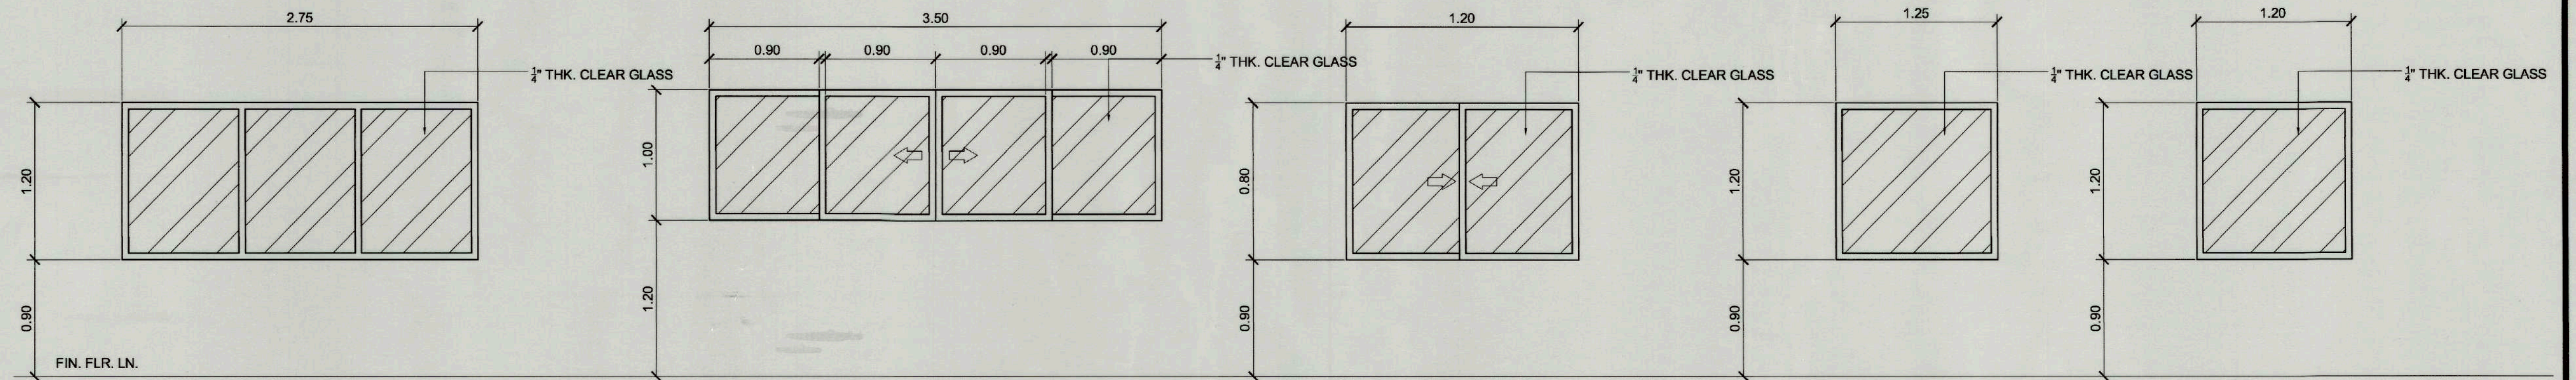

 
ALUMINUM FIXED (ANALOC) WINDOW  
COMPLETE ACCESSORIES  
1 - SET




ALUMINUM SLIDING (ANALOC) WINDOW  
COMPLETE ACCESSORIES  
7 - SETS




 
ALUMINUM FIXED (ANALOC) WINDOW  
COMPLETE ACCESSORIES  
3 - SETS



 ALUMINUM FIXED (ANALOC) WINDOW  
COMPLETE ACCESSORIES  
1 - SET



 ALUMINUM FIXED (ANALOC) WINDOW  
COMPLETE ACCESSORIES  
1 - SET

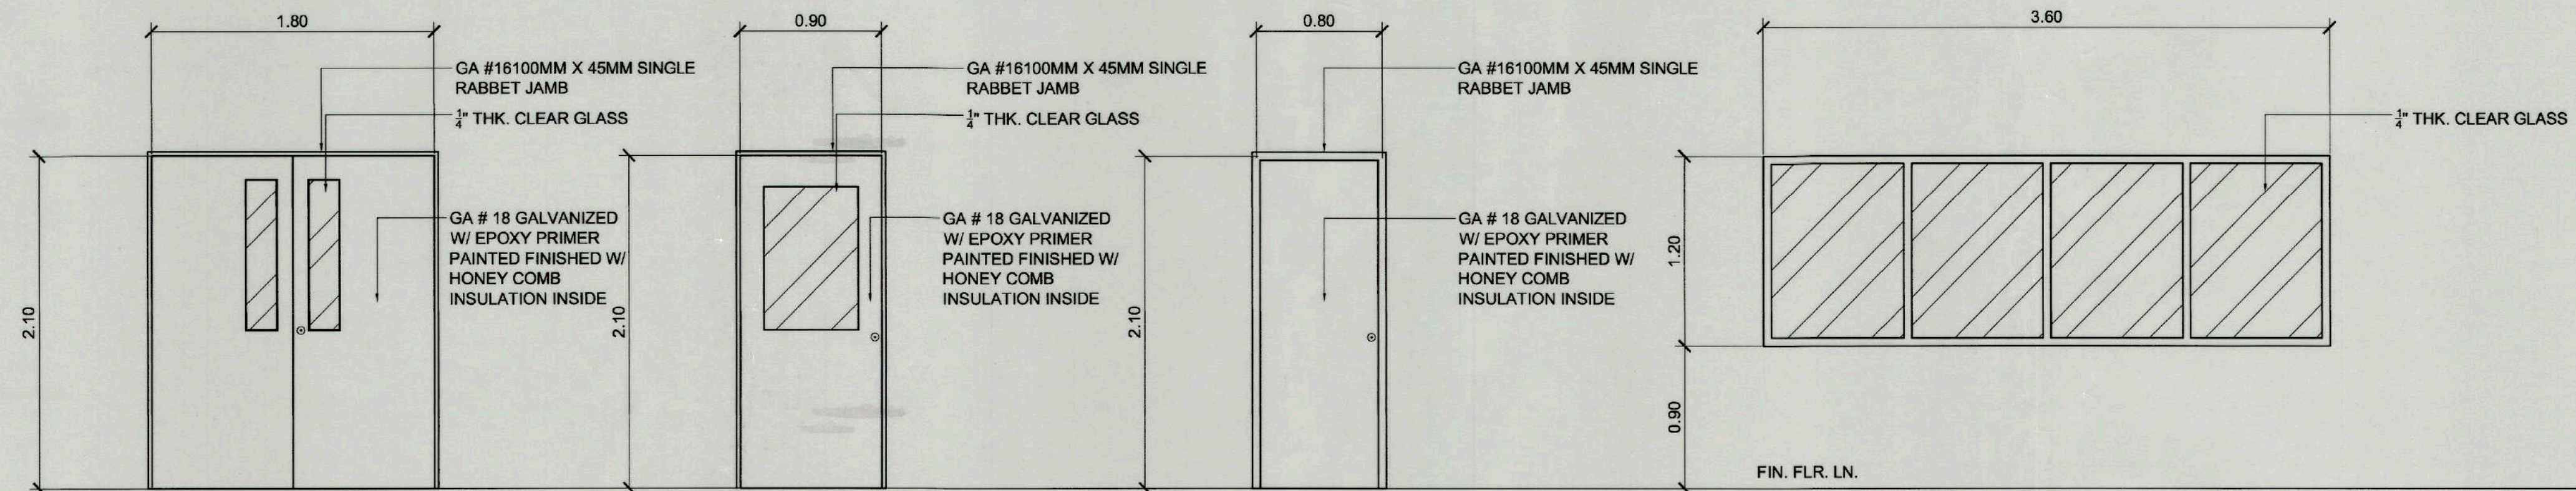


FIRE RATED STEEL FLUSHED TYPE DOOR NARROW W/  
DOUBLE PIVOTED HINGES COMPLETE ACCESSORIES  
2 - SETS



FIRE RATED STEEL FLUSHED TYPE DOOR HALF  
CLEAR GLASS COMPLETE ACCESSORIES  
2 - SETS



 FIRE RATED STEEL FLUSHED TYPE DOOR  
PLAIN 2 - SETS



ALUMINUM (ANALOC) FIXED WINDOW  
COMPLETE ACCESSORIES  
1 - SET

## SCHEDULE OF DOORS & WINDOWS

SCALE

1 : 30 MTS

CONFORME :

MARLON PRIETO  
Resident Manager  
Banua Hotel & Youth Hostel



**TIEZA**  
TOURISM INFRASTRUCTURE  
AND ENTERPRISE ZONE AUTHORITY  
142 AMORSOLO ST. LEGASPI VILLAGE  
MAKATI CITY

PROJECT TITLE/LOCATION  
EMERGENCY WORKS FOR COMPLIANCE  
WITH FIRE DEPARTMENT REQUIREMENT  
BANAUE, IFUGAO

### PROJECT EVALUATION AND PLANNING DEPARTMENT

PREPARED BY:  
ODONILLO B. SAN JUAN  
DRAWN BY: O.B. SAN JUAN  
DATE:

CHECKED BY:  
RADY E. ADAME  
OFFICER IN CHARGE  
PROJECT PLANNING & DESIGN DIVISION

REVIEWED BY:  
AMELITA S. CAGANBA  
OFFICER IN CHARGE  
PROJECT EVALUATION & PLANNING DEPARTMENT

RECOMMENDING APPROVAL:  
NESTOR M. DOMALANTA  
ASSISTANT CHIEF OPERATING OFFICER  
Architectural & Engineering Services Sector

APPROVED BY:  
POCHOLO J. D. PARAGAS  
CHIEF OPERATING OFFICER


SHEET CONTENTS:  
AS SHOWN  
REVISIONS:

R.A. 545  
THIS DRAWING IS  
THE PROPERTY OF  
TOURISM ENTERPRISE  
ZONE AUTHORITY AND  
CANNOT BE REPRO-  
DUCED WITHOUT  
THEIR CONSENT.

SHEET NO.  
A 7  
12 23

CAR-17-04



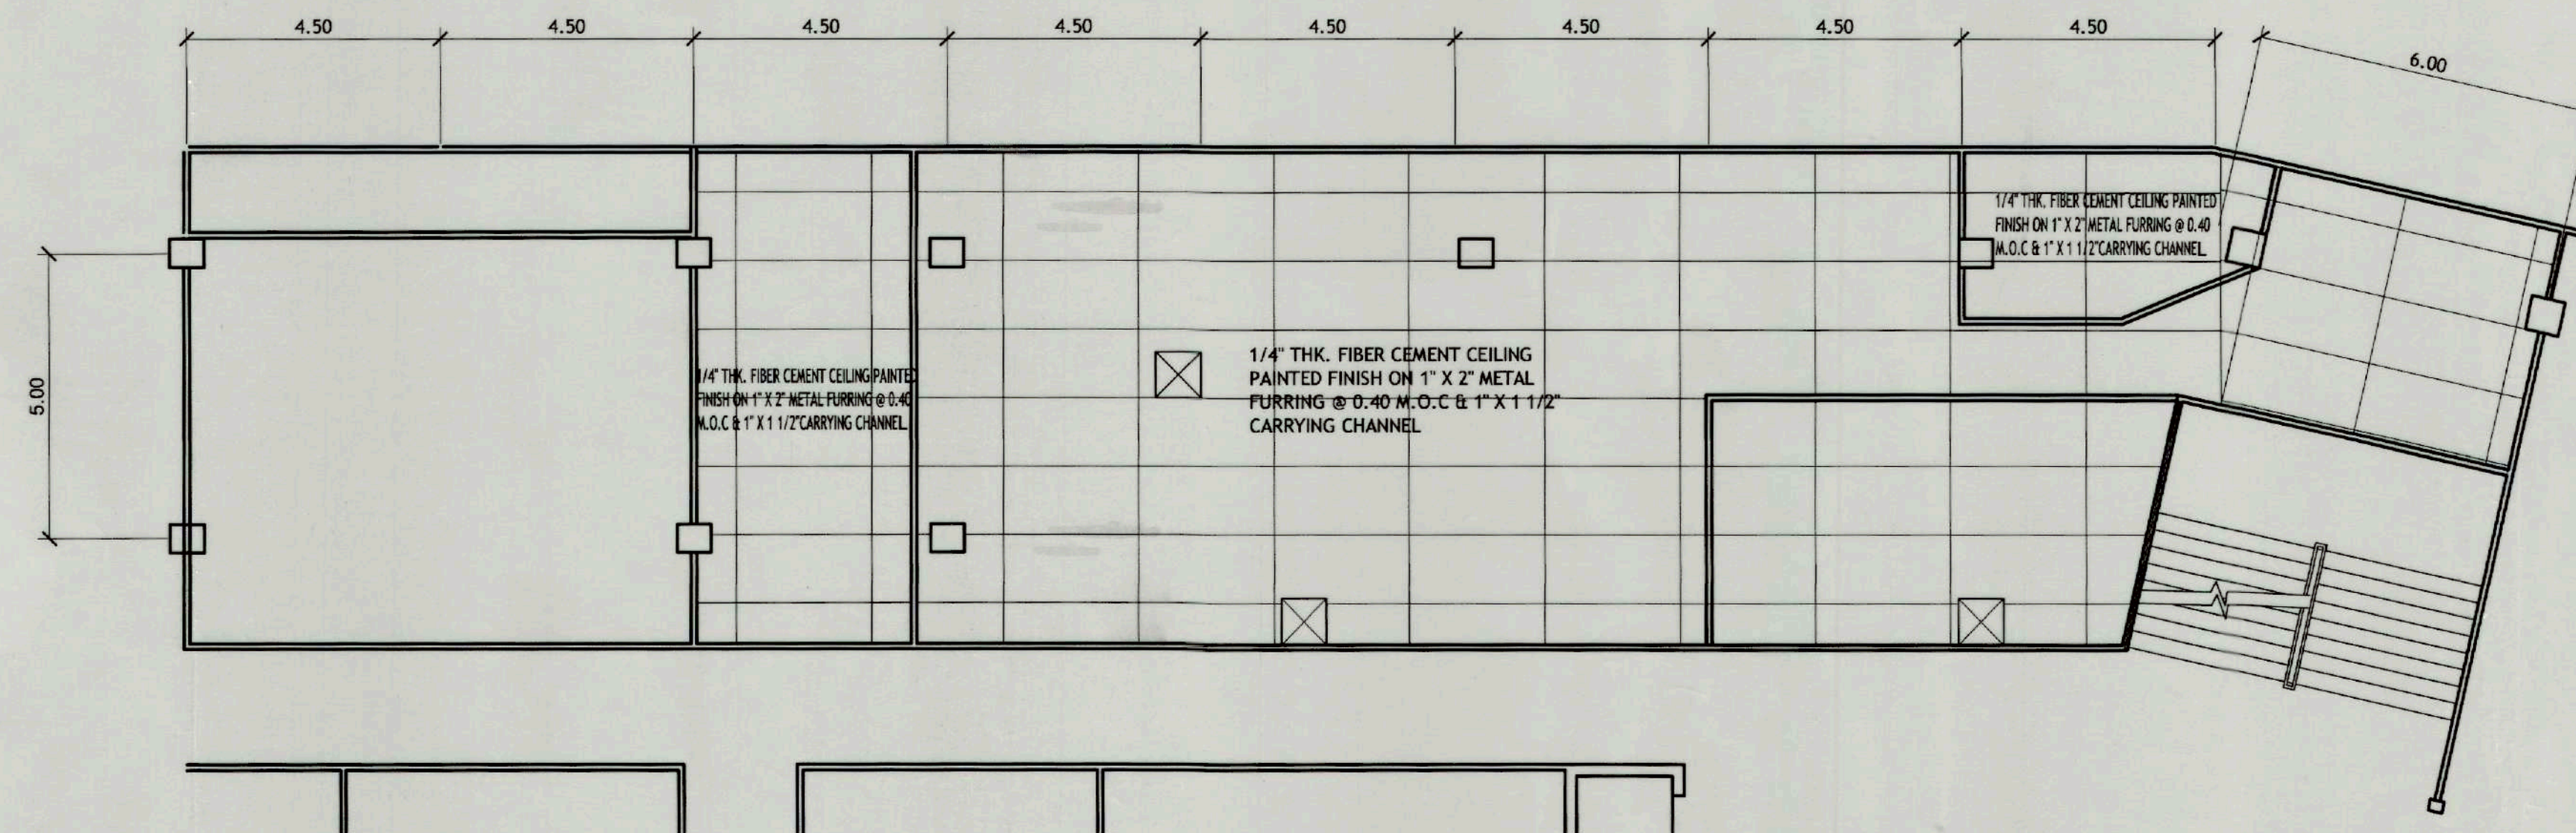

# REFLECTED CEILING PLAN (KITCHEN)

SCALE

1 : 100 MTS

## NOTE:

1. ELEVATION OF CEILING TO FINISH FLOOR LINE IS 2.70 METERS.
2. PROVIDE NECESSARY ACCESSORIES HANGER ROD & METAL SUPPORT METAL FURRING.

CONFORME :

*[Signature]*  
MARLON PRIETO  
Resident Manager  
Banaue Hotel & Youth Hostel



**TIEZA**  
TOURISM INFRASTRUCTURE  
AND ENTERPRISE ZONE AUTHORITY  
142 AMORSOLO ST. LEGASPI VILLAGE  
MAKATI CITY

PROJECT TITLE/LOCATION  
EMERGENCY WORKS FOR COMPLIANCE  
WITH FIRE DEPARTMENT REQUIREMENT  
BANAUE, IFUGAO

PROJECT EVALUATION AND PLANNING DEPARTMENT  
PREPARED BY: O.B. SAN JUAN  
CHECKED BY: RADY E. ADAME  
REVIEWED BY: AMELITA S. CAGANDA  
DRAWN BY: O.B. SAN JUAN  
DATE: OFFICER IN CHARGE  
PROJECT PLANNING & DESIGN DIVISION

RECOMMENDING APPROVAL:  
*[Signature]*  
NESTOR M. DOMALANTA  
ASSISTANT CHIEF OPERATING OFFICER  
Architectural & Engineering Services Sector

APPROVED BY:  
*[Signature]*  
POCHOLO J. D. PARAGAS  
CHIEF OPERATING OFFICER


SHEET CONTENTS:  
AS SHOWN  
REVISIONS:

R.A. 545  
THIS DRAWING IS  
THE PROPERTY OF  
TOURISM ENTERPRISE  
ZONE AUTHORITY AND  
CANNOT BE REPRO-  
DUCED WITHOUT  
THEIR CONSENT.

SHEET NO.  
A 8  
12 23

CAR-17-04




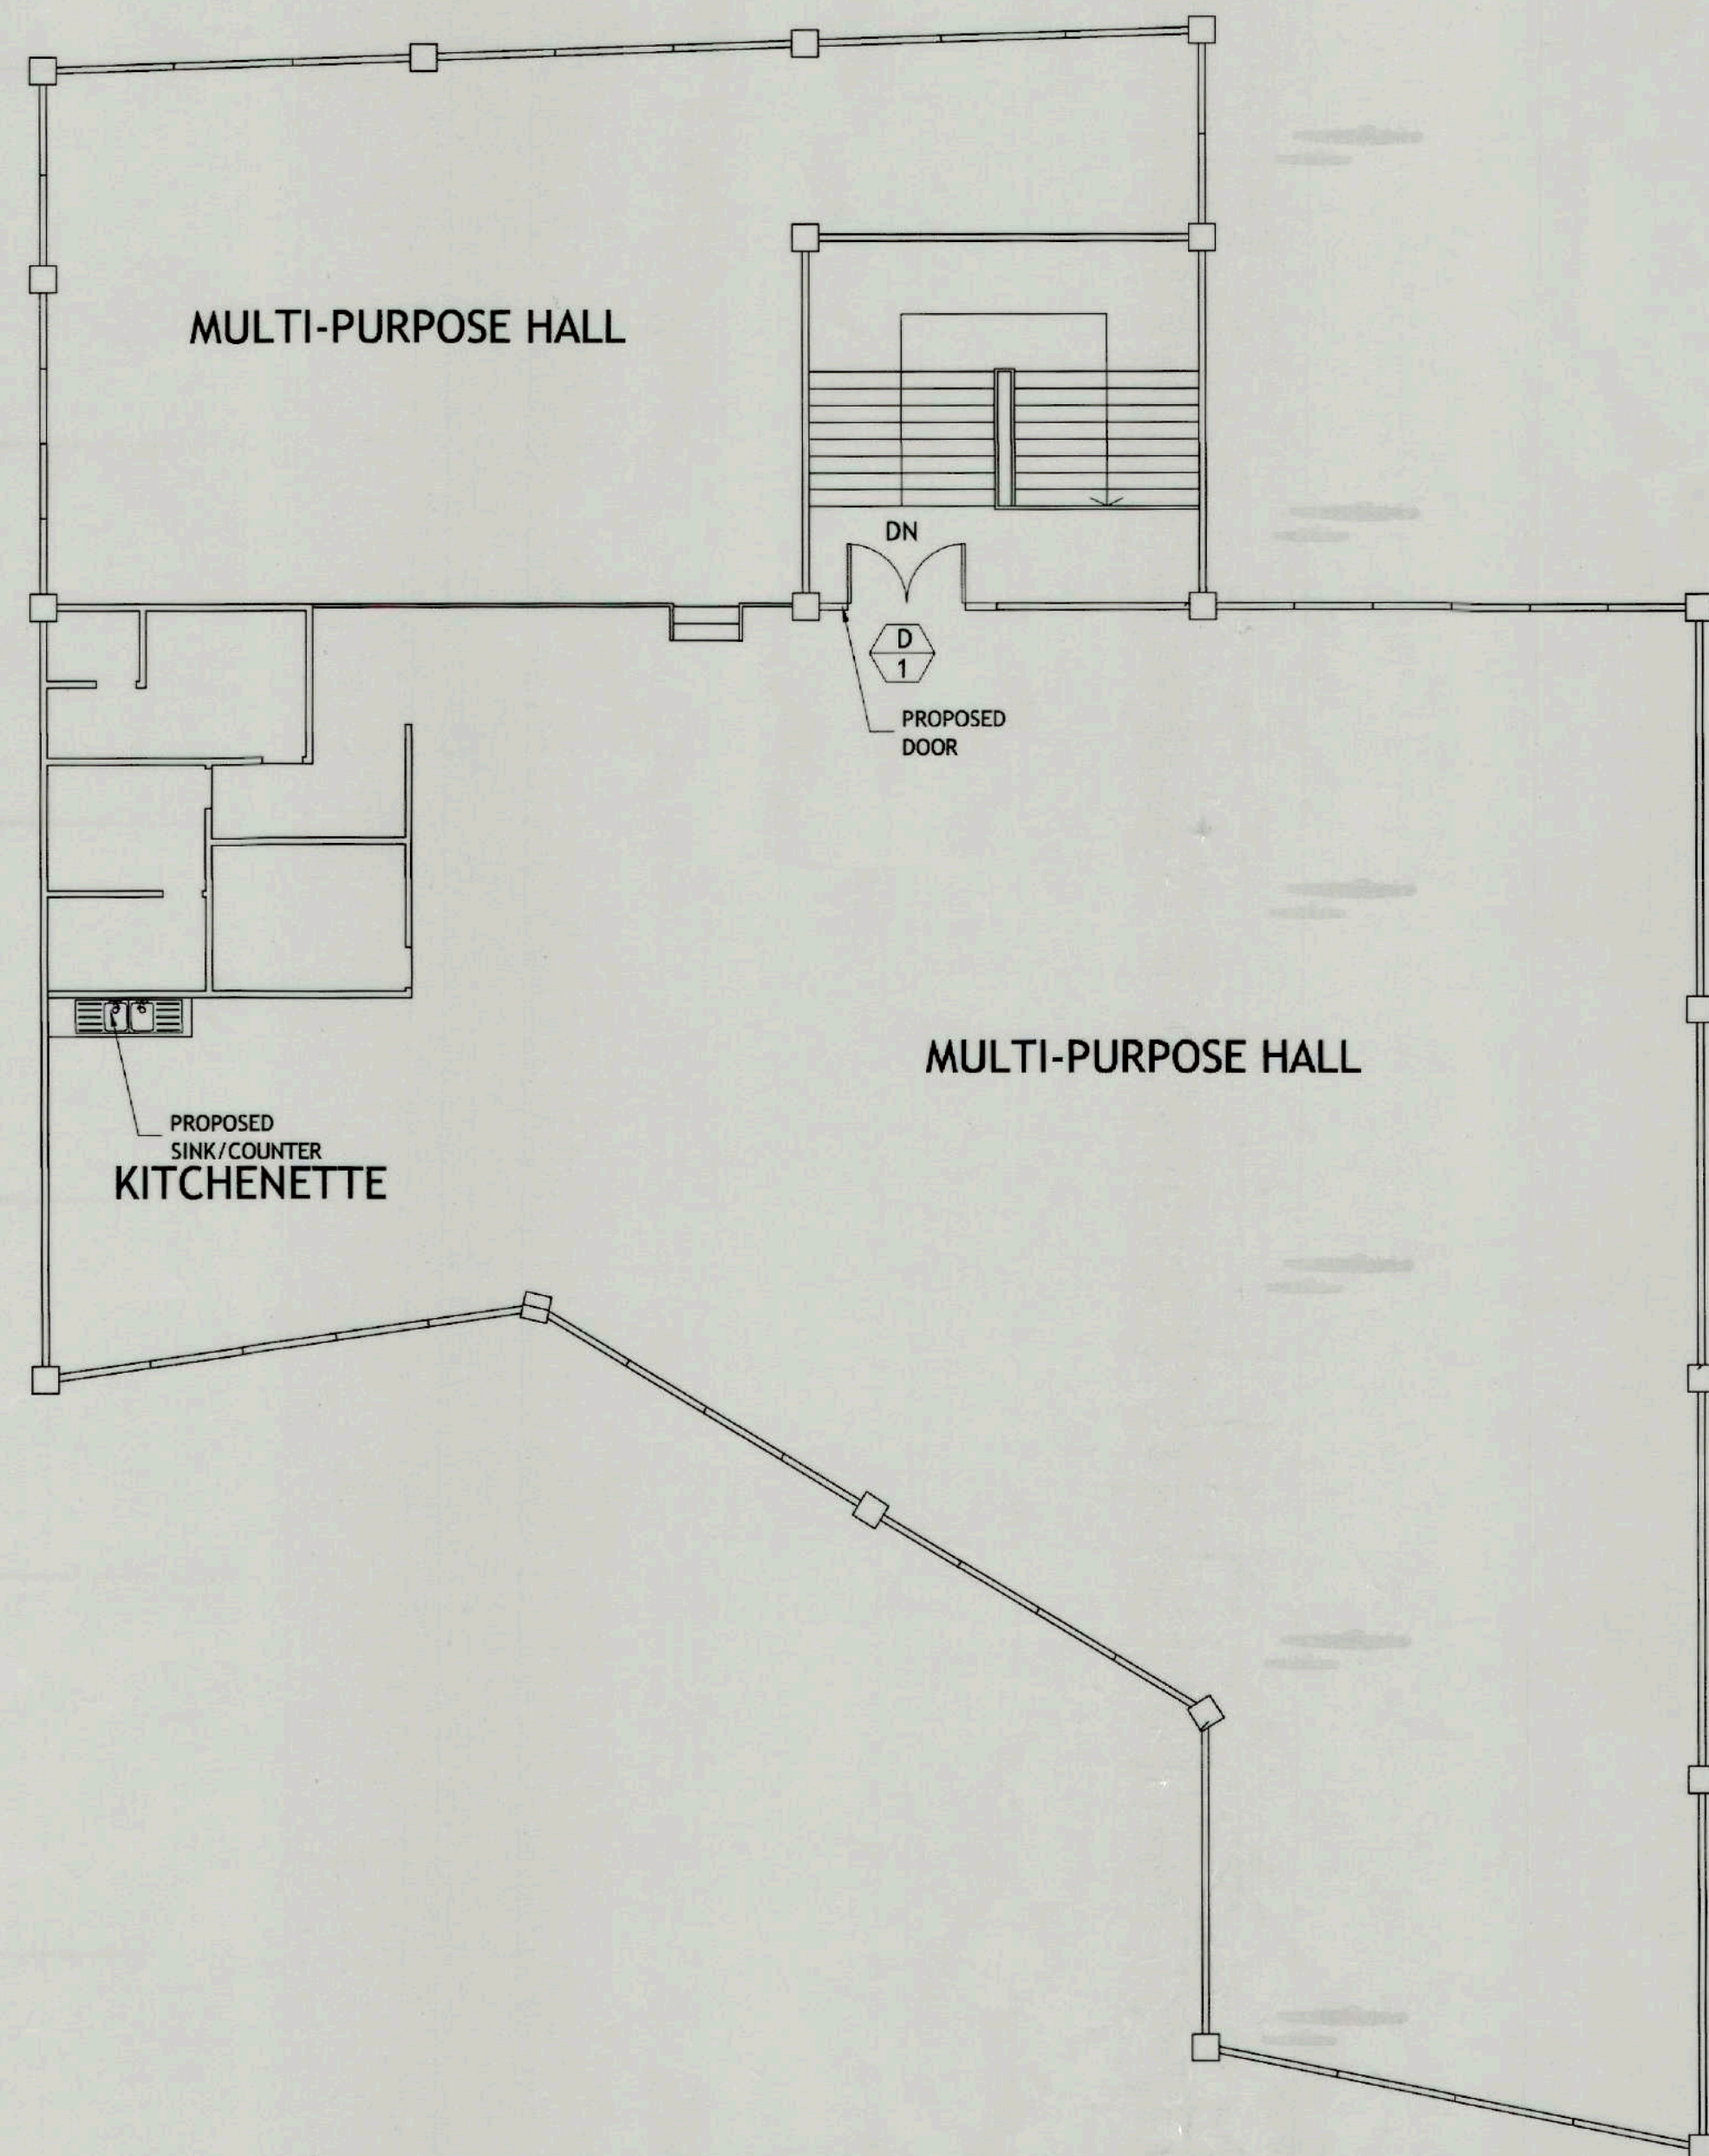

**ROOF DECK FLOOR PLAN**

SCALE


1 : 100 MTS.

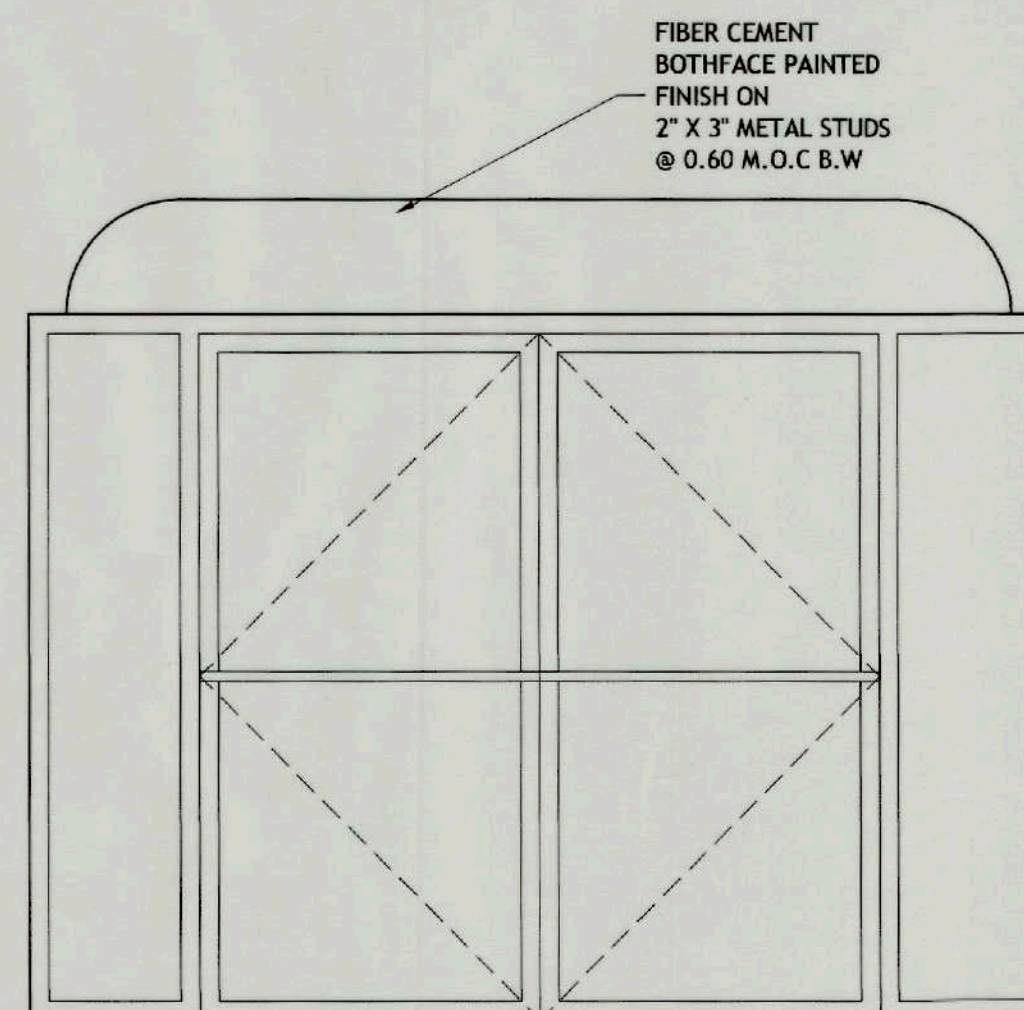

**DETAIL OF DOOR**

SCALE


1 : 20 MTS.

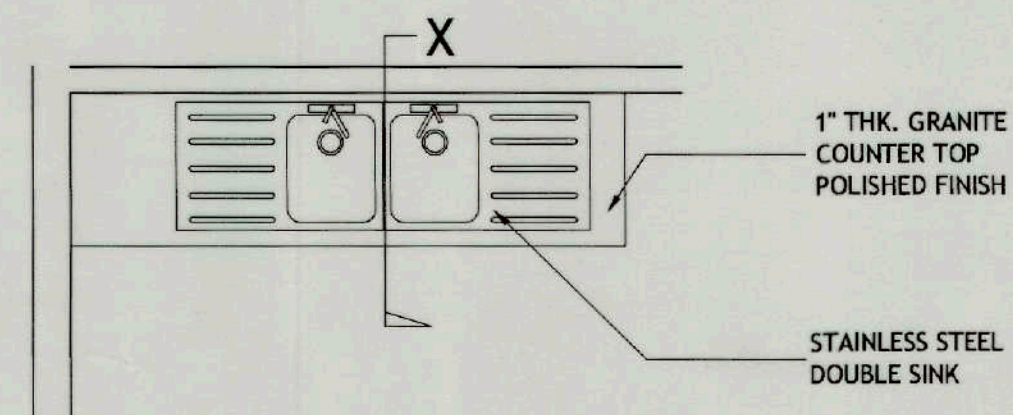

**KITCHEN SINK COUNTER PLAN**

SCALE


1 : 30 MTS.

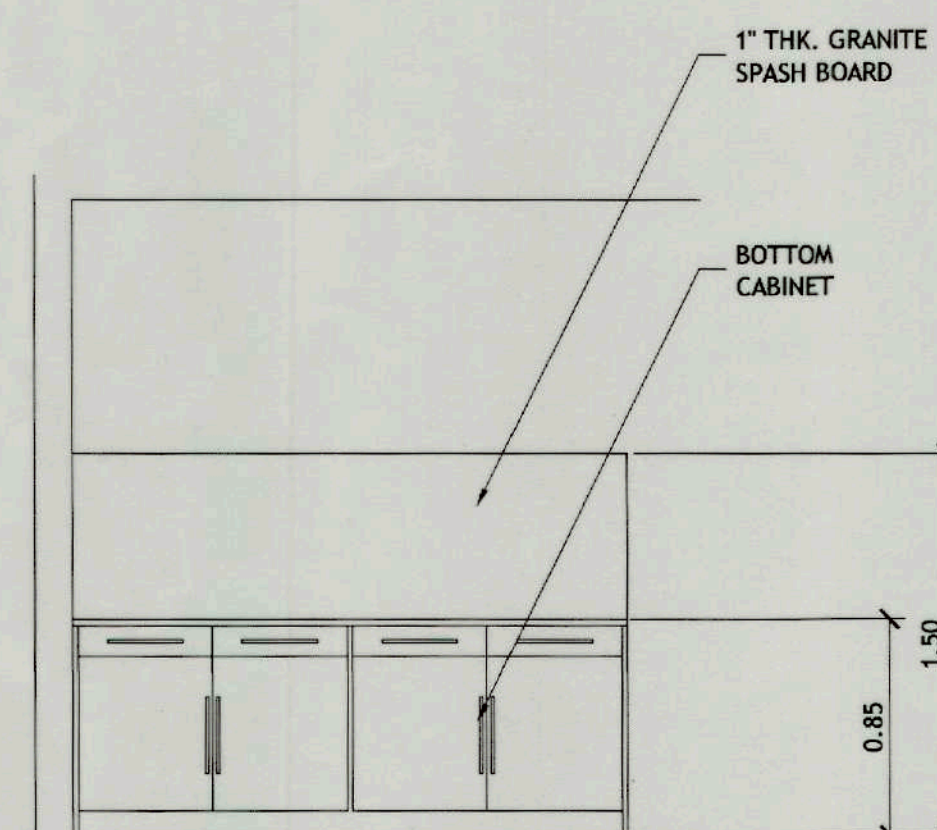

**FRONT ELEVATION**

SCALE

1 : 30 MTS.

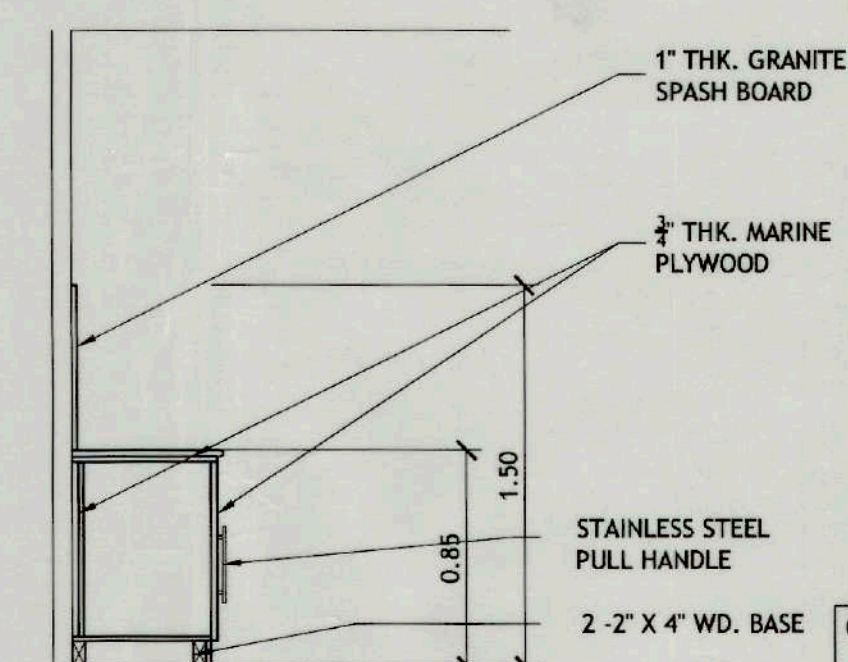

**SECTION - X**

SCALE

1 : 30 MTS.

CONFORME :

*Marlon Prieto*  
MARLON PRIETO  
Resident Manager  
Banaue Hotel & Youth Hostel



**TIEZA**  
TOURISM INFRASTRUCTURE  
AND ENTERPRISE ZONE AUTHORITY  
142 AMORSOLO ST. LEGASPI VILLAGE  
MAKATI CITY

PROJECT TITLE/LOCATION  
**EMERGENCY WORKS FOR COMPLIANCE  
WITH FIRE DEPARTMENT REQUIREMENT**  
BANAUE, IFUGAO

PROJECT EVALUATION AND PLANNING DEPARTMENT  
PREPARED BY: *Odono B. San Juan*  
ODONOLO B. SAN JUAN  
CHECKED BY: *Rady E. Adame*  
RADY E. ADAME  
REVIEWED BY: *Amelita S. Caganda*  
AMELITA S. CAGANDA  
DRAWN BY: O.B. SAN JUAN  
DATE: \_\_\_\_\_  
OFFICER IN CHARGE  
PROJECT PLANNING & DESIGN DIVISION

RECOMMENDING APPROVAL:  
*Nestor M. Domalanta*  
NESTOR M. DOMALANTA  
ASSISTANT CHIEF OPERATING OFFICER  
Architectural & Engineering Services Sector

APPROVED BY:  
*Pocholo J. D. Paragas*  
POCHOLO J. D. PARAGAS  
CHIEF OPERATING OFFICER



SHEET CONTENTS:  
AS SHOWN  
REVISIONS:

R.A. 545  
THIS DRAWING IS  
THE PROPERTY OF  
TOURISM ENTERPRISE  
ZONE AUTHORITY AND  
CANNOT BE REPRODUCED  
WITHOUT  
THEIR CONSENT.

SHEET NO.  
A 9  
12 23

CAR-17-04



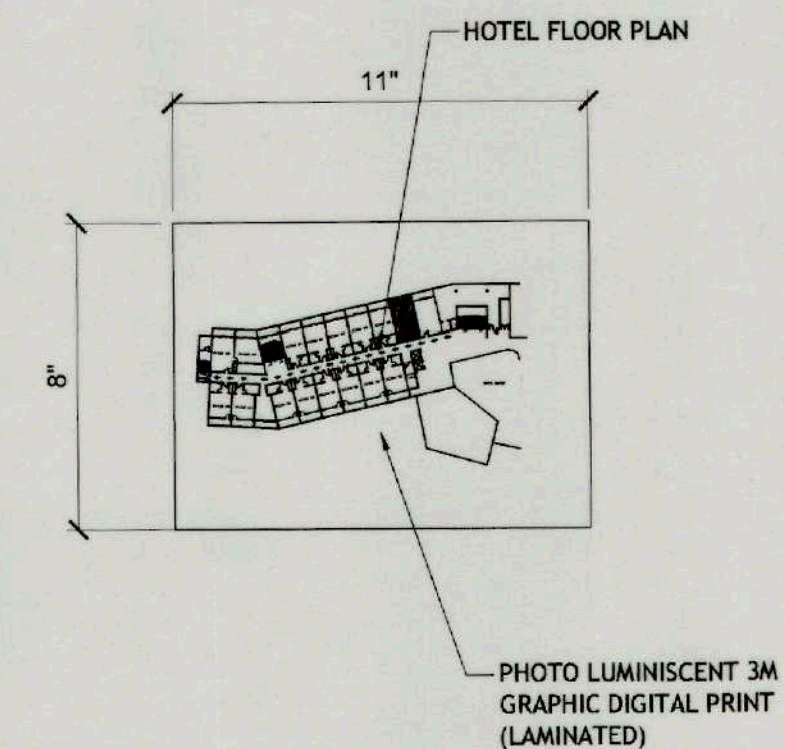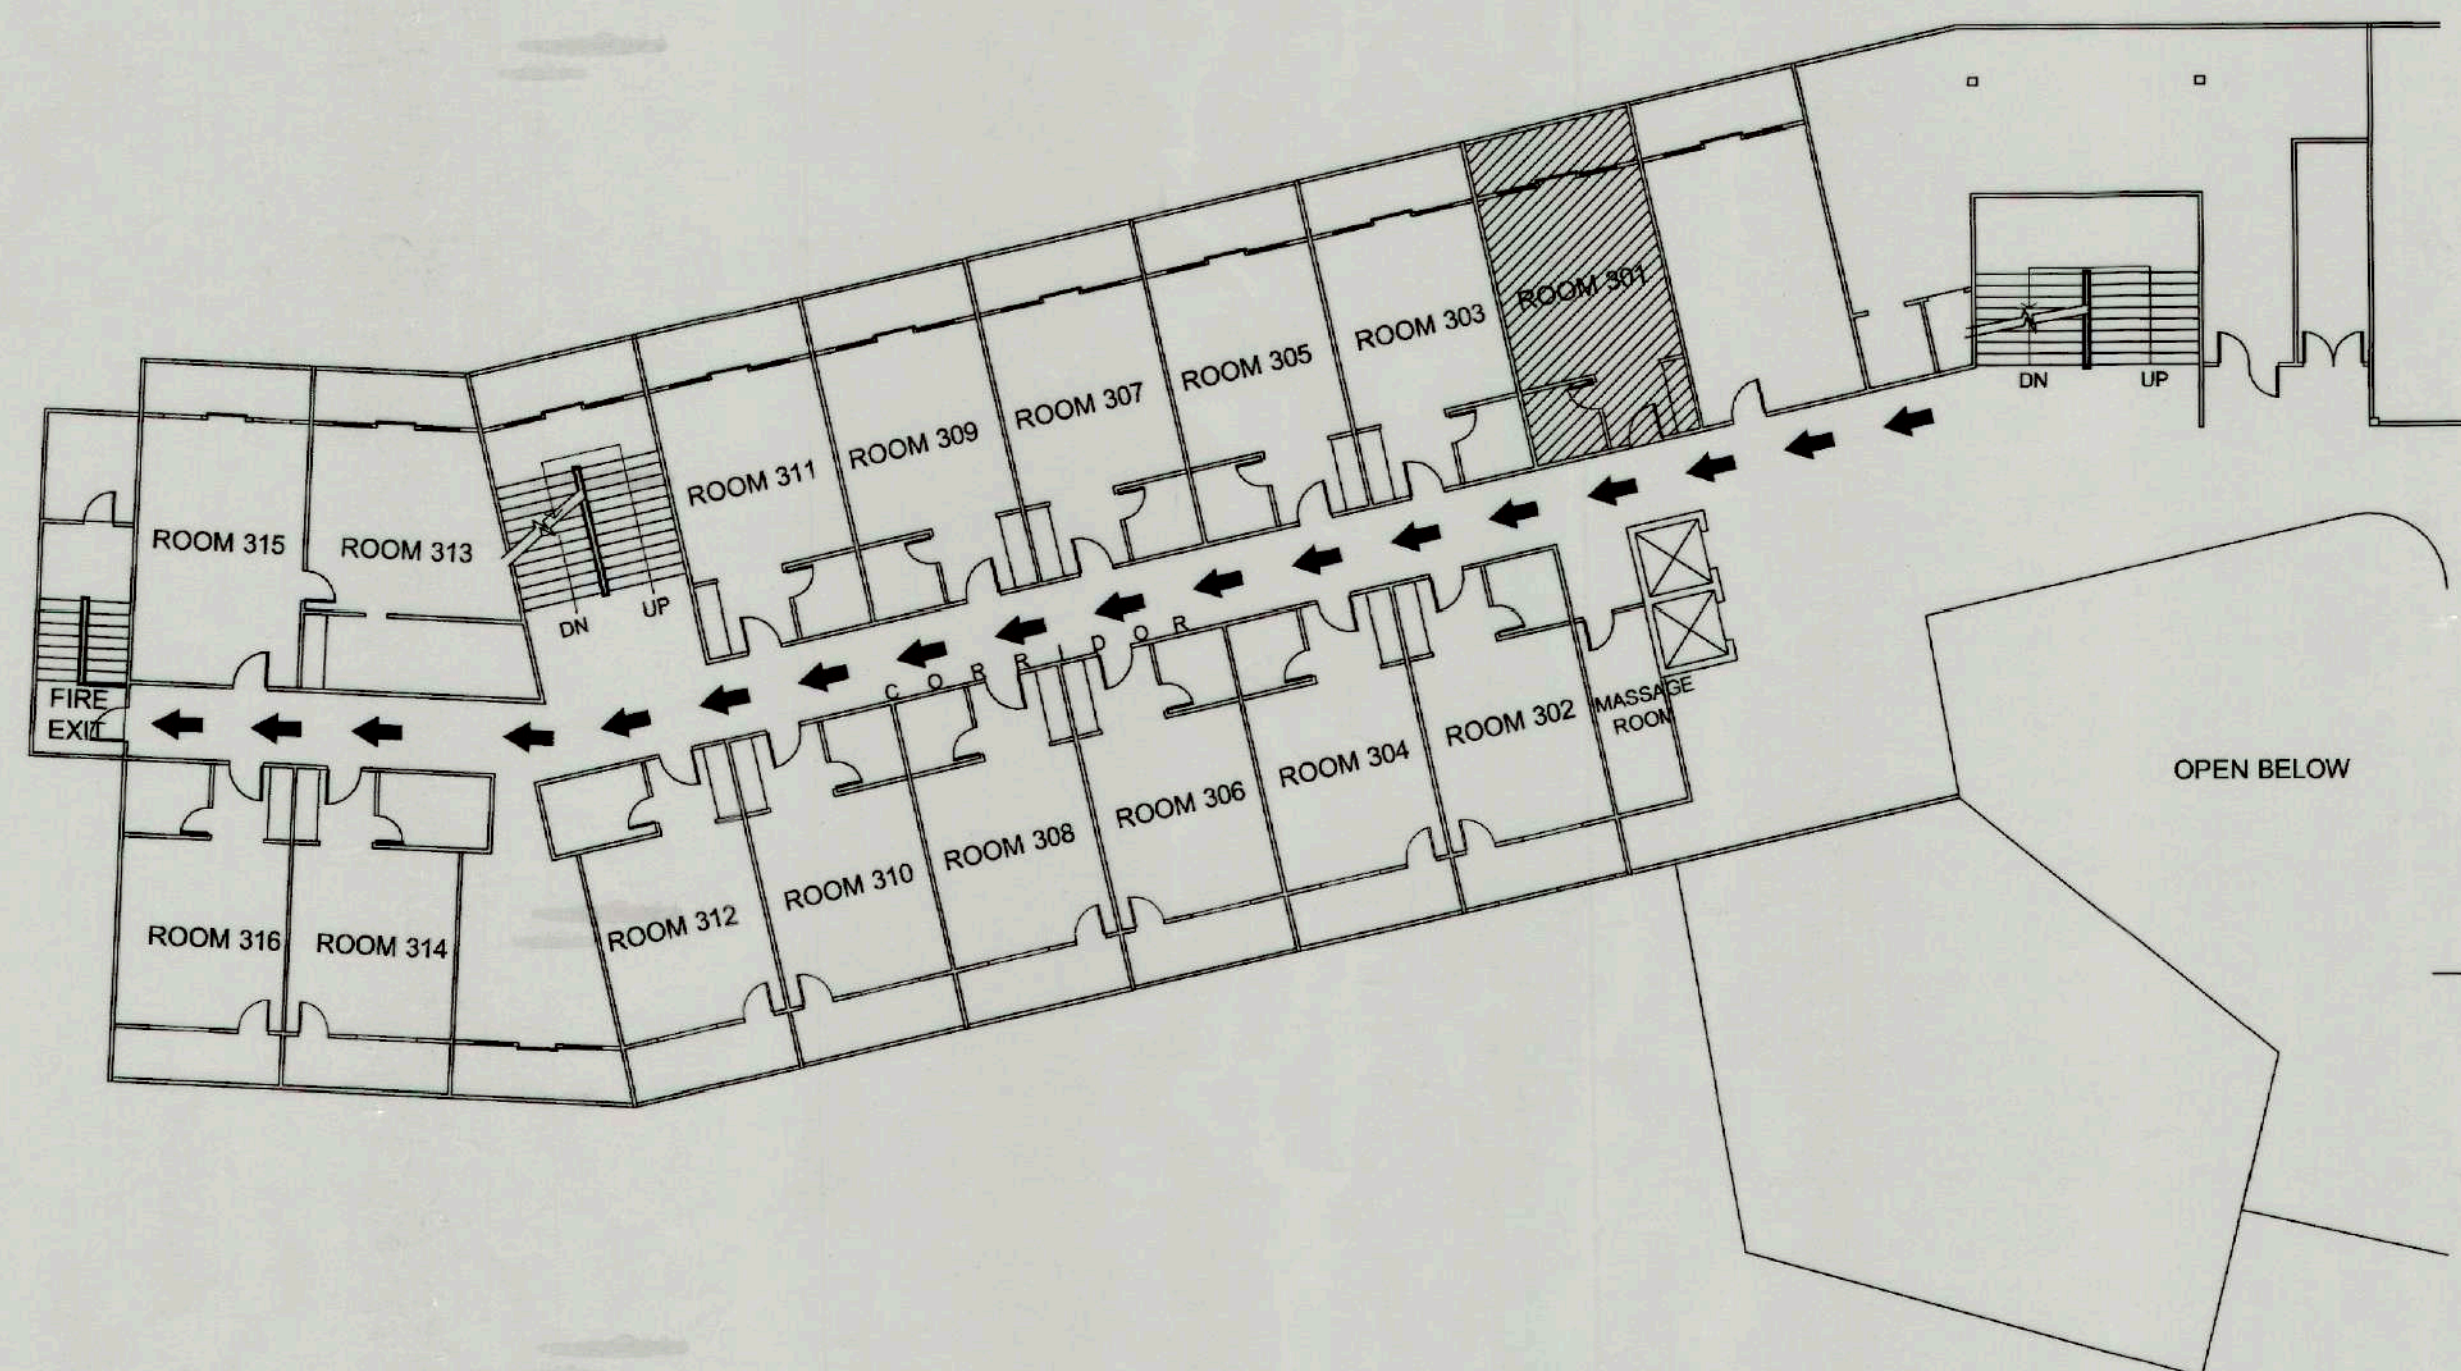

## DETAIL OF FIRE EXIT MAP

SCALE

 
1 : 1500 MTS

## NOTE:

1. PROVIDE EVERY ROOMS WITH FIRE EXIT LOCATION PLAN.

## SECOND FLOOR FIRE EXIT PLAN (NEW BLDG.)

CONFORME :

  
MARLON PRIETO  
Resident Manager  
Banaue Hotel & Youth Hostel

PROJECT TITLE/LOCATION


EMERGENCY WORKS FOR COMPLIANCE  
WITH FIRE DEPARTMENT REQUIREMENT

BANAUE,

IFUGAO


### PROJECT EVALUATION AND PLANNING DEPARTMENT

 PREPARED BY:

  
ODONILO B. SAN JUAN

DRAWN BY: O.B. SAN JUAN  
DATE:

 CHECKED BY:

  
RADY E. ADAME


OFFICER IN CHARGE  
PROJECT PLANNING & DESIGN DIVISION

REVIEWED BY:

  
AMELITA S. CAGANDA


OFFICER IN CHARGE  
PROJECT EVALUATION & PLANNING DEPARTMENT

RECOMMENDING APPROVAL:

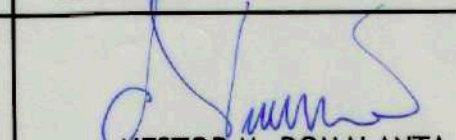  
NESTOR M. DOMALANTA

ASSISTANT CHIEF OPERATING OFFICER  
Architecture & Engineering Services Sector

APPROVED BY:

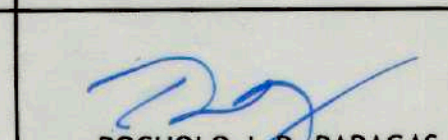  
POCHOLO J. D. PARAGAS

CHIEF OPERATING OFFICER

SHEET CONTENTS:

AS SHOWN

REVISIONS:

R.A. 545

THIS DRAWING IS  
THE PROPERTY OF  
TOURISM ENTERPRISE  
ZONE AUTHORITY AND  
CANNOT BE REPRODUCED  
WITHOUT  
THEIR CONSENT.

SHEET NO.


A 10  
12 23




**TIEZA**  
TOURISM INFRASTRUCTURE  
AND ENTERPRISE ZONE AUTHORITY  
142 AMORSOLO ST. LEGASPI VILLAGE  
MAKATI CITY

CAR-17-04



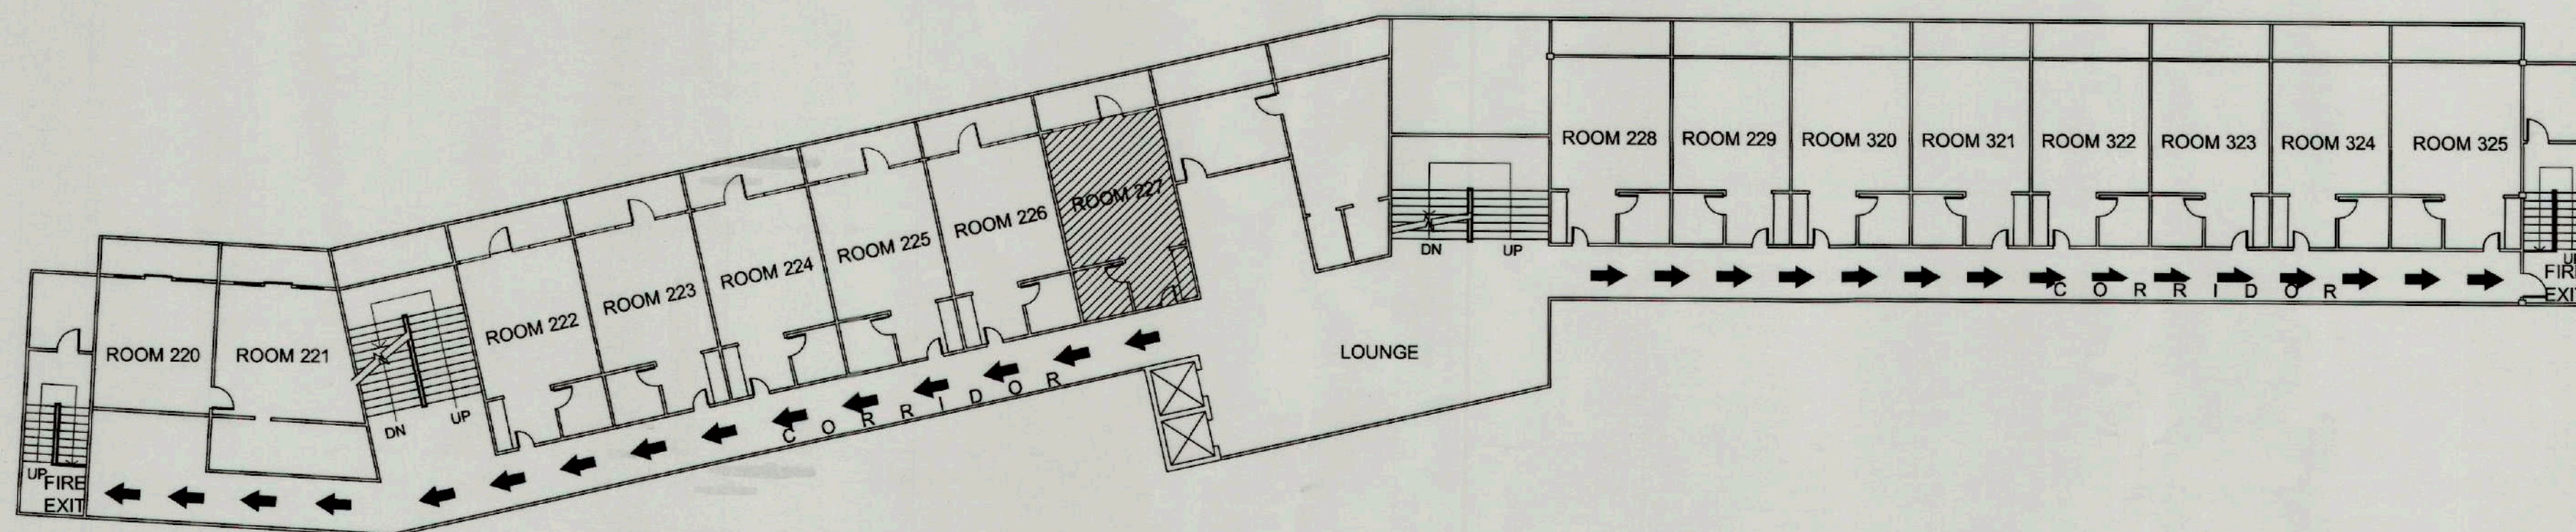

UPPER BASEMENT FIRE EXIT FLOOR PLAN (NEW BLDG.)

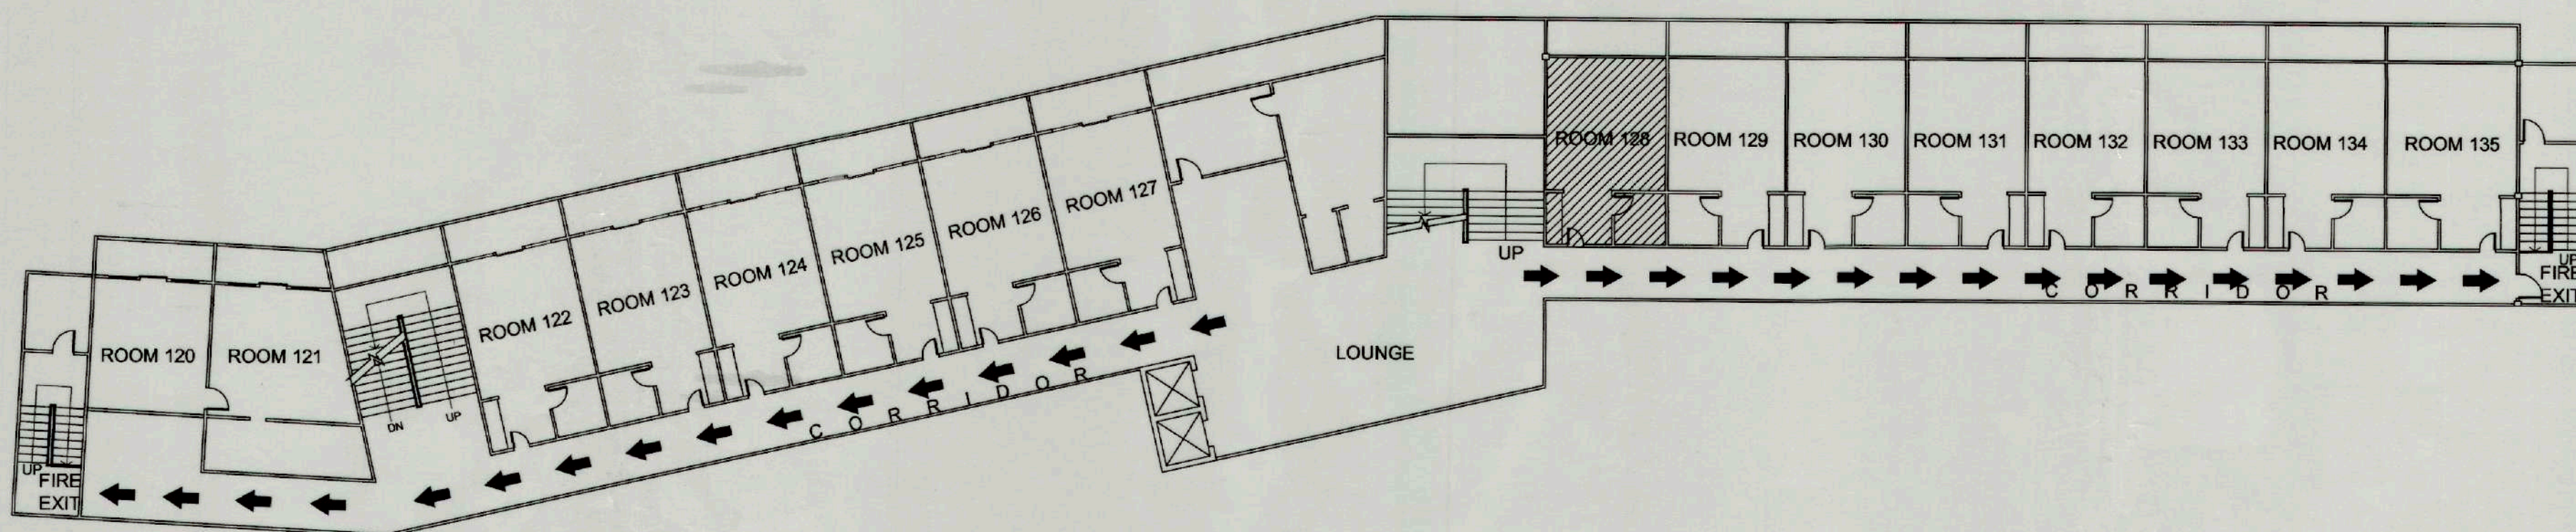


LOWER BASEMENT FIRE EXIT FLOOR PLAN (NEW BLDG.)

|                                                                             |                                                                                                                   |                                                                                                                                                                                                                                                                                                                                                                                                                                                                                                        |
|-----------------------------------------------------------------------------|-------------------------------------------------------------------------------------------------------------------|--------------------------------------------------------------------------------------------------------------------------------------------------------------------------------------------------------------------------------------------------------------------------------------------------------------------------------------------------------------------------------------------------------------------------------------------------------------------------------------------------------|
| CONFORME :                                                                  |                                                                                                                   |                                                                                                                                                                                                                                                                                                                                                                                                                                                                                                        |
| <br><b>MARLON PRIETO</b><br>Resident Manager<br>Banaue Hotel & Youth Hostel |                                                                                                                   |                                                                                                                                                                                                                                                                                                                                                                                                                                                                                                        |
| SHEET CONTENTS:                                                             | R.A. 545                                                                                                          | SHEET NO.                                                                                                                                                                                                                                                                                                                                                                                                                                                                                              |
| AS SHOWN                                                                    | THIS DRAWING IS THE PROPERTY OF TOURISM ENTERPRISE ZONE AUTHORITY AND CANNOT BE REPRODUCED WITHOUT THEIR CONSENT. | <div style="border: 1px solid black; border-radius: 50%; width: 40px; height: 40px; display: flex; align-items: center; justify-content: center;"> <div style="writing-mode: vertical-rl; transform: rotate(180deg);">A</div> <div>11</div> </div> <div style="border: 1px solid black; border-radius: 50%; width: 40px; height: 40px; display: flex; align-items: center; justify-content: center;"> <div style="writing-mode: vertical-rl; transform: rotate(180deg);">12</div> <div>23</div> </div> |
| REVISIONS:                                                                  |                                                                                                                   |                                                                                                                                                                                                                                                                                                                                                                                                                                                                                                        |


|                                                                                                                                |                                                                                      |                                            |                                    |                                          |                                                                                                                    |                                                             |  |  |
|--------------------------------------------------------------------------------------------------------------------------------|--------------------------------------------------------------------------------------|--------------------------------------------|------------------------------------|------------------------------------------|--------------------------------------------------------------------------------------------------------------------|-------------------------------------------------------------|--|--|
| <br><b>TIEZA</b><br>TOURISM INFRASTRUCTURE<br>AND ENTERPRISE ZONE AUTHORITY<br>142 AMORSOLO ST. LEGASPI VILLAGE<br>MAKATI CITY | PROJECT TITLE/LOCATION                                                               | PROJECT EVALUATION AND PLANNING DEPARTMENT |                                    |                                          | RECOMMENDING APPROVAL:                                                                                             | APPROVED BY:                                                |  |  |
|                                                                                                                                | EMERGENCY WORKS FOR COMPLIANCE<br>WITH FIRE DEPARTMENT REQUIREMENT<br>BANAUE, IFUGAO | PREPARED BY:                               | CHECKED BY:                        | REVIEWED BY:                             | <br><b>NESTOR M. DOMALANTA</b><br>ASSISTANT CHIEF OPERATING OFFICER<br>Architectural & Engineering Services Sector | <br><b>POCHOLO J. D. PARAGAS</b><br>CHIEF OPERATING OFFICER |  |  |
|                                                                                                                                |                                                                                      | DRAWN BY:                                  | OFFICER IN CHARGE                  | OFFICER IN CHARGE                        |                                                                                                                    |                                                             |  |  |
|                                                                                                                                |                                                                                      | DATE:                                      | PROJECT PLANNING & DESIGN DIVISION | PROJECT EVALUATION & PLANNING DEPARTMENT |                                                                                                                    |                                                             |  |  |

CAR-17-04



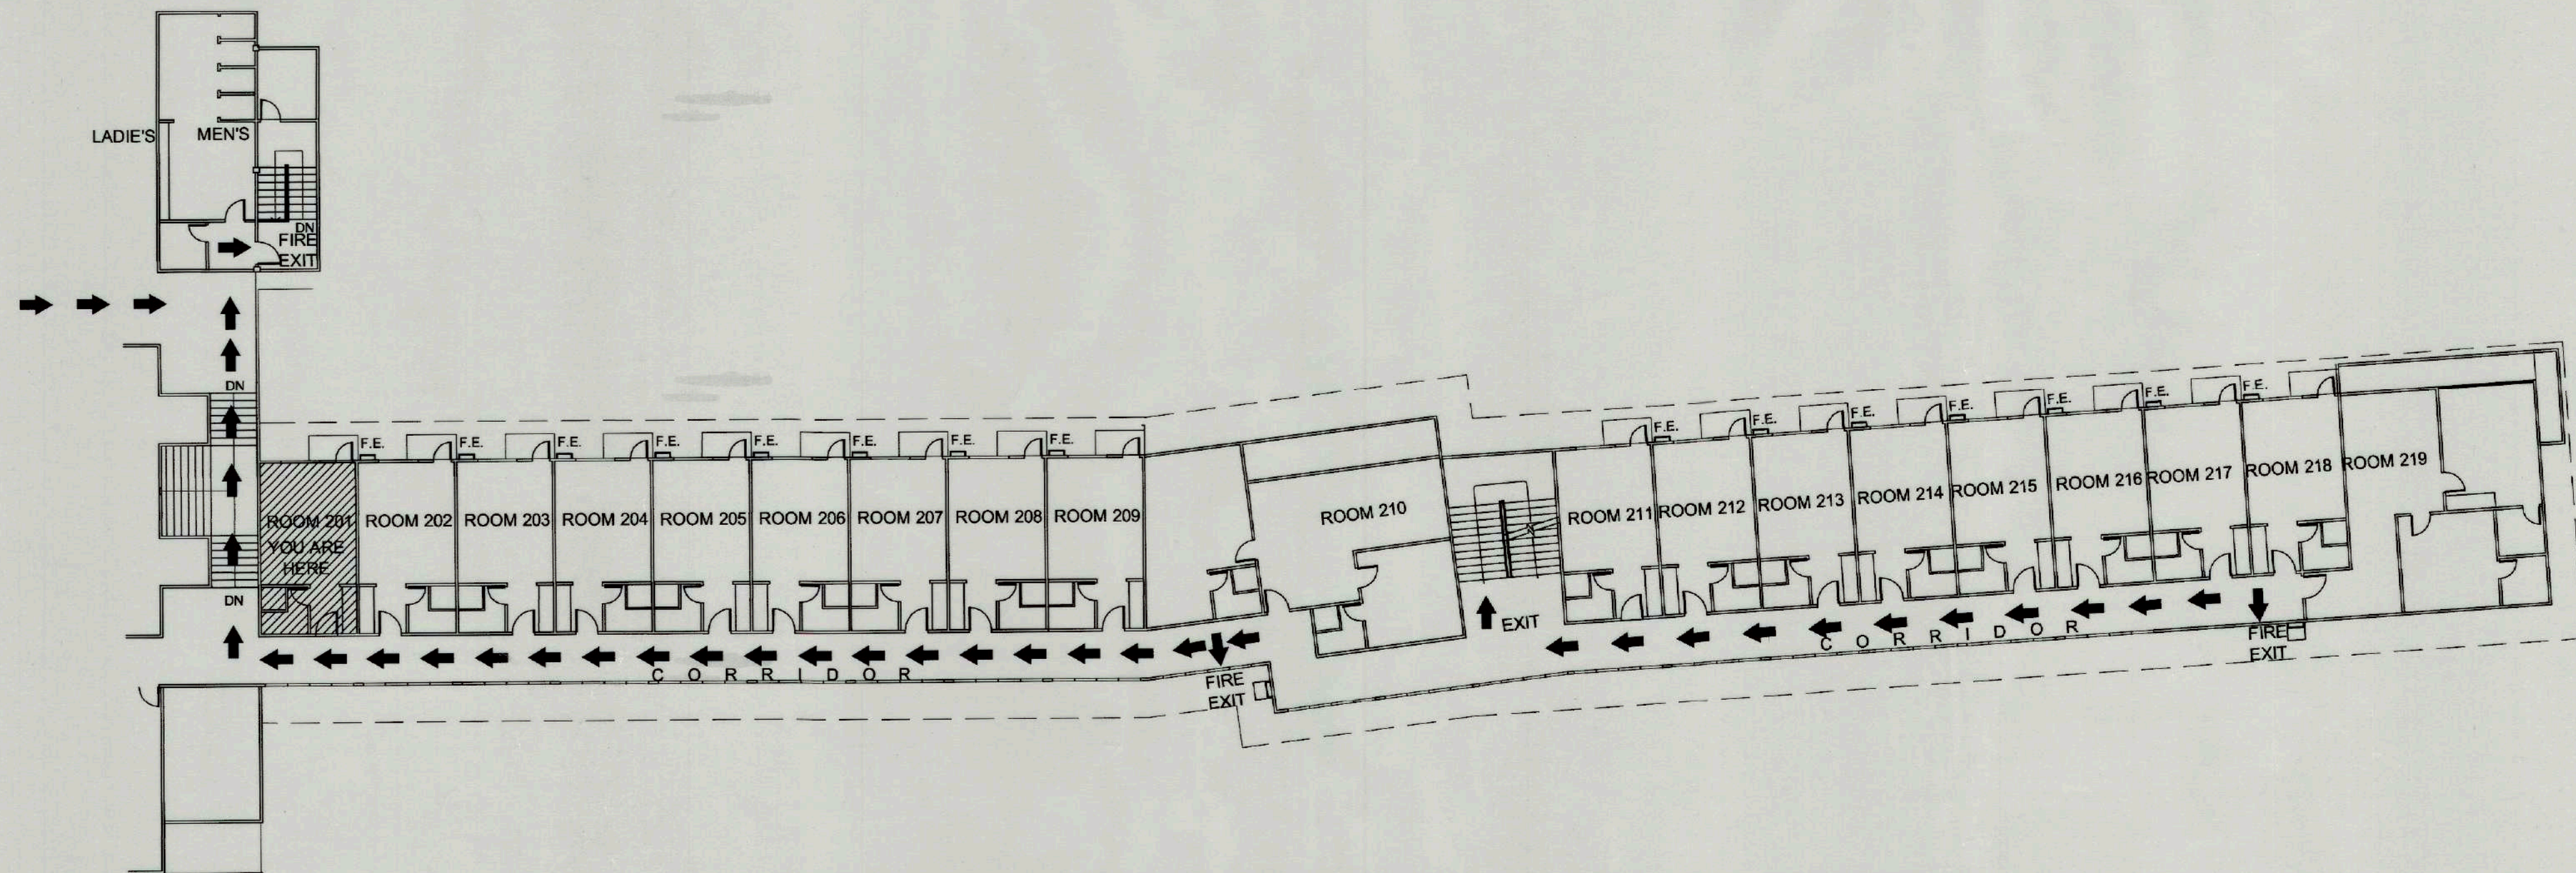

SECOND FLOOR FIRE EXIT PLAN (OLD BLDG.)

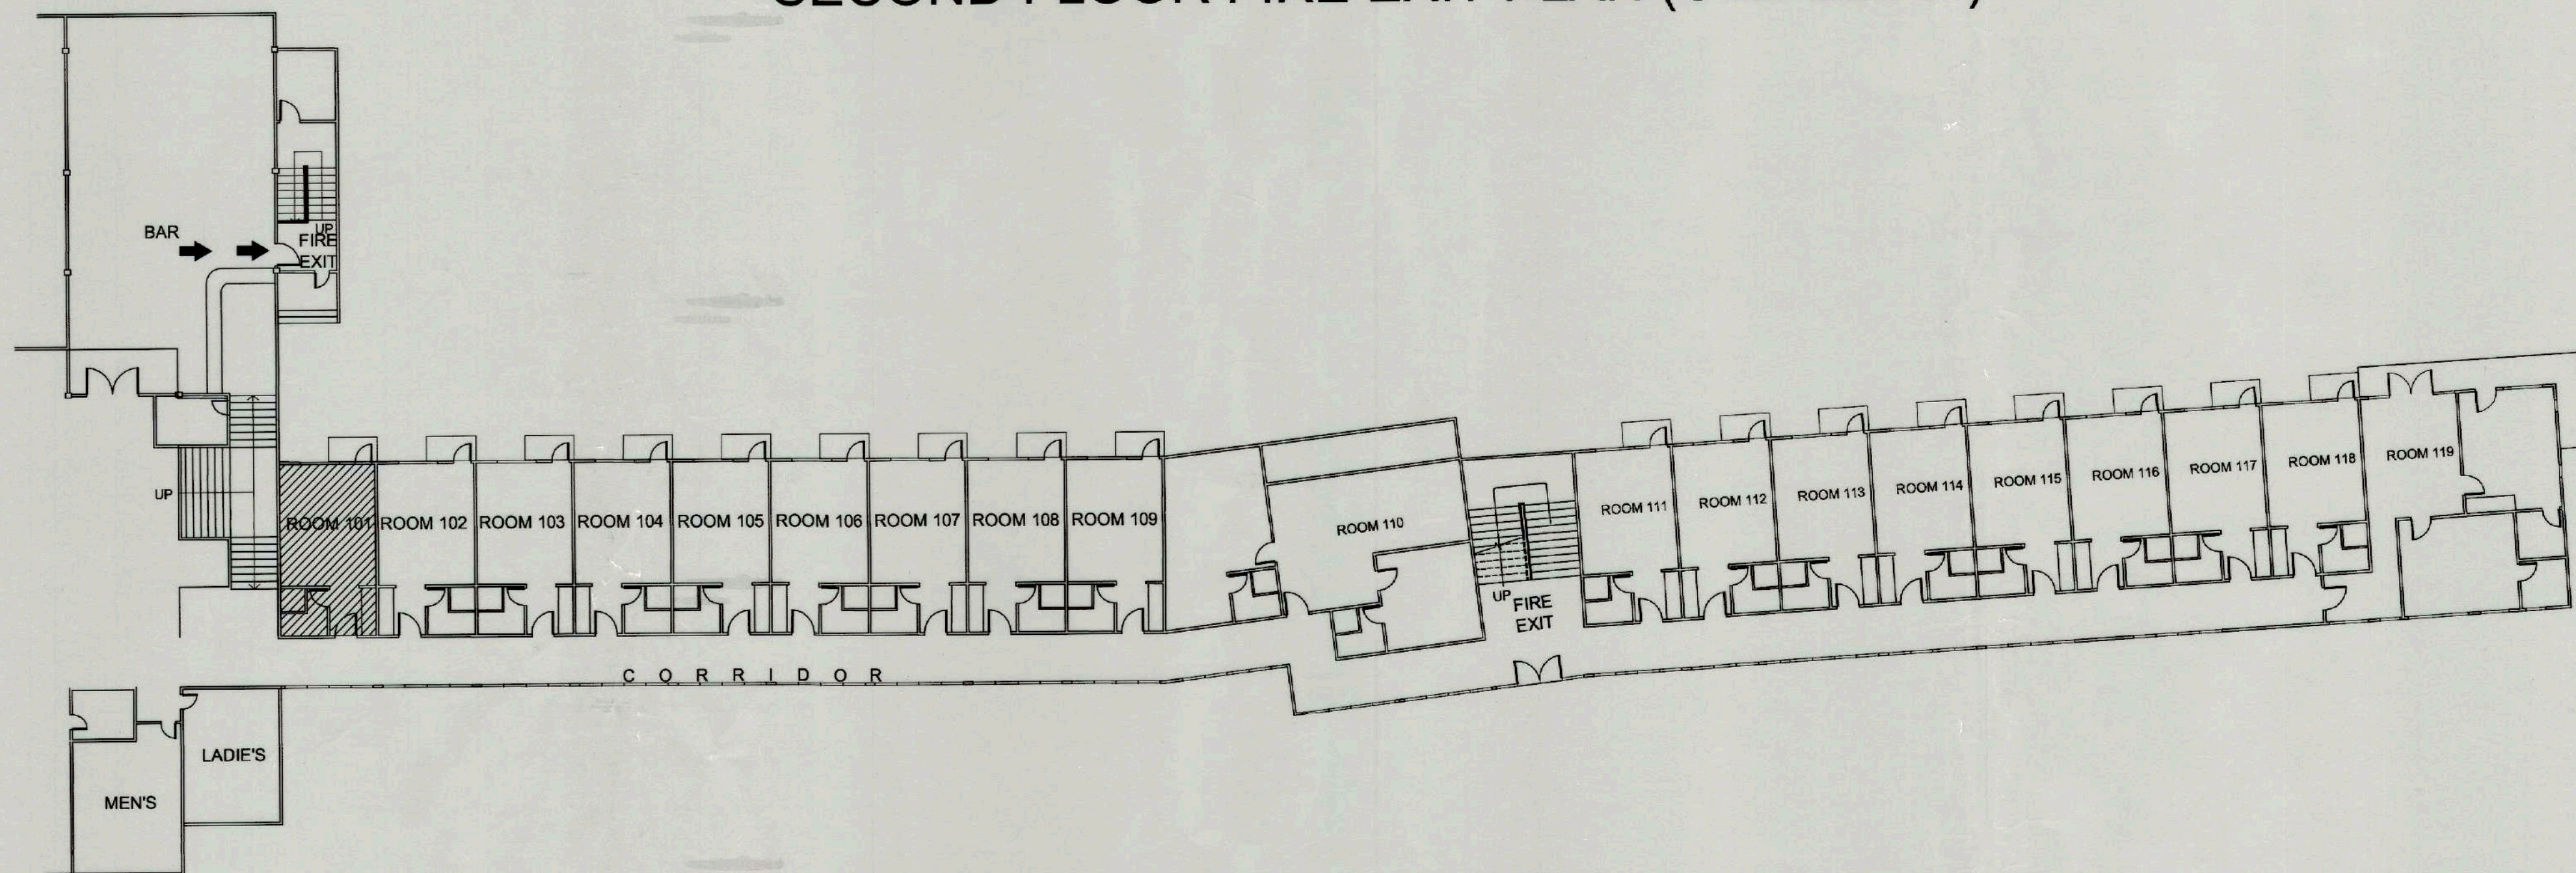

GROUND FLOOR FIRE EXIT PLAN (OLD BLDG.)










|                                                                              |                                                                                                                   |
|------------------------------------------------------------------------------|-------------------------------------------------------------------------------------------------------------------|
| CONFORME :                                                                   |                                                                                                                   |
| <br><b>MARLON PRIETO</b><br>Resident Manager<br>Banahaw Hotel & Youth Hostel |                                                                                                                   |
| SHEET CONTENTS:                                                              | R.A. 545                                                                                                          |
| AS SHOWN                                                                     | THIS DRAWING IS THE PROPERTY OF TOURISM ENTERPRISE ZONE AUTHORITY AND CANNOT BE REPRODUCED WITHOUT THEIR CONSENT. |
| REVISIONS:                                                                   |                                                                                                                   |


|                                                                                                                                |                                                                    |                                            |                                                         |                                                               |                                                                                                                    |                                                             |               |
|--------------------------------------------------------------------------------------------------------------------------------|--------------------------------------------------------------------|--------------------------------------------|---------------------------------------------------------|---------------------------------------------------------------|--------------------------------------------------------------------------------------------------------------------|-------------------------------------------------------------|---------------|
| <br><b>TIEZA</b><br>TOURISM INFRASTRUCTURE<br>AND ENTERPRISE ZONE AUTHORITY<br>142 AMORSOLO ST. LEGASPI VILLAGE<br>MAKATI CITY | PROJECT TITLE/LOCATION                                             | PROJECT EVALUATION AND PLANNING DEPARTMENT |                                                         |                                                               | RECOMMENDING APPROVAL:                                                                                             | APPROVED BY:                                                | SHEET NO.     |
|                                                                                                                                | EMERGENCY WORKS FOR COMPLIANCE<br>WITH FIRE DEPARTMENT REQUIREMENT | PREPARED BY:                               | CHECKED BY:                                             | REVIEWED BY:                                                  | <br><b>NESTOR M. DOMALANTA</b><br>ASSISTANT CHIEF OPERATING OFFICER<br>Architectural & Engineering Services Sector | <br><b>POCHOLO J. D. PARAGAS</b><br>CHIEF OPERATING OFFICER | A 12<br>12 23 |
|                                                                                                                                |                                                                    | ODONILO B. SAN JUAN                        | RADY E. ADAME                                           | AMELITA S. CAGANDA                                            |                                                                                                                    |                                                             |               |
|                                                                                                                                |                                                                    | DRAWN BY: O.B. SAN JUAN                    | OFFICER IN CHARGE<br>PROJECT PLANNING & DESIGN DIVISION | OFFICER IN CHARGE<br>PROJECT EVALUATION & PLANNING DEPARTMENT |                                                                                                                    |                                                             |               |
|                                                                                                                                | BANAU, IFUGAO                                                      | DATE:                                      |                                                         |                                                               |                                                                                                                    |                                                             |               |

CAR-17-04




**LEGEND:**

         -  2 X 40W FLOURESCENT LAMP, INSIDE MIRRORIZED REFLECTOR/DIFFUSER HOUSING
-  1 X 40W FLOURESCENT LAMP, INSIDE MIRRORIZED REFLECTOR/DIFFUSER HOUSING
-  MDP EXISTING MAIN DISTRIBUTION PANEL BOARD
-  PBA EXISTING PANEL BOARD (SUB PANEL)
-  PBB EXISTING SUB-PANEL BOARD
-  PBC EXISTING SUB-PANEL BOARD
-  NPB NEW PANEL BOARD FOR KITCHEN
-  S1 ONE-GANG SWITCH, 10A, 250 VAC
-  Sab TWO-GANG SWITCH, 10A, 250 VAC
-  Duplex CONVENIENCE OUTLET, 16A, 250VAC
-  WP Duplex CONVENIENCE OUTLET, 16A, 250VAC

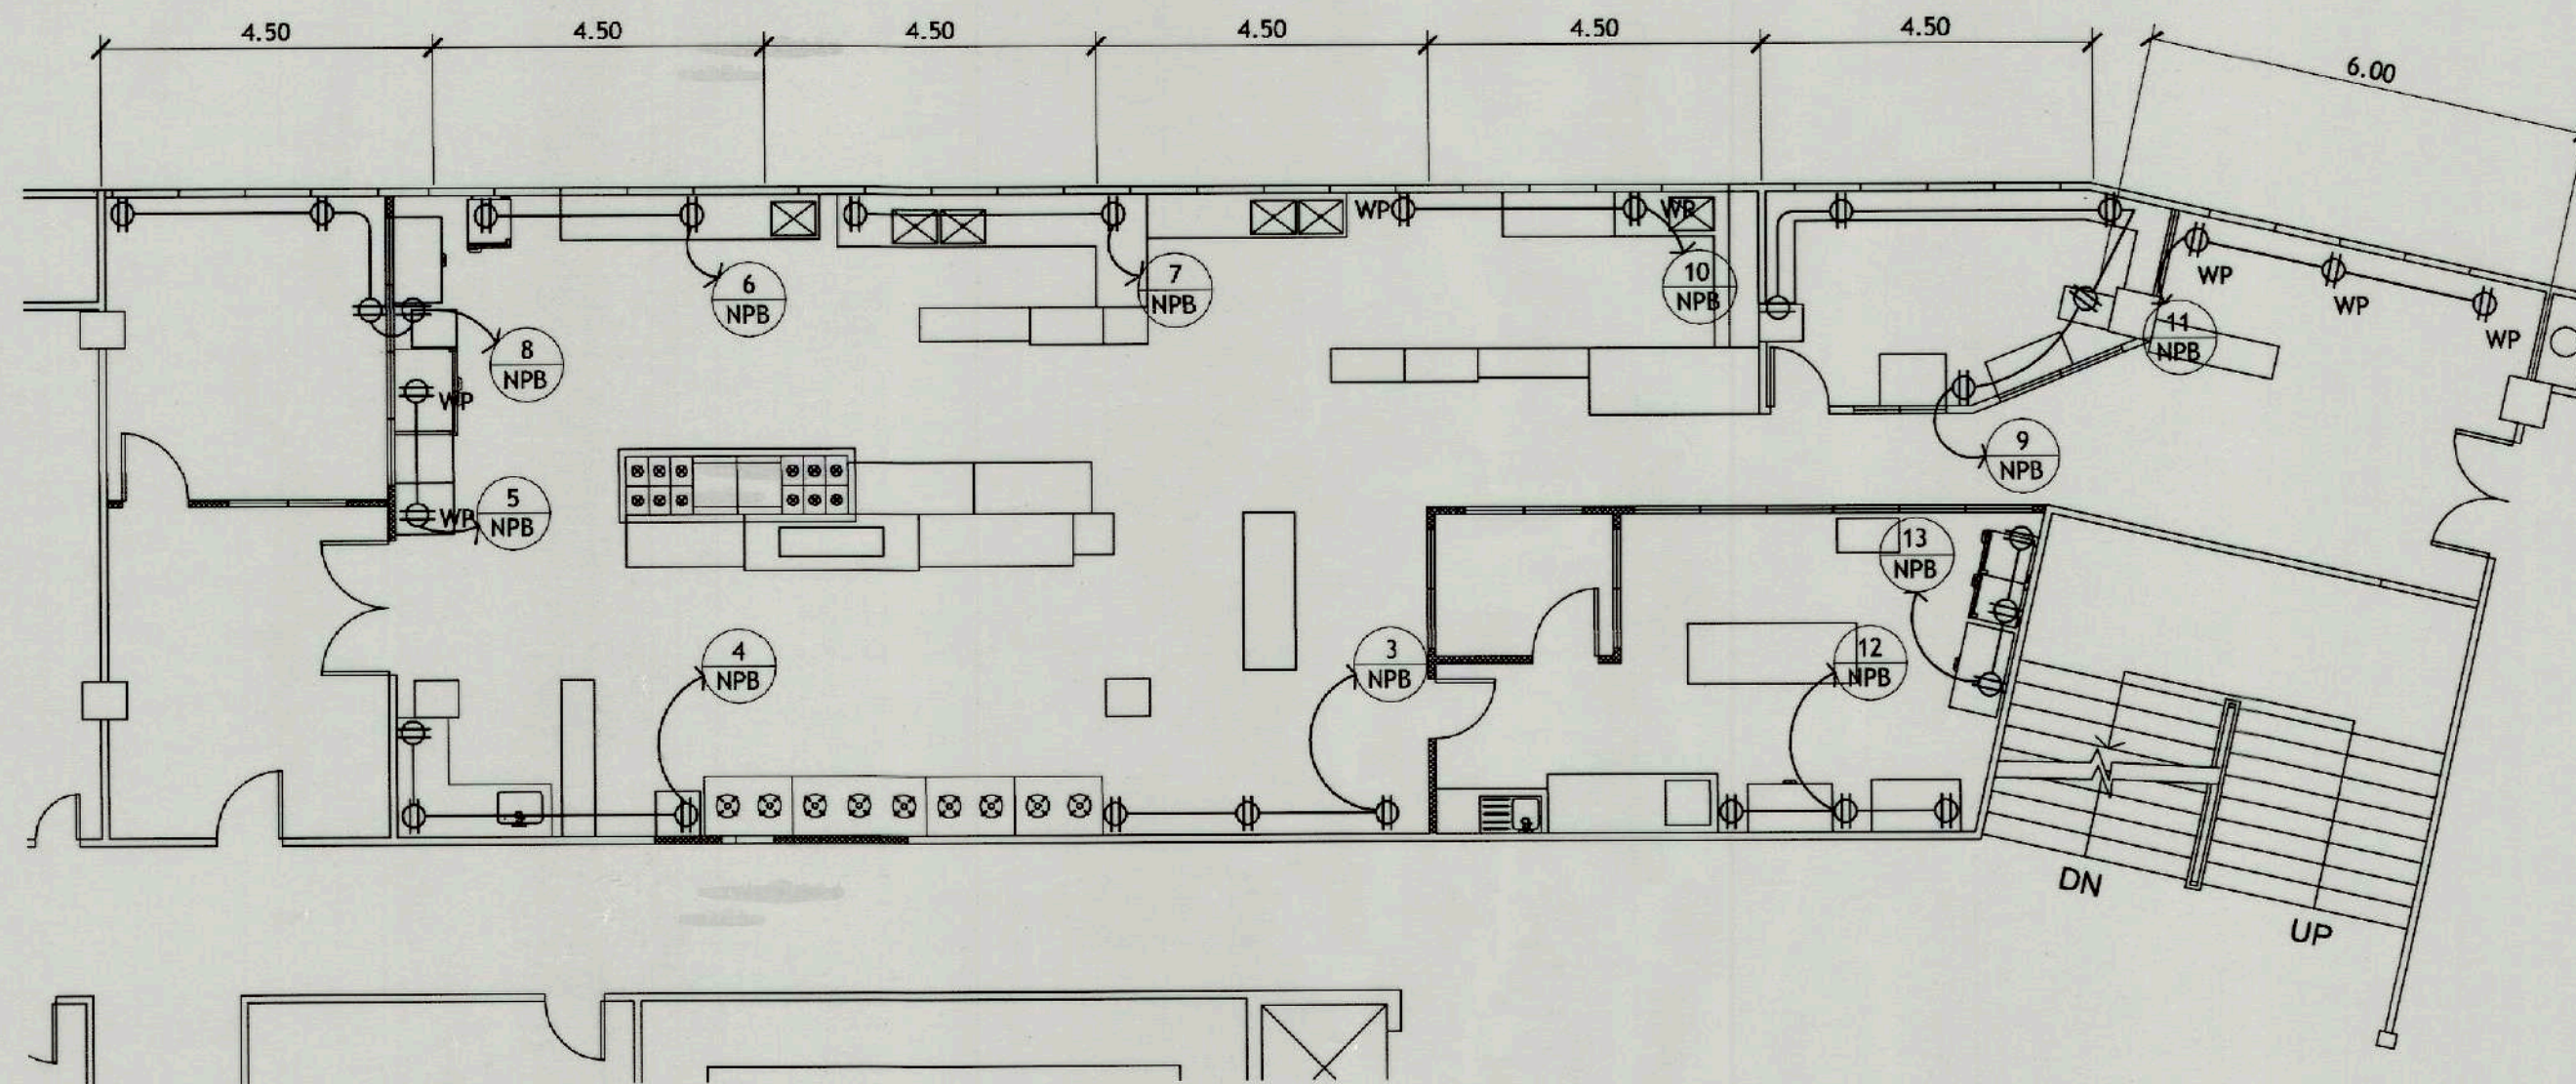


**POWER LAYOUT**

SCALE 1 : 100 MTS

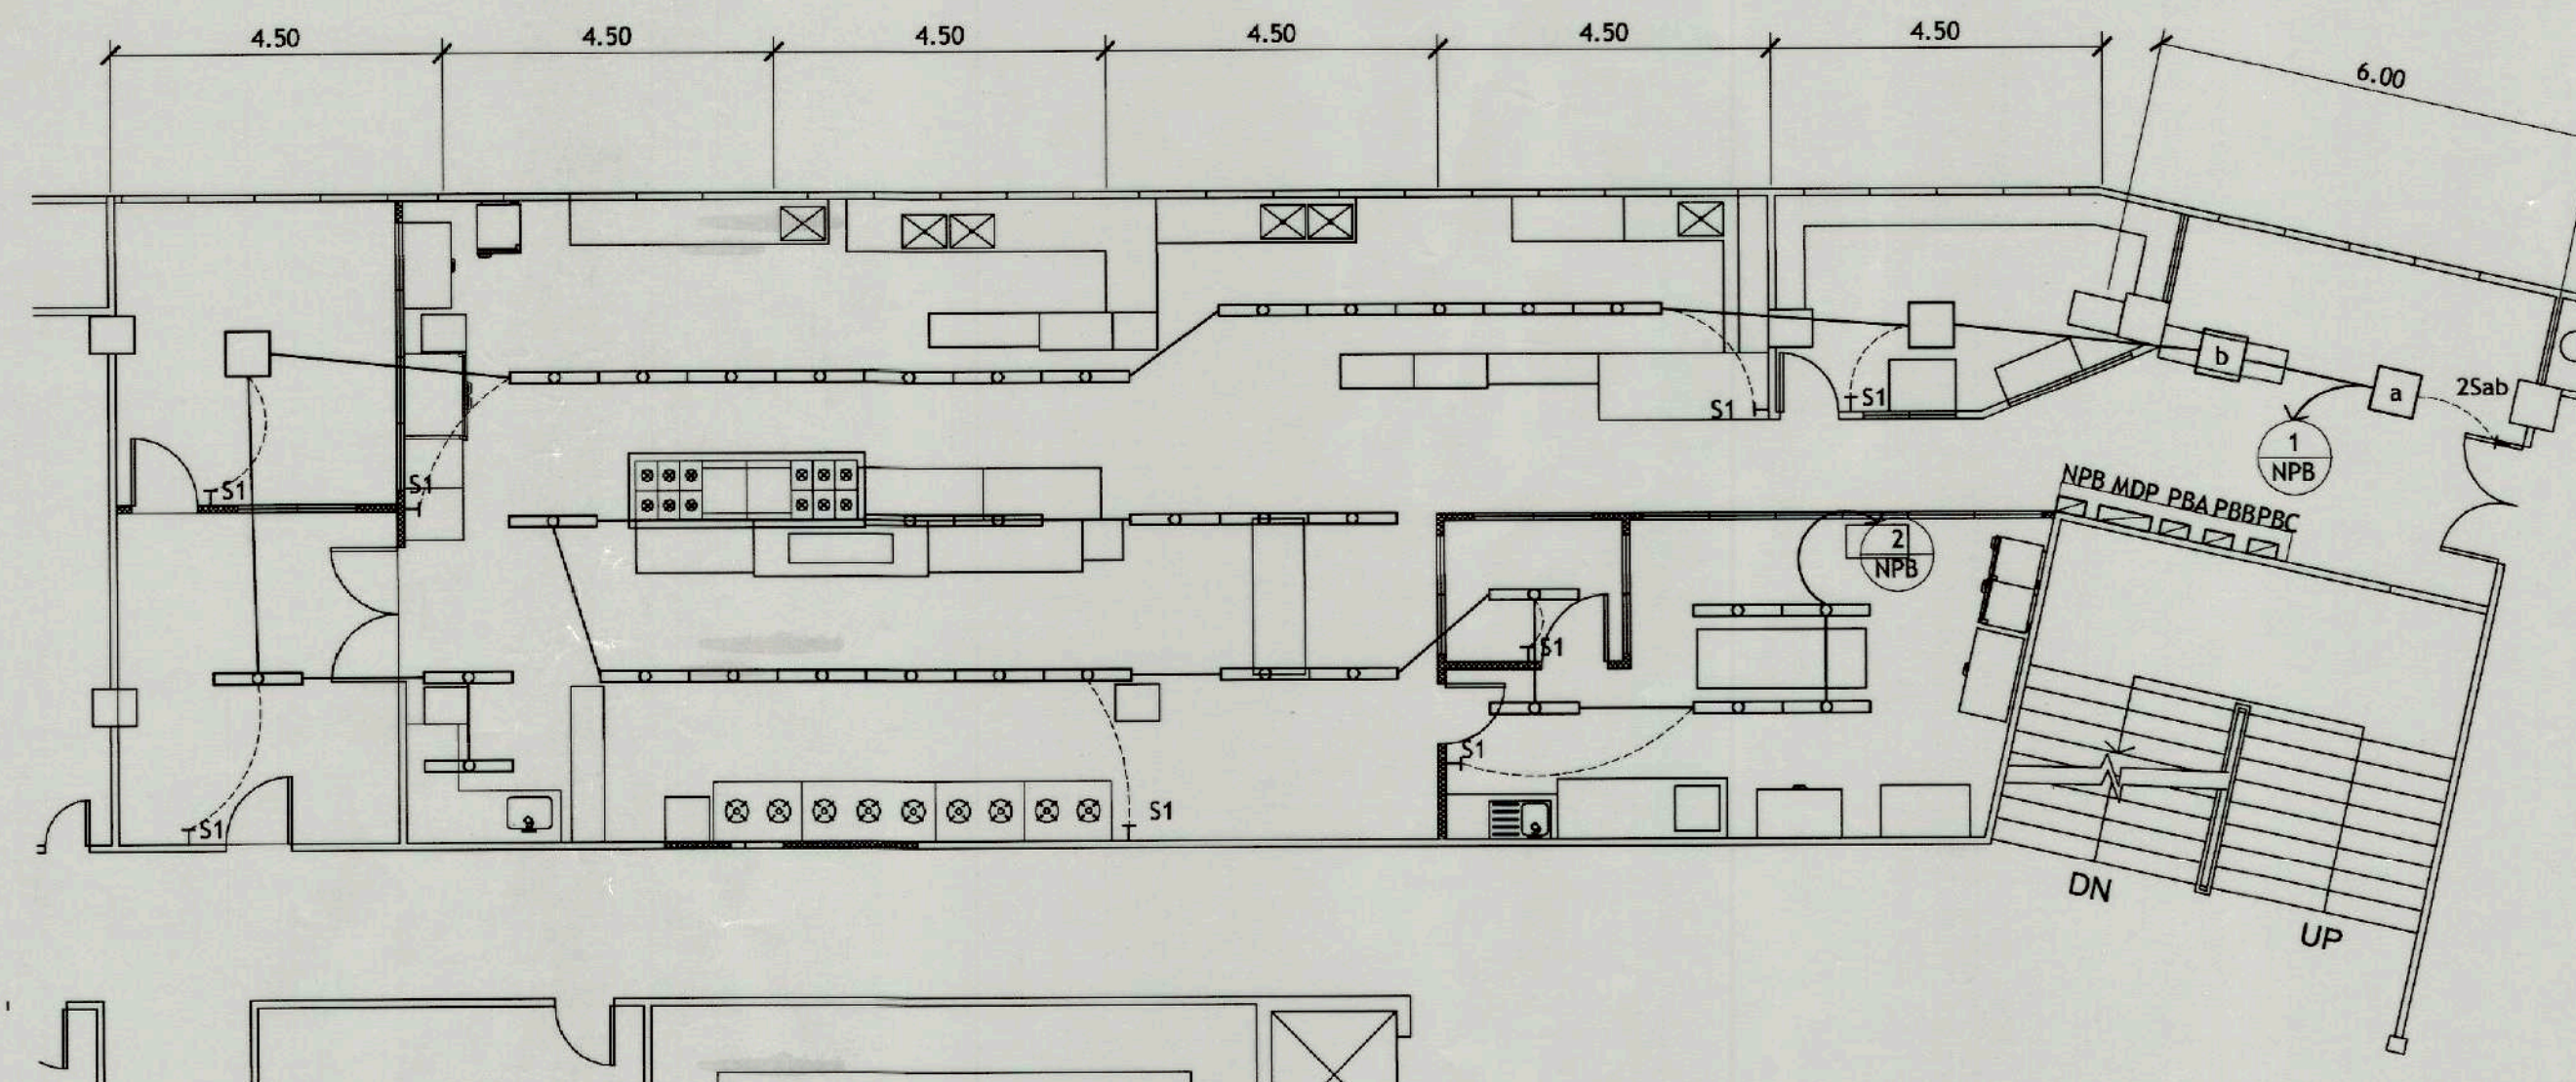


**LIGHTING LAYOUT**

SCALE 1 : 100 MTS

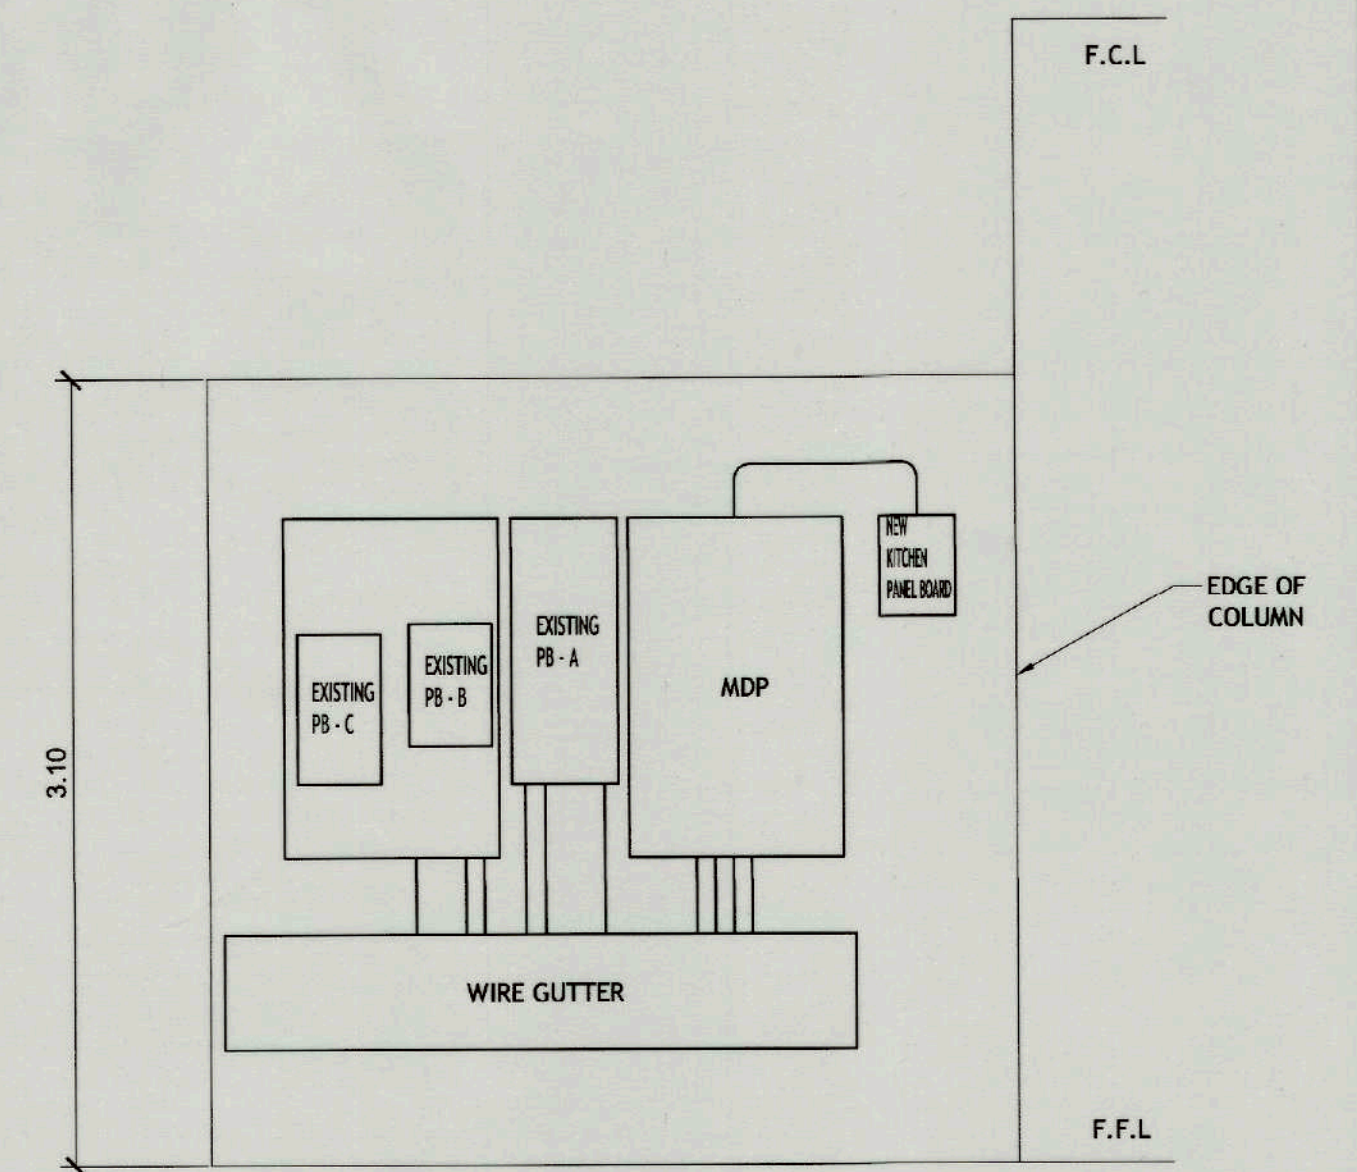

**PANEL BOARD CABINET ELEVATION**


SCALE 1 : 30 MTS

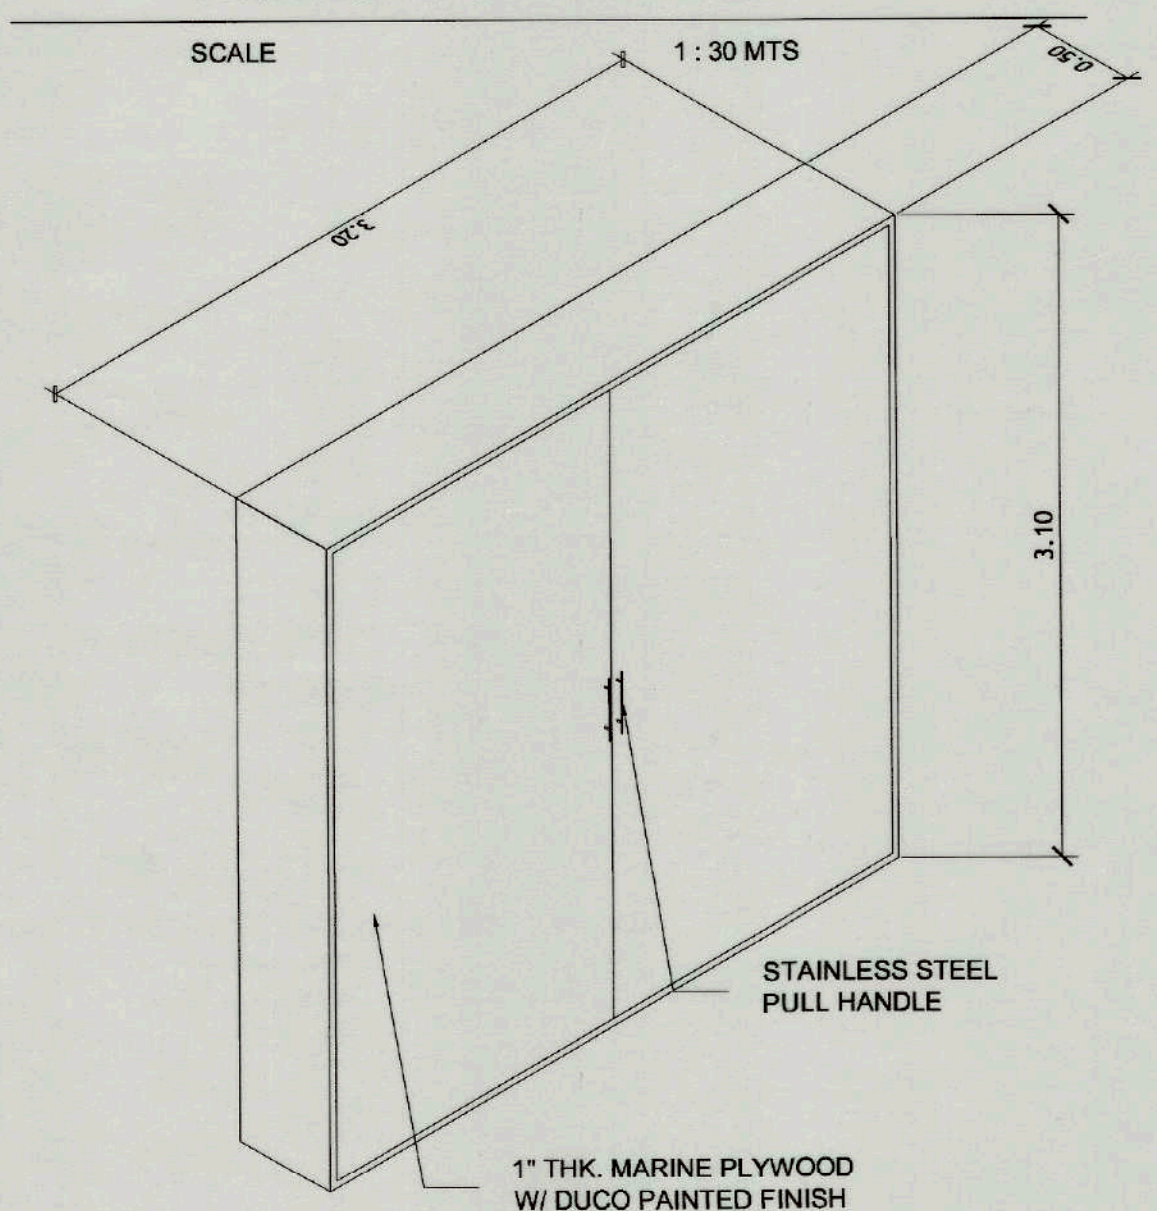

**PANEL BOARD CABINET DETAIL**

SCALE 1 : 100 MTS

 CONFORME :

  
MARLON PRIETO  
Resident Manager  
Banaue Hotel & Youth Hostel





**TIEZA**  
TOURISM INFRASTRUCTURE  
AND ENTERPRISE ZONE AUTHORITY  
142 AMORSOLO ST. LEGASPI VILLAGE  
MAKATI CITY

PROJECT TITLE/LOCATION  
**EMERGENCY WORKS FOR COMPLIANCE  
WITH FIRE DEPARTMENT REQUIREMENT**  
BANAUE, IFUGAO

**PROJECT EVALUATION AND PLANNING DEPARTMENT**

|                                |                                                         |                                                               |
|--------------------------------|---------------------------------------------------------|---------------------------------------------------------------|
| PREPARED BY:<br>ANGELITO ROQUE | CHECKED BY:<br>RADY E. ADAME                            | REVIEWED BY:<br>AMELITA S. CAGANDA                            |
| DRAWN BY:<br>O.B. SAN JUAN     | OFFICER IN CHARGE<br>PROJECT PLANNING & DESIGN DIVISION | OFFICER IN CHARGE<br>PROJECT EVALUATION & PLANNING DEPARTMENT |
| DATE:                          |                                                         |                                                               |

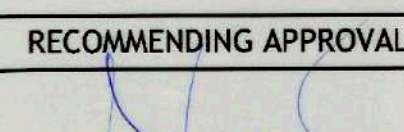RECOMMENDING APPROVAL:  
  
NESTOR M. DOMALANTA  
ASSISTANT CHIEF OPERATING OFFICER  
Architectural & Engineering Services Sector

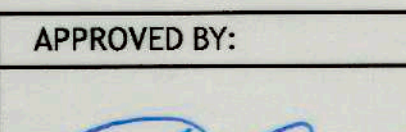APPROVED BY:  
  
POCHOLO J. D. PARAGAS  
CHIEF OPERATING OFFICER

SHEET CONTENTS:  
AS SHOWN  
REVISIONS:

R.A. 545  
THIS DRAWING IS  
THE PROPERTY OF  
TOURISM ENTERPRISE  
ZONE AUTHORITY AND  
CANNOT BE REPRODUCED  
WITHOUT THEIR CONSENT.

SHEET NO.  

|   |    |
|---|----|
| E | 1  |
| 8 | 23 |

CAR-17-04



LOAD SCHEDULE - NPB (KITCHEN)


| CIRCUIT NO. | LOAD DESCRIPTION                    | V   | W    | 3Ø    |      |       | 3Ø CURRENT | SIZE OF WIRE & CONDUIT                                | PROTECTIVE DEVICE  |
|-------------|-------------------------------------|-----|------|-------|------|-------|------------|-------------------------------------------------------|--------------------|
|             |                                     |     |      | 3Ø    | ØAB  | ØBC   |            |                                                       |                    |
| 1           | 22 X 40W FLOURESCENT LAMP           | 230 | 1166 |       | 5.07 |       |            | 2 - 2.0MM² TW WIRE IN 15MMØ PVC PIPE                  | 2P - 15 AT - 50 AF |
| 2           | 21 X 40W FLOURESCENT LAMP           |     | 1113 |       |      | 4.84  |            | - DO -                                                | 2P - 15 AT - 50 AF |
| 3           | 3 X 180W DUPLEX CONVENIENCE OUTLET  |     | 1080 |       | 4.69 |       |            | 2 - 5.5MM² TW WIRE & 1 - 2.0MM² (G) IN 15MMØ PVC PIPE | 2P - 30 AT - 50 AF |
| 4           | 3 X 180W DUPLEX CONVENIENCE OUTLET  |     | 1080 |       | 4.69 |       |            |                                                       |                    |
| 5           | 2 X 1000W DUPLEX CONVENIENCE OUTLET |     | 2000 |       |      |       | 8.69       |                                                       |                    |
| 6           | 2 X 500W DUPLEX CONVENIENCE OUTLET  |     | 1000 |       |      |       | 4.35       |                                                       |                    |
| 7           | 2 X 500W DUPLEX CONVENIENCE OUTLET  |     | 1000 |       | 4.35 |       |            |                                                       |                    |
| 8           | 4 X 1000W DUPLEX CONVENIENCE OUTLET |     | 4000 |       |      | 17.39 |            |                                                       |                    |
| 9           | 5 X 180W DUPLEX CONVENIENCE OUTLET  |     | 1800 |       | 7.82 |       |            |                                                       |                    |
| 10          | 2 X 1000W DUPLEX CONVENIENCE OUTLET |     | 2000 |       |      |       | 8.69       |                                                       |                    |
| 11          | 3 X 300W DUPLEX CONVENIENCE OUTLET  |     | 900  |       |      | 3.92  |            |                                                       |                    |
| 12          | 3 X 300W DUPLEX CONVENIENCE OUTLET  |     | 900  |       |      |       | 3.92       |                                                       |                    |
| 13          | 3 X 300W DUPLEX CONVENIENCE OUTLET  |     | 900  |       |      |       | 3.92       |                                                       |                    |
| 14          | 1 X 7.5 HP INDUCTION MOTOR          |     |      | 22    |      |       |            | 2 - 8.0MM² TW WIRE & 1 - 2.0MM² (G) IN 32MMØ PVC PIPE | 3P - 40 AT - 50 AF |
|             |                                     |     |      | 19119 | 22   | 26.62 | 26.15      | 29.57                                                 |                    |

IT = 3Ø = 22 + √3 (29.57) + 0.25 (17.39) (√3) = 51.22 + 7.52 + 22 = 80.74AMPS


SIZE OF MAIN CONDUCTORS: USE 3 - 30.0MM² THW WIRE & 1 - 5.5MM² (G) IN 50MMØ RSC PIPE


MAIN DISCONNECTING MEANS: PROVIDE 3P - 100AT - 100AF, 240VAC MCCB

- NOTE:
- 1. MAIN CONDUCTOR SHALL BE CONNECTED/TAPPED TO THE CKT. # 7 OF EXISTING MDP.
  - 2. DISCONNECT THE EXISTING 3 # 8 CABLE FOR EXHAUST FAN.

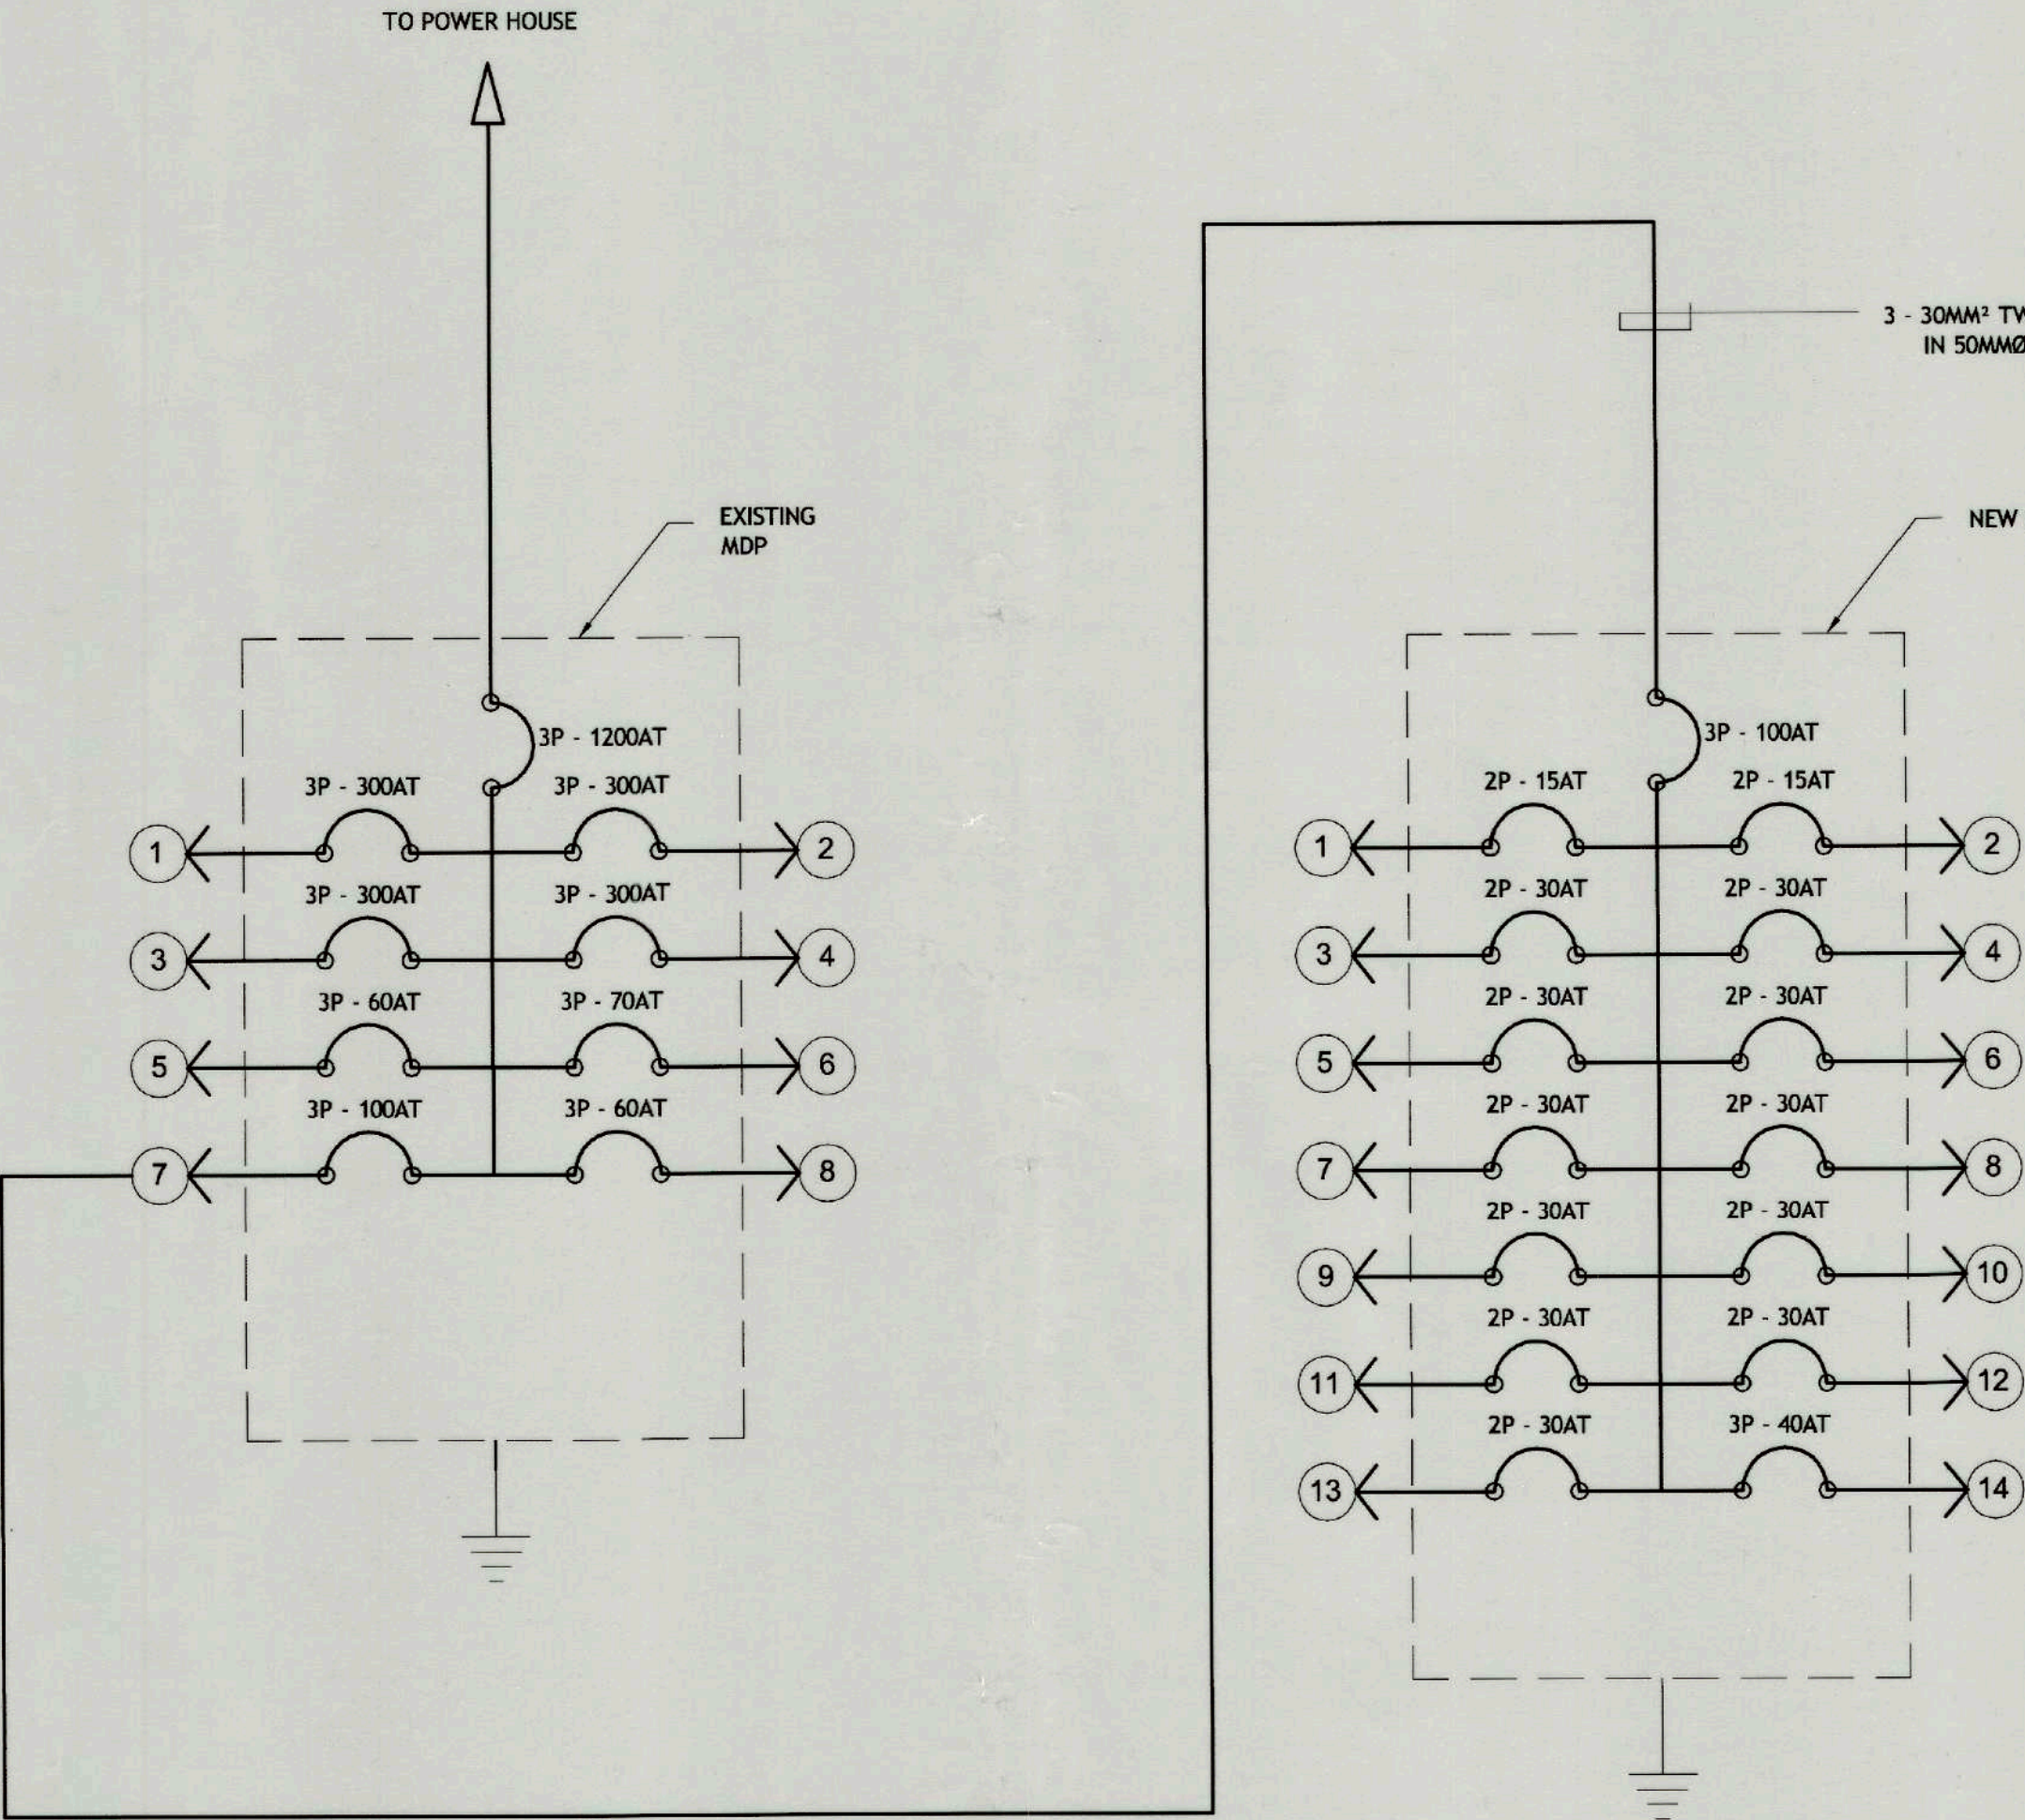

RISER DIAGRAM
 
|                                                                                                                                                           |                                                                                                                   |             |
|-----------------------------------------------------------------------------------------------------------------------------------------------------------|-------------------------------------------------------------------------------------------------------------------|-------------|
| CONFORME :                                                                                                                                                |                                                                                                                   |             |
| <br>MARLON PRIETO<br>Resident Manager<br>Banaue Hotel & Youth Hostel |                                                                                                                   |             |
| SHEET CONTENTS:                                                                                                                                           | R.A. 545                                                                                                          | SHEET NO.   |
| AS SHOWN                                                                                                                                                  | THIS DRAWING IS THE PROPERTY OF TOURISM ENTERPRISE ZONE AUTHORITY AND CANNOT BE REPRODUCED WITHOUT THEIR CONSENT. | E 2<br>8 23 |
| REVISIONS:                                                                                                                                                |                                                                                                                   |             |

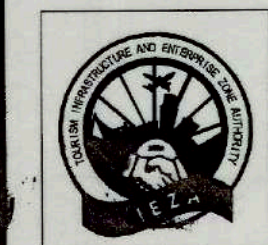



**TIEZA**  
TOURISM INFRASTRUCTURE  
AND ENTERPRISE ZONE AUTHORITY  
142 AMORSOLO ST. LEGASPI VILLAGE  
MAKATI CITY

PROJECT TITLE/LOCATION  
EMERGENCY WORKS FOR COMPLIANCE  
WITH FIRE DEPARTMENT REQUIREMENT  
BANAUE, IFUGAO

PROJECT EVALUATION AND PLANNING DEPARTMENT

|                                  |                                                         |                                                               |
|----------------------------------|---------------------------------------------------------|---------------------------------------------------------------|
| PREPARED BY:<br>ANGELITO ROQUE   | CHECKED BY:<br>RADY E. ADAME                            | REVIEWED BY:<br>AMELITA S. CAGANDA                            |
| DRAWN BY: O.B. SAN JUAN<br>DATE: | OFFICER IN CHARGE<br>PROJECT PLANNING & DESIGN DIVISION | OFFICER IN CHARGE<br>PROJECT EVALUATION & PLANNING DEPARTMENT |

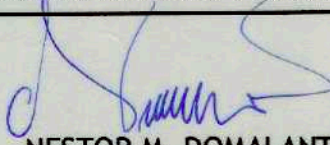RECOMMENDING APPROVAL:  
  
NESTOR M. DOMALANTA  
ASSISTANT CHIEF OPERATING OFFICER  
Architectural & Engineering Services Sector

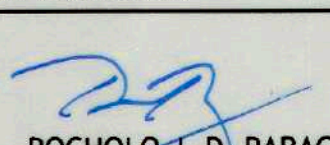APPROVED BY:  
  
POCHOLO J. D. PARAGAS  
CHIEF OPERATING OFFICER


SHEET CONTENTS:  
AS SHOWN  
REVISIONS:

R.A. 545  
THIS DRAWING IS THE PROPERTY OF TOURISM ENTERPRISE ZONE AUTHORITY AND CANNOT BE REPRODUCED WITHOUT THEIR CONSENT.



SHEET NO.  
E 2  
8 23

CAR-17-04









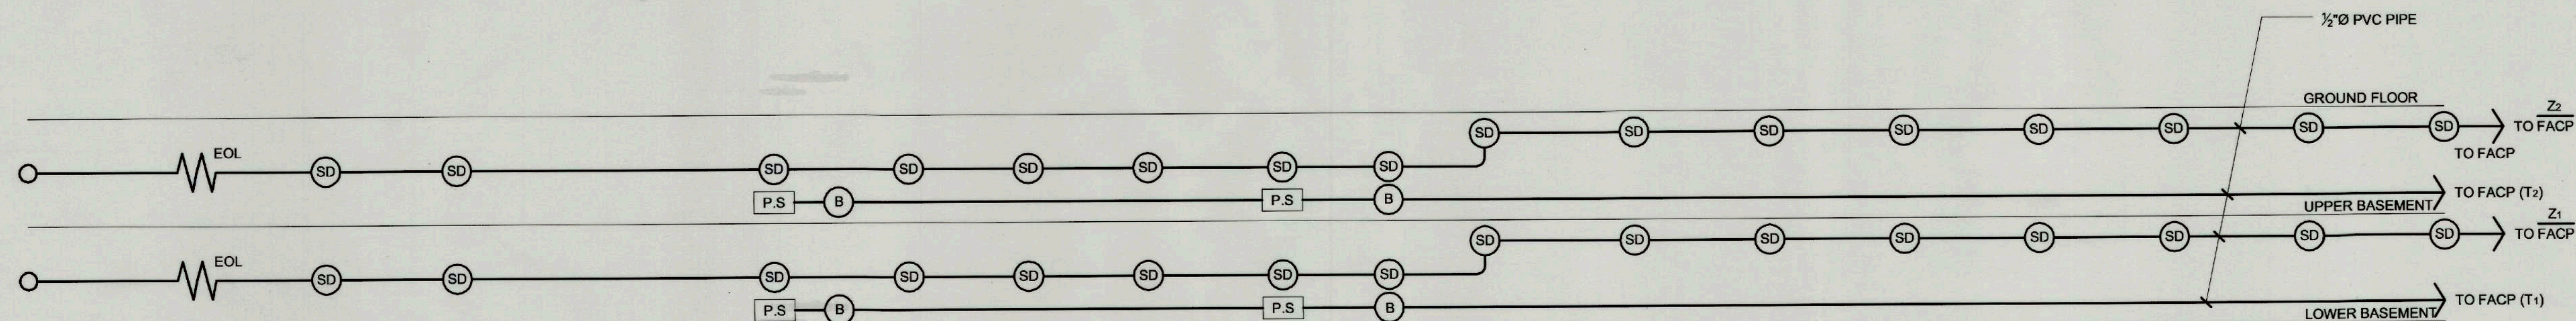

## FIRE ALARM SYSTEM LAYOUT (NEW BLDG.)

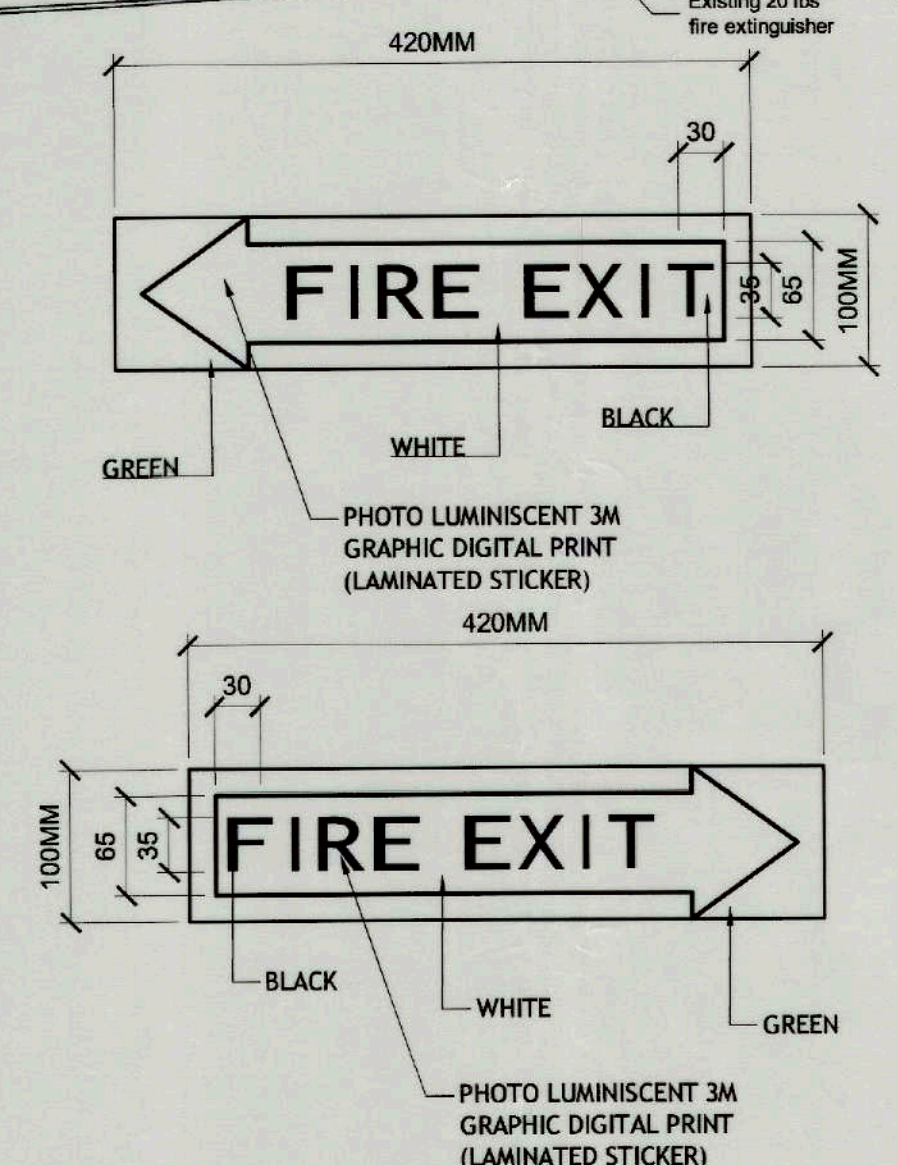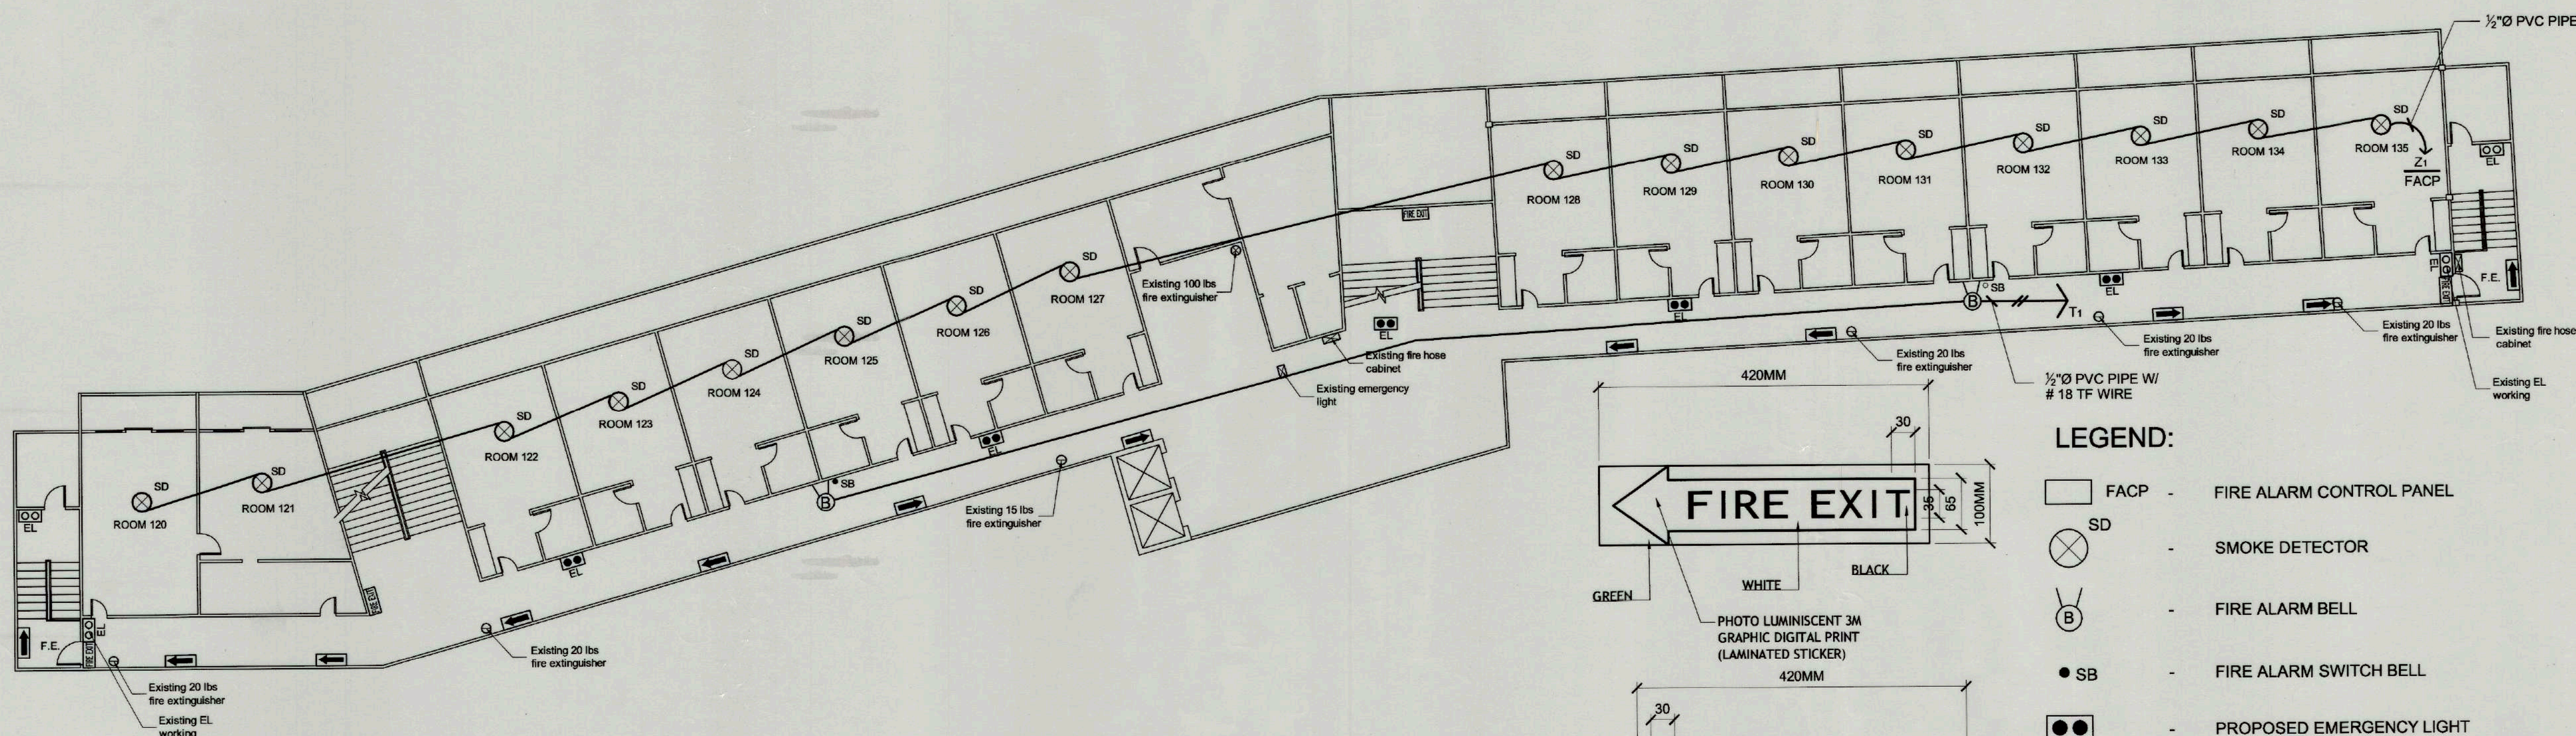

### LEGEND:

      
-  FACP - FIRE ALARM CONTROL PANEL
-  SD - SMOKE DETECTOR
-  B - FIRE ALARM BELL
-  SB - FIRE ALARM SWITCH BELL
-  EL - PROPOSED EMERGENCY LIGHT
-  - DIRECTIONAL FIRE EXIT SIGN
-  - FIRE EXIT SIGN W/ LIGHTING
-  - EXISTING EMERGENCY LIGHT NON-WORKING
-  - EXISTING EMERGENCY LIGHT WORKING
-  Z1 FACP - ZONE 1 CIRCUIT FACP

## LOWER BASEMENT SMOKE DETECTOR/FIRE ALARM/EMERGENCY LIGHT/SIGNAGES LAYOUT (NEW BLDG.)

 SCALE

1: 150 MTS

CONFORME :

  
MARLON PRIETO  
Resident Manager  
Banaue Hotel & Youth Hostel

PROJECT TITLE/LOCATION

EMERGENCY WORKS FOR COMPLIANCE  
WITH FIRE DEPARTMENT REQUIREMENT

BANAUE,

IFUGAO

### PROJECT EVALUATION AND PLANNING DEPARTMENT

PREPARED BY:

ANGELITO ROQUE

DRAWN BY: O.B. SAN JUAN

DATE:

CHECKED BY:

RADY E. ADAME


OFFICER IN CHARGE  
PROJECT PLANNING & DESIGN DIVISION

REVIEWED BY:

AMELITA S. CAGANDA


OFFICER IN CHARGE  
PROJECT EVALUATION & PLANNING DEPARTMENT

RECOMMENDING APPROVAL:

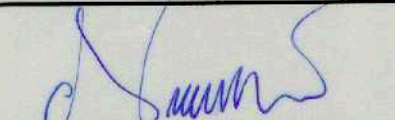  
NESTOR M. DOMALANTA

ASSISTANT CHIEF OPERATING OFFICER  
Architectural & Engineering Services Sector

APPROVED BY:

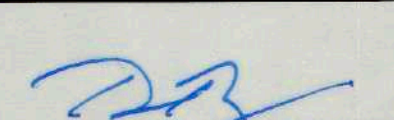  
POCHOLO J. D. PARAGAS

CHIEF OPERATING OFFICER

SHEET CONTENTS:

AS SHOWN

REVISIONS:

R.A. 545

SHEET NO.


E 3  
8 23



**TIEZA**  
TOURISM INFRASTRUCTURE  
AND ENTERPRISE ZONE AUTHORITY  
142 AMORSOLO ST. LEGASPI VILLAGE  
MAKATI CITY

CAR-17-04



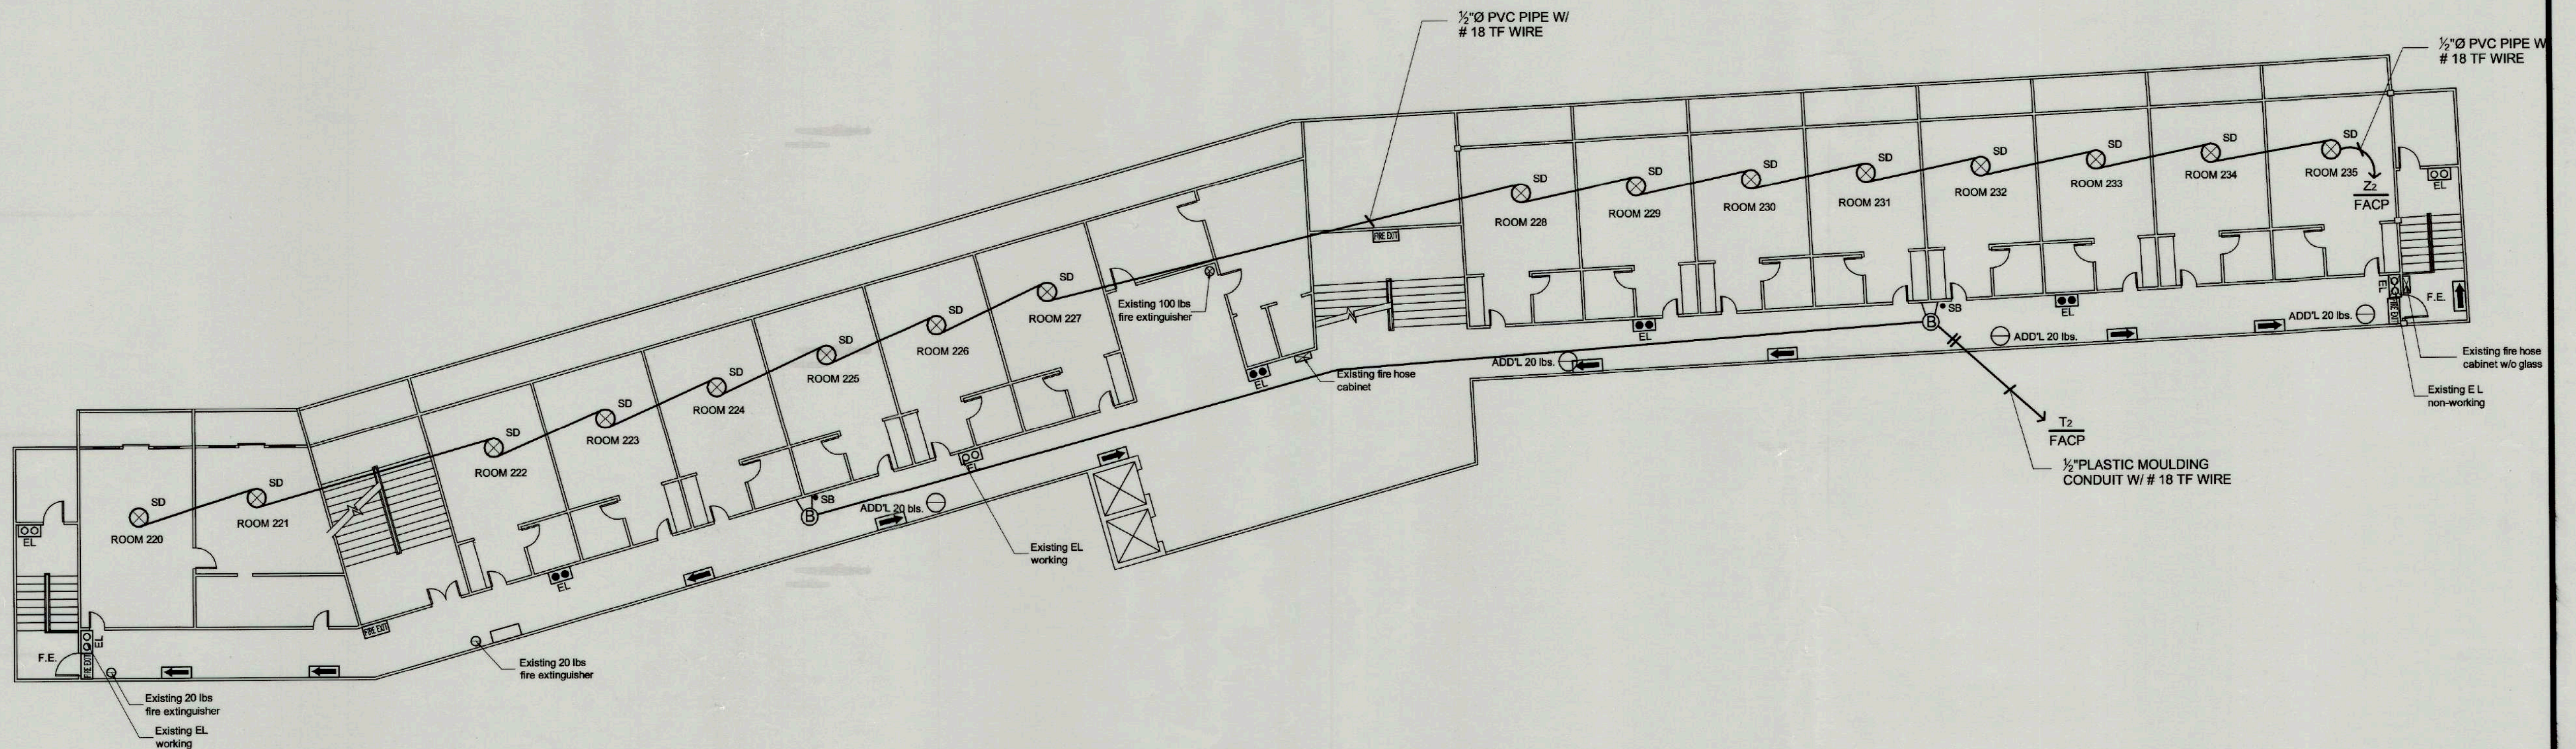

UPPER BASEMENT SMOKE DETECTOR/FIRE ALARM/EMERGENCY LIGHT/SIGNAGES LAYOUT (NEW BLDG.)

SCALE

1 : 150 MTS

CONFORME :

*Marlon Prieto*  
**MARLON PRIETO**  
 Resident Manager  
 Banaue Hotel & Youth Hostel


|                                                                                                                                                                                                                                                               |                                                                                                                                 |                                            |                                                         |                                                               |                                                                                  |                         |                 |          |           |
|---------------------------------------------------------------------------------------------------------------------------------------------------------------------------------------------------------------------------------------------------------------|---------------------------------------------------------------------------------------------------------------------------------|--------------------------------------------|---------------------------------------------------------|---------------------------------------------------------------|----------------------------------------------------------------------------------|-------------------------|-----------------|----------|-----------|
|  <p><b>TIEZA</b><br/>         TOURISM INFRASTRUCTURE<br/>         AND ENTERPRISE ZONE AUTHORITY<br/>         142 AMORSOLO ST. LEGASPI VILLAGE<br/>         MAKATI CITY</p> | PROJECT TITLE/LOCATION<br><b>EMERGENCY WORKS FOR COMPLIANCE<br/>         WITH FIRE DEPARTMENT REQUIREMENT</b><br>BANAUE, IFUGAO | PROJECT EVALUATION AND PLANNING DEPARTMENT |                                                         |                                                               | RECOMMENDING APPROVAL:                                                           | APPROVED BY:            | SHEET CONTENTS: | R.A. 545 | SHEET NO. |
|                                                                                                                                                                                                                                                               |                                                                                                                                 | PREPARED BY:                               | CHECKED BY:                                             | REVIEWED BY:                                                  |                                                                                  |                         |                 |          |           |
|                                                                                                                                                                                                                                                               |                                                                                                                                 | ANGELITO ROQUE                             | RADY E. ADAME                                           | AMELITA S. CAGANDA                                            | NESTOR M. DOMALANTA                                                              | POCHOLO J. D. PARAGAS   | AS SHOWN        |          |           |
|                                                                                                                                                                                                                                                               |                                                                                                                                 | DRAWN BY: O.B. SAN JUAN<br>DATE:           | OFFICER IN CHARGE<br>PROJECT PLANNING & DESIGN DIVISION | OFFICER IN CHARGE<br>PROJECT EVALUATION & PLANNING DEPARTMENT | ASSISTANT CHIEF OPERATING OFFICER<br>Architectural & Engineering Services Sector | CHIEF OPERATING OFFICER | REVISIONS:      |          |           |

THIS DRAWING IS  
 THE PROPERTY OF  
 TOURISM ENTERPRISE  
 ZONE AUTHORITY AND  
 CANNOT BE REPRODUCED  
 WITHOUT  
 THEIR CONSENT.


E 4  
 8 23

CAR-17-04



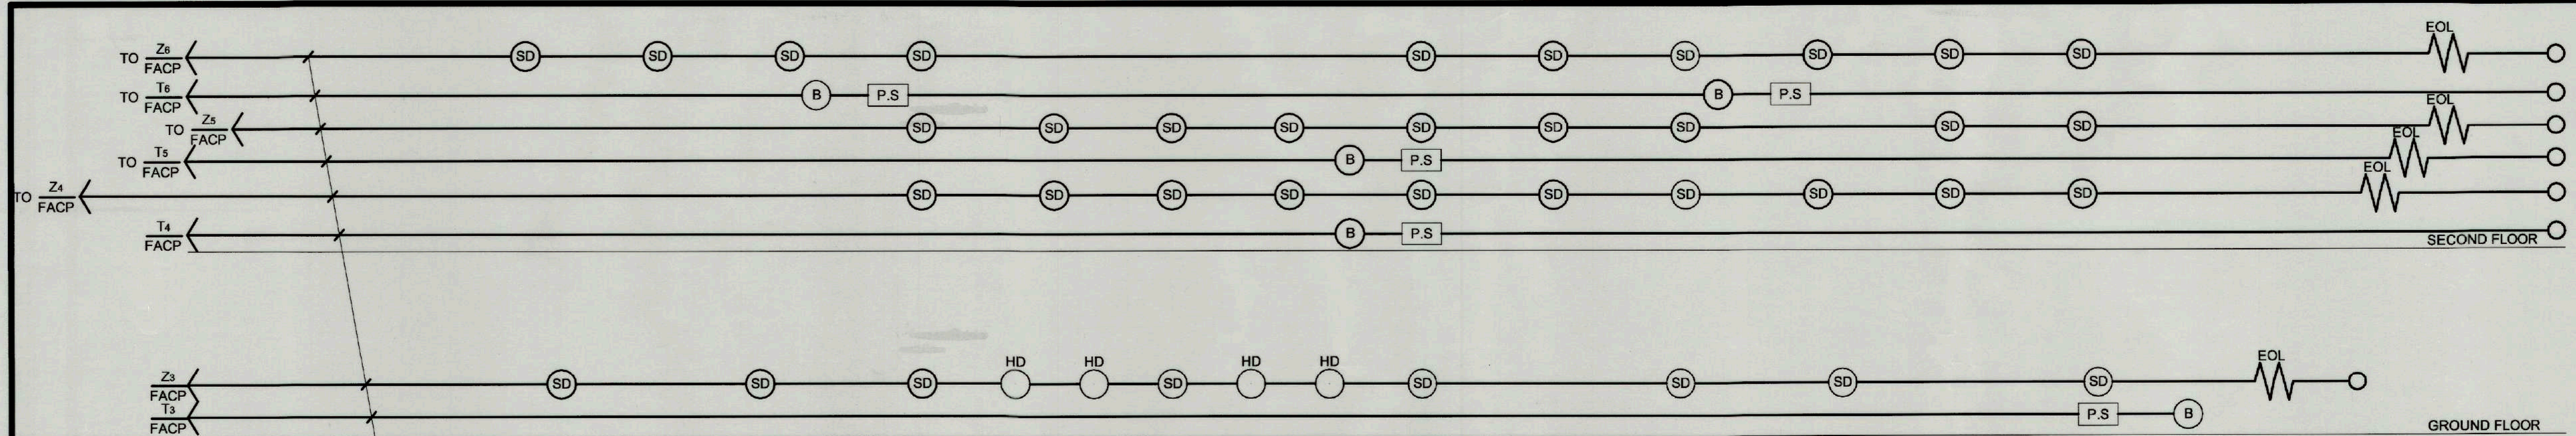

FIRE ALARM SYSTEM LAYOUT (OLD BLDG.)

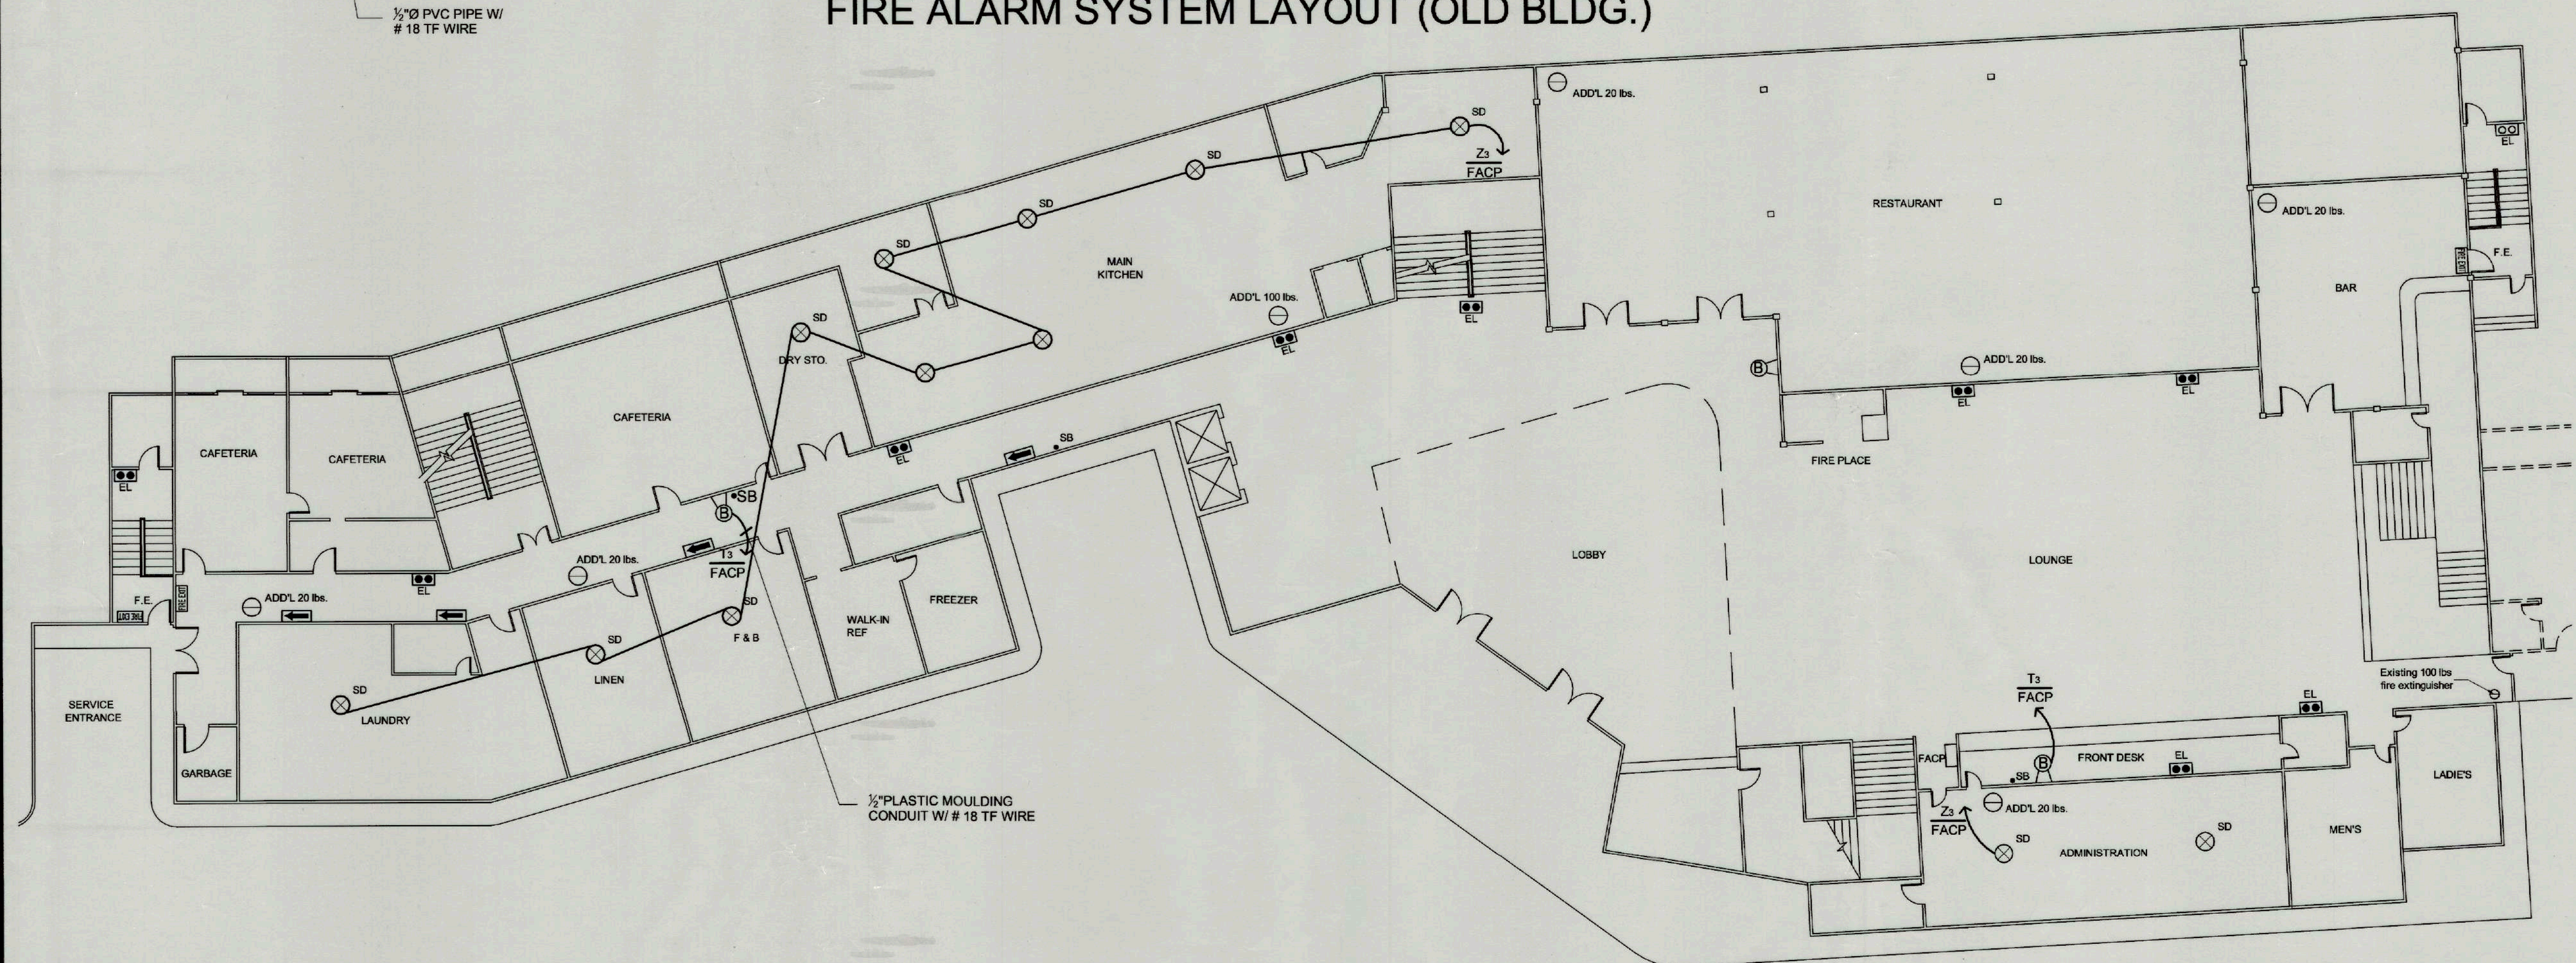

GROUND FLOOR SMOKE DETECTOR/FIRE ALARM/EMERGENCY LIGHT/SIGNAGES LAYOUT (NEW BLDG.)

SCALE 1 : 150 MTS

CONFORME :

*Marlon Prieto*  
**MARLON PRIETO**  
 Resident Manager  
 Banaue Hotel & Youth Hostel

SHEET CONTENTS: AS SHOWN

R.A. 545

SHEET NO. E 5 / 8 23

REVISIONS:

**TIEZA**  
 TOURISM INFRASTRUCTURE  
 AND ENTERPRISE ZONE AUTHORITY  
 142 AMORSOLO ST. LEGASPI VILLAGE  
 MAKATI CITY

PROJECT TITLE/LOCATION  
 EMERGENCY WORKS FOR COMPLIANCE  
 WITH FIRE DEPARTMENT REQUIREMENT  
 BANAUE, IFUGAO


| PROJECT EVALUATION AND PLANNING DEPARTMENT |                                                         |                                                               |
|--------------------------------------------|---------------------------------------------------------|---------------------------------------------------------------|
| PREPARED BY:<br>ANGELITO ROQUE             | CHECKED BY:<br>RADY E. ADAME                            | REVIEWED BY:<br>AMELITA S. CAGANDA                            |
| DRAWN BY: O.B. SAN JUAN<br>DATE:           | OFFICER IN CHARGE<br>PROJECT PLANNING & DESIGN DIVISION | OFFICER IN CHARGE<br>PROJECT EVALUATION & PLANNING DEPARTMENT |

RECOMMENDING APPROVAL:  
*Nestor M. Domalanta*  
**NESTOR M. DOMALANTA**  
 ASSISTANT CHIEF OPERATING OFFICER  
 Architectural & Engineering Services Section

APPROVED BY:  
*Pocholo J. D. Paragas*  
**POCHOLO J. D. PARAGAS**  
 CHIEF OPERATING OFFICER

CAR-17-04



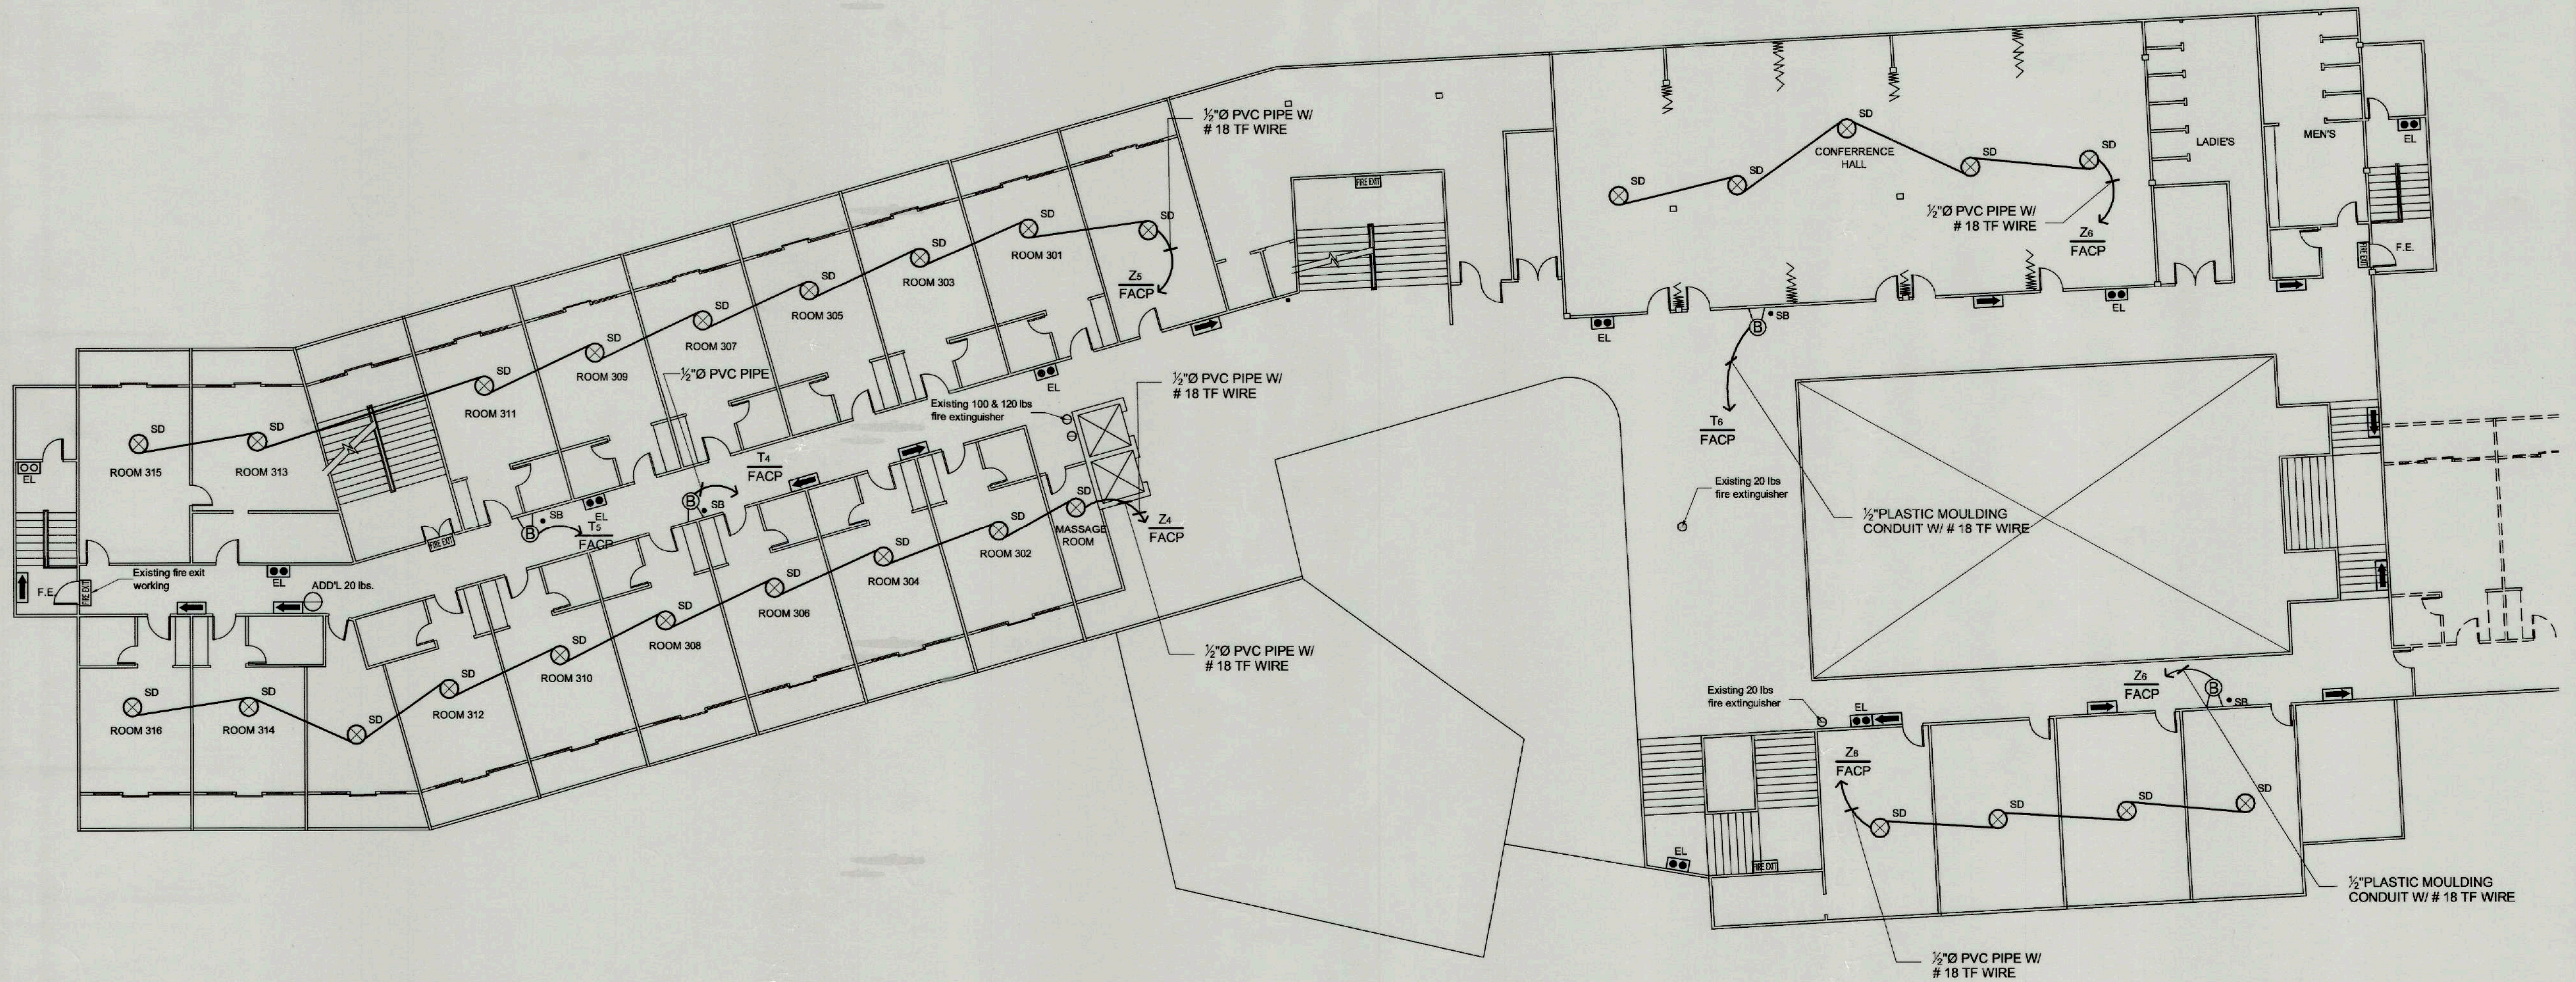

SECOND FLOOR SMOKE DETECTOR/FIRE ALARM/SIGNAGES LAYOUT (NEW BLDG.)

SCALE

1 : 150 MTS

CONFORME :

*Marlon Prieto*  
MARLON PRIETO  
Resident Manager  
Banaue Hotel & Youth Hostel



**TIEZA**  
TOURISM INFRASTRUCTURE  
AND ENTERPRISE ZONE AUTHORITY  
142 AMORSOLO ST. LEGASPI VILLAGE  
MAKATI CITY

PROJECT TITLE/LOCATION  
**EMERGENCY WORKS FOR COMPLIANCE  
WITH FIRE DEPARTMENT REQUIREMENT**  
BANAUE, IFUGAO

PROJECT EVALUATION AND PLANNING DEPARTMENT

PREPARED BY:  
*Angelito Roque*  
ANGELITO ROQUE  
DRAWN BY: O.B. SAN JUAN  
DATE:

CHECKED BY:  
*Rady E. Adame*  
RADY E. ADAME  
OFFICER IN CHARGE  
PROJECT PLANNING & DESIGN DIVISION

REVIEWED BY:  
*Amelita S. Caganda*  
AMELITA S. CAGANDA  
OFFICER IN CHARGE  
PROJECT EVALUATION & PLANNING DEPARTMENT

RECOMMENDING APPROVAL:  
*Nestor M. Domalanta*  
NESTOR M. DOMALANTA  
ASSISTANT CHIEF OPERATING OFFICER  
Architectural & Engineering Services Sector

APPROVED BY:  
*Pocholo J. D. Paragas*  
POCHOLO J. D. PARAGAS  
CHIEF OPERATING OFFICER


SHEET CONTENTS:  
AS SHOWN  
REVISIONS:

R.A. 545  
THIS DRAWING IS  
THE PROPERTY OF  
TOURISM ENTERPRISE  
ZONE AUTHORITY AND  
CANNOT BE REPRO-  
DUCED WITHOUT  
THEIR CONSENT.


SHEET NO.  
E 6  
8 23

CAR-17-04




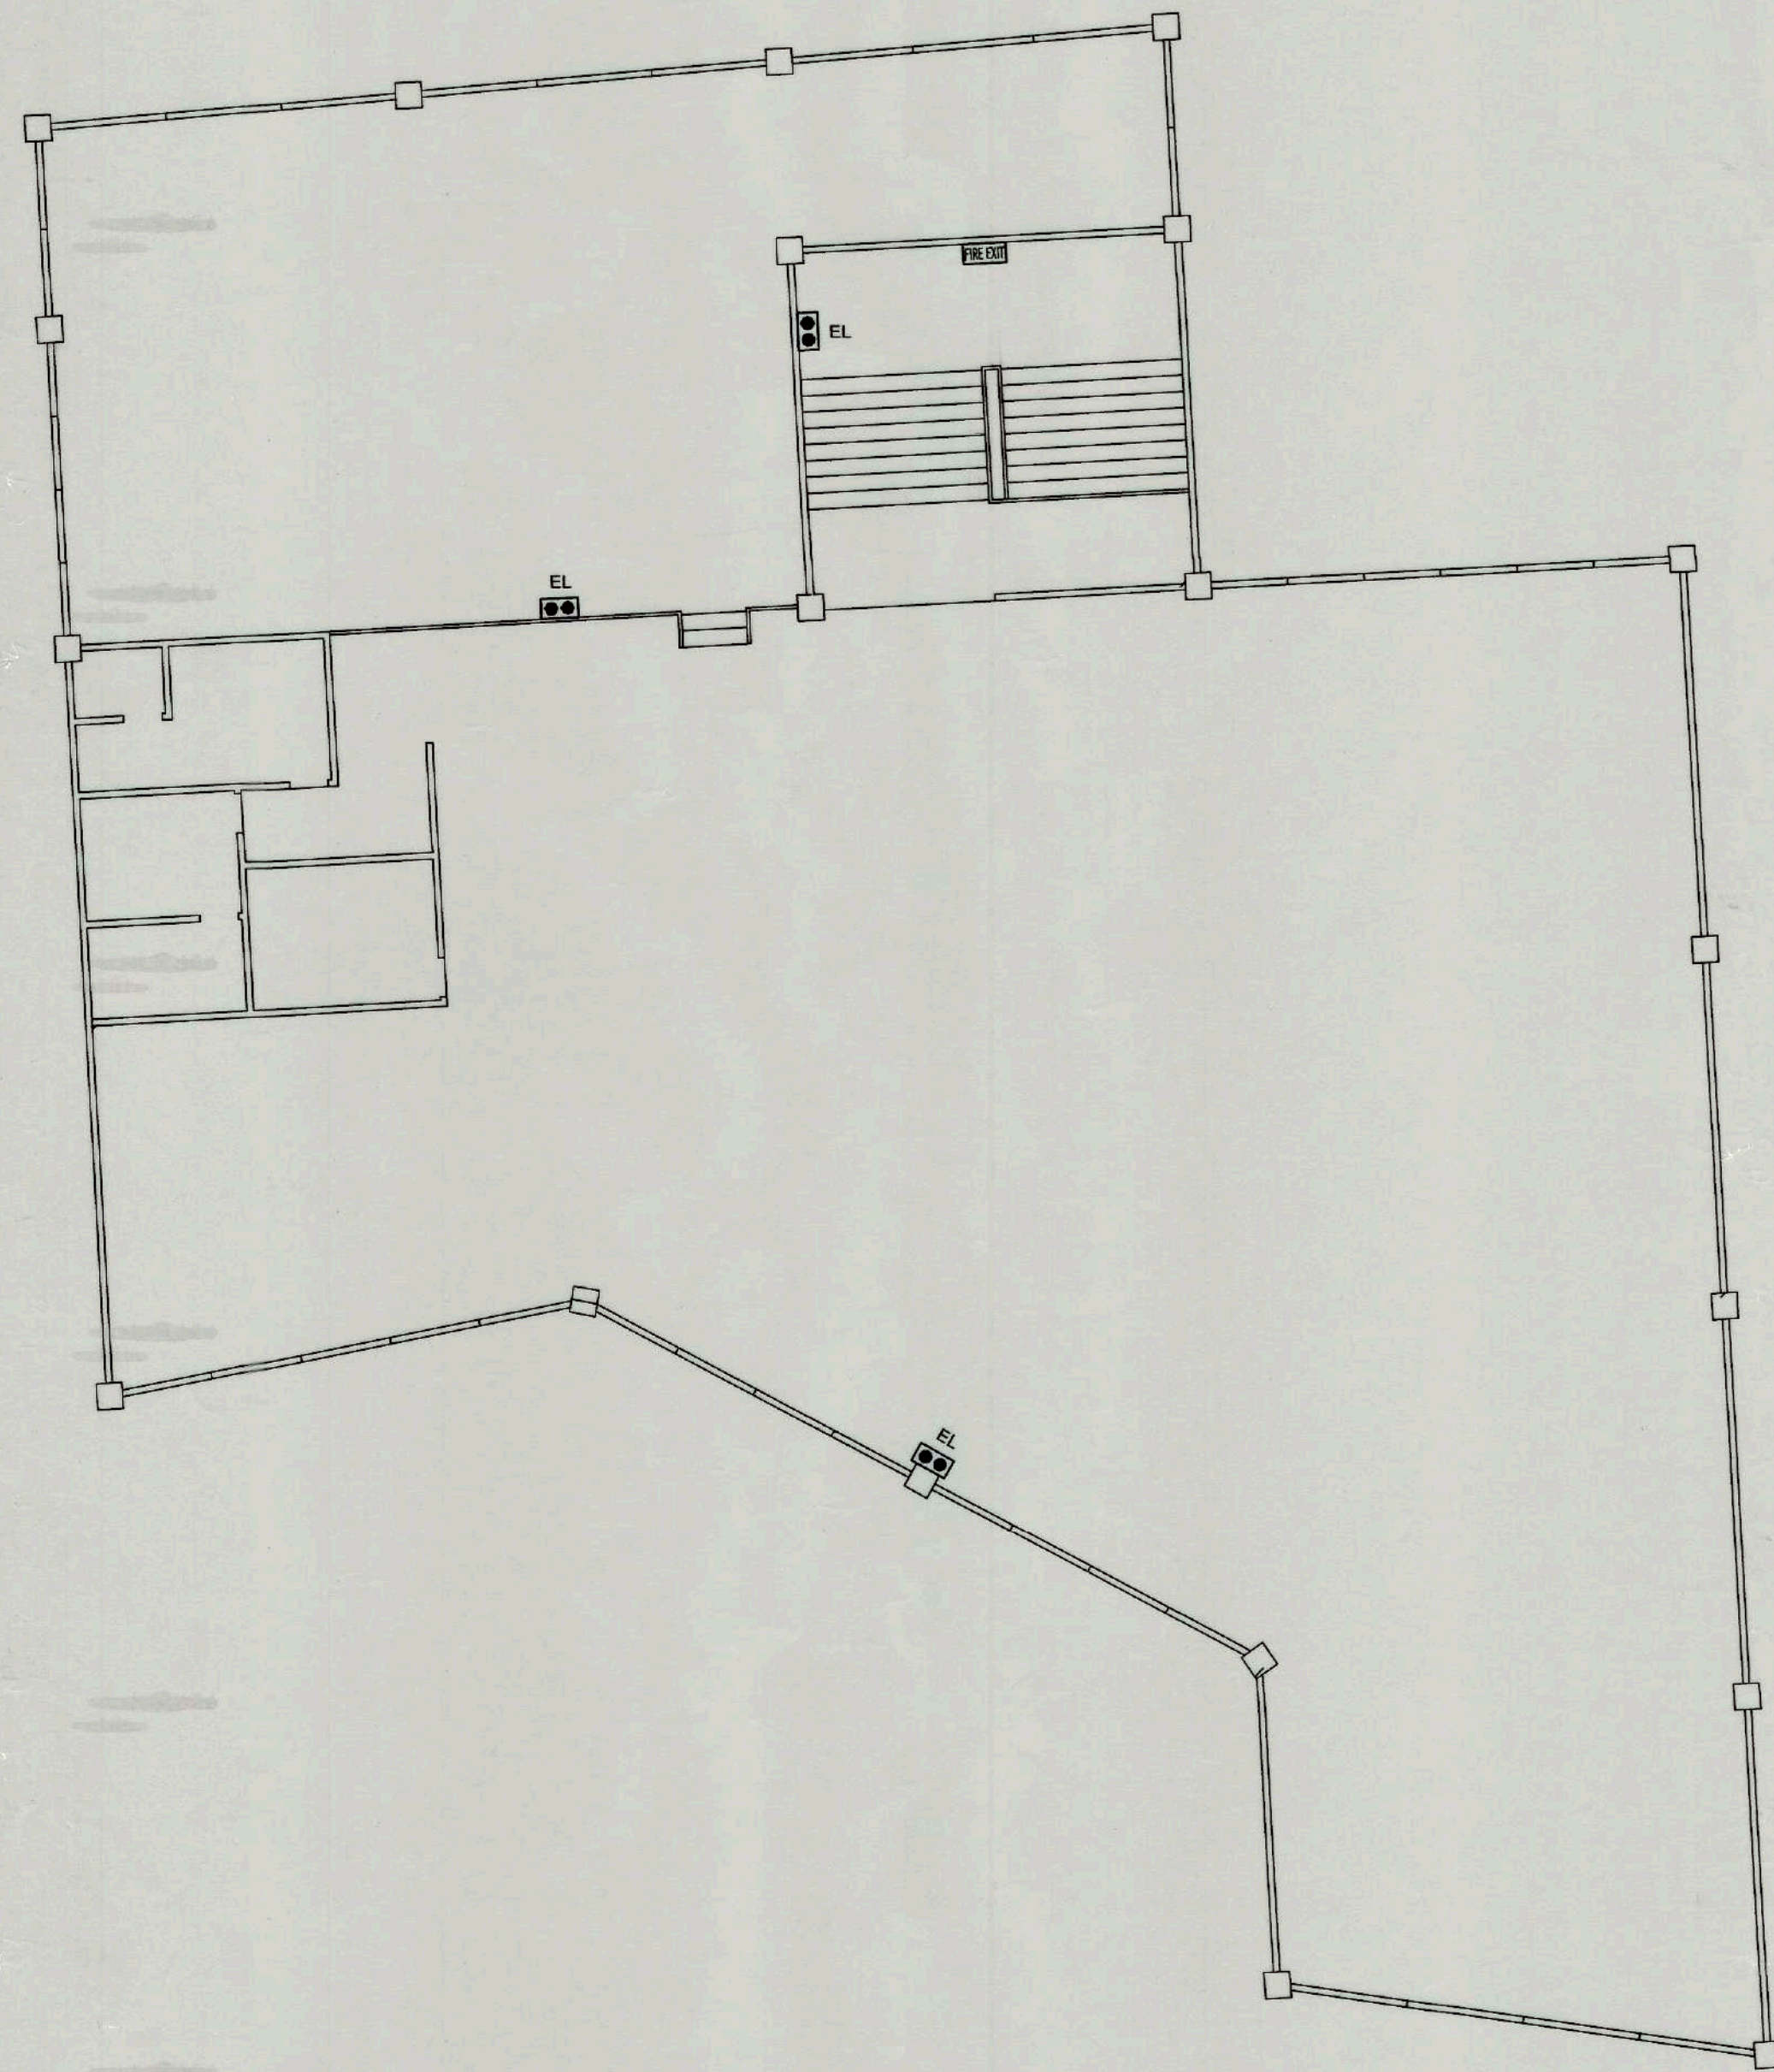


 **ROOF DECK EMERGENCY LIGHT LAYOUT (NEW BLDG.)**  
 SCALE 1 : 150 MTS

|                                                                                                                                                                  |          |                                                                                                |   |   |   |    |
|------------------------------------------------------------------------------------------------------------------------------------------------------------------|----------|------------------------------------------------------------------------------------------------|---|---|---|----|
| CONFORME :                                                                                                                                                       |          |                                                                                                |   |   |   |    |
| <br><b>MARLON PRIETO</b><br>Resident Manager<br>Banaue Hotel & Youth Hostel |          |                                                                                                |   |   |   |    |
| SHEET CONTENTS:                                                                                                                                                  | R.A. 545 | SHEET NO.                                                                                      |   |   |   |    |
| AS SHOWN                                                                                                                                                         |          | <table border="1"> <tr> <td>E</td> <td>7</td> </tr> <tr> <td>8</td> <td>23</td> </tr> </table> | E | 7 | 8 | 23 |
| E                                                                                                                                                                | 7        |                                                                                                |   |   |   |    |
| 8                                                                                                                                                                | 23       |                                                                                                |   |   |   |    |
| REVISIONS:                                                                                                                                                       |          |                                                                                                |   |   |   |    |





  **TIEZA**  
 TOURISM INFRASTRUCTURE  
 AND ENTERPRISE ZONE AUTHORITY  
 142 AMORSOLO ST. LEGASPI VILLAGE  
 MAKATI CITY

| PROJECT TITLE/LOCATION                                                                   |  | PROJECT EVALUATION AND PLANNING DEPARTMENT |                                                         |                                                               | RECOMMENDING APPROVAL:                                                                | APPROVED BY:                                                                          | SHEET CONTENTS: | R.A. 545 | SHEET NO. |
|------------------------------------------------------------------------------------------|--|--------------------------------------------|---------------------------------------------------------|---------------------------------------------------------------|---------------------------------------------------------------------------------------|---------------------------------------------------------------------------------------|-----------------|----------|-----------|
| EMERGENCY WORKS FOR COMPLIANCE<br>WITH FIRE DEPARTMENT REQUIREMENT<br><br>BANAUE, IFUGAO |  | PREPARED BY:                               | CHECKED BY:                                             | REVIEWED BY:                                                  |                                                                                       |                                                                                       |                 |          |           |
|                                                                                          |  | ANGELITO ROQUE                             | RADY E. ADAME                                           | AMELITA S. CAGANDA                                            |  |  | AS SHOWN        |          |           |
|                                                                                          |  | DRAWN BY: O.B. SAN JUAN<br>DATE:           | OFFICER IN CHARGE<br>PROJECT PLANNING & DESIGN DIVISION | OFFICER IN CHARGE<br>PROJECT EVALUATION & PLANNING DEPARTMENT | ASSISTANT CHIEF OPERATING OFFICER<br>Architectural & Engineering Services Sector      | CHIEF OPERATING OFFICER                                                               |                 |          |           |

CAR-17-04




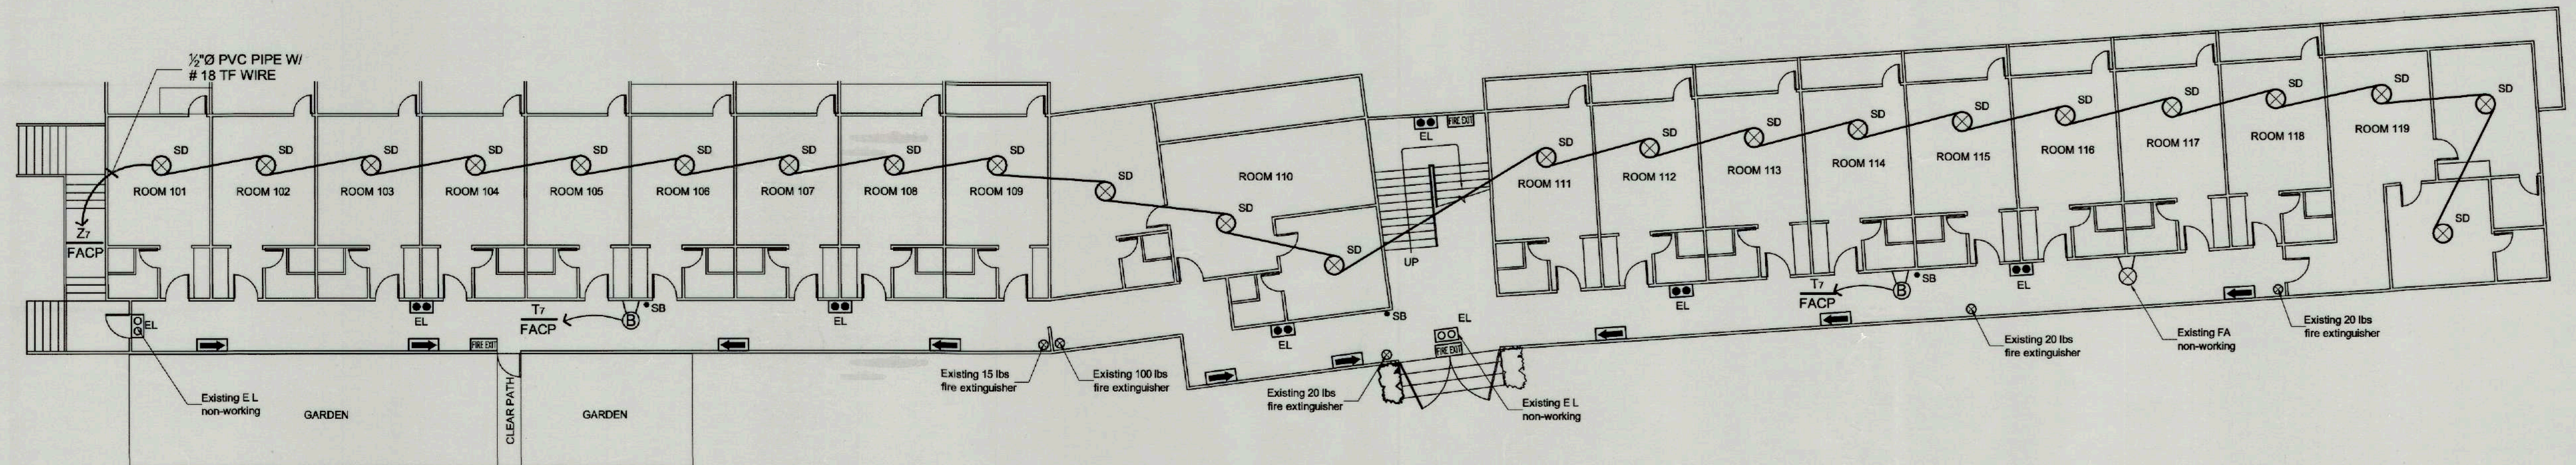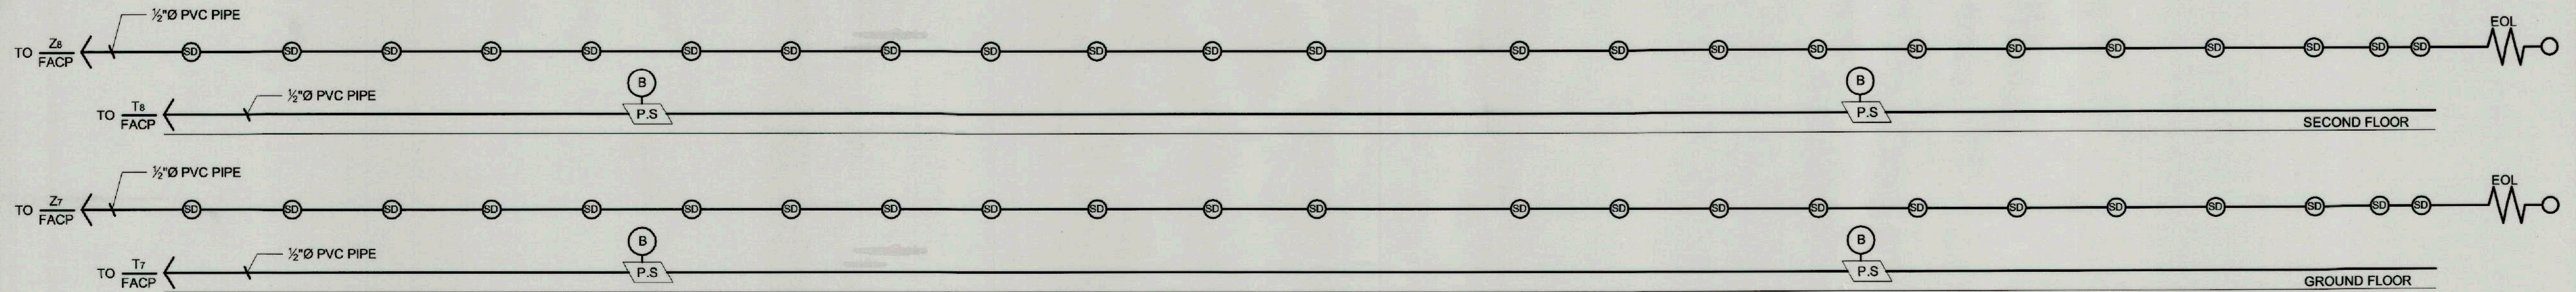

GROUND FLOOR SMOKE DETECTOR/FIRE ALARM/EMERGENCY LIGHT/SIGNAGES LAYOUT (OLD BLDG.)

SCALE

1 : 150 MTS

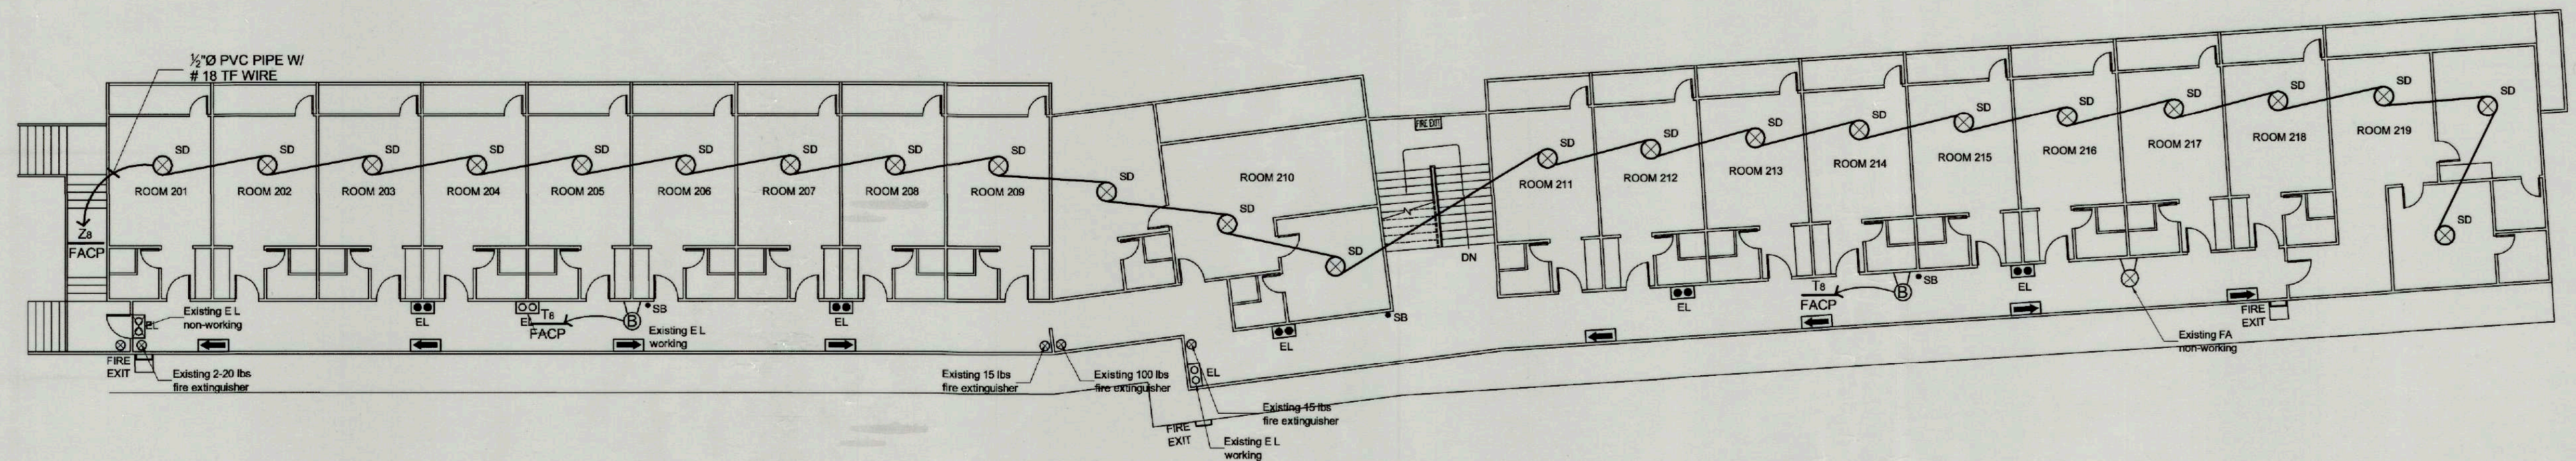

SECOND FLOOR SMOKE DETECTOR/FIRE ALARM/EMERGENCY LIGHT/SIGNAGES LAYOUT (OLD BLDG.)

SCALE

1 : 150 MTS

CONFORME :

*Marlon Prieto*  
MARLON PRIETO  
Resident Manager  
Banaue Hotel & Youth Hostel



**TIEZA**  
TOURISM INFRASTRUCTURE  
AND ENTERPRISE ZONE AUTHORITY  
142 AMORSOLO ST. LEGASPI VILLAGE  
MAKATI CITY

PROJECT TITLE/LOCATION

EMERGENCY WORKS FOR COMPLIANCE  
WITH FIRE DEPARTMENT REQUIREMENT

BANAUE,

IFUGAO

PROJECT EVALUATION AND PLANNING DEPARTMENT

PREPARED BY:

ANGELITO ROQUE

DRAWN BY: O.B. SAN JUAN

DATE:

CHECKED BY:

RADY E. ADAME

OFFICER IN CHARGE  
PROJECT PLANNING & DESIGN DIVISION

REVIEWED BY:

AMELITA S. CAGANDA

OFFICER IN CHARGE  
PROJECT EVALUATION & PLANNING DEPARTMENT

RECOMMENDING APPROVAL:

NESTOR M. DOMALANTA

ASSISTANT CHIEF OPERATING OFFICER  
Architectural & Engineering Services Sector

APPROVED BY:

POCHOLO J. D. PARAGAS

CHIEF OPERATING OFFICER

SHEET CONTENTS:

AS SHOWN

R.A. 545


THIS DRAWING IS  
THE PROPERTY OF  
TOURISM ENTERPRISE  
ZONE AUTHORITY AND  
CANNOT BE REPRO-  
DUCED WITHOUT  
THEIR CONSENT.

SHEET NO.

E 8  
8 23

CAR-17-04




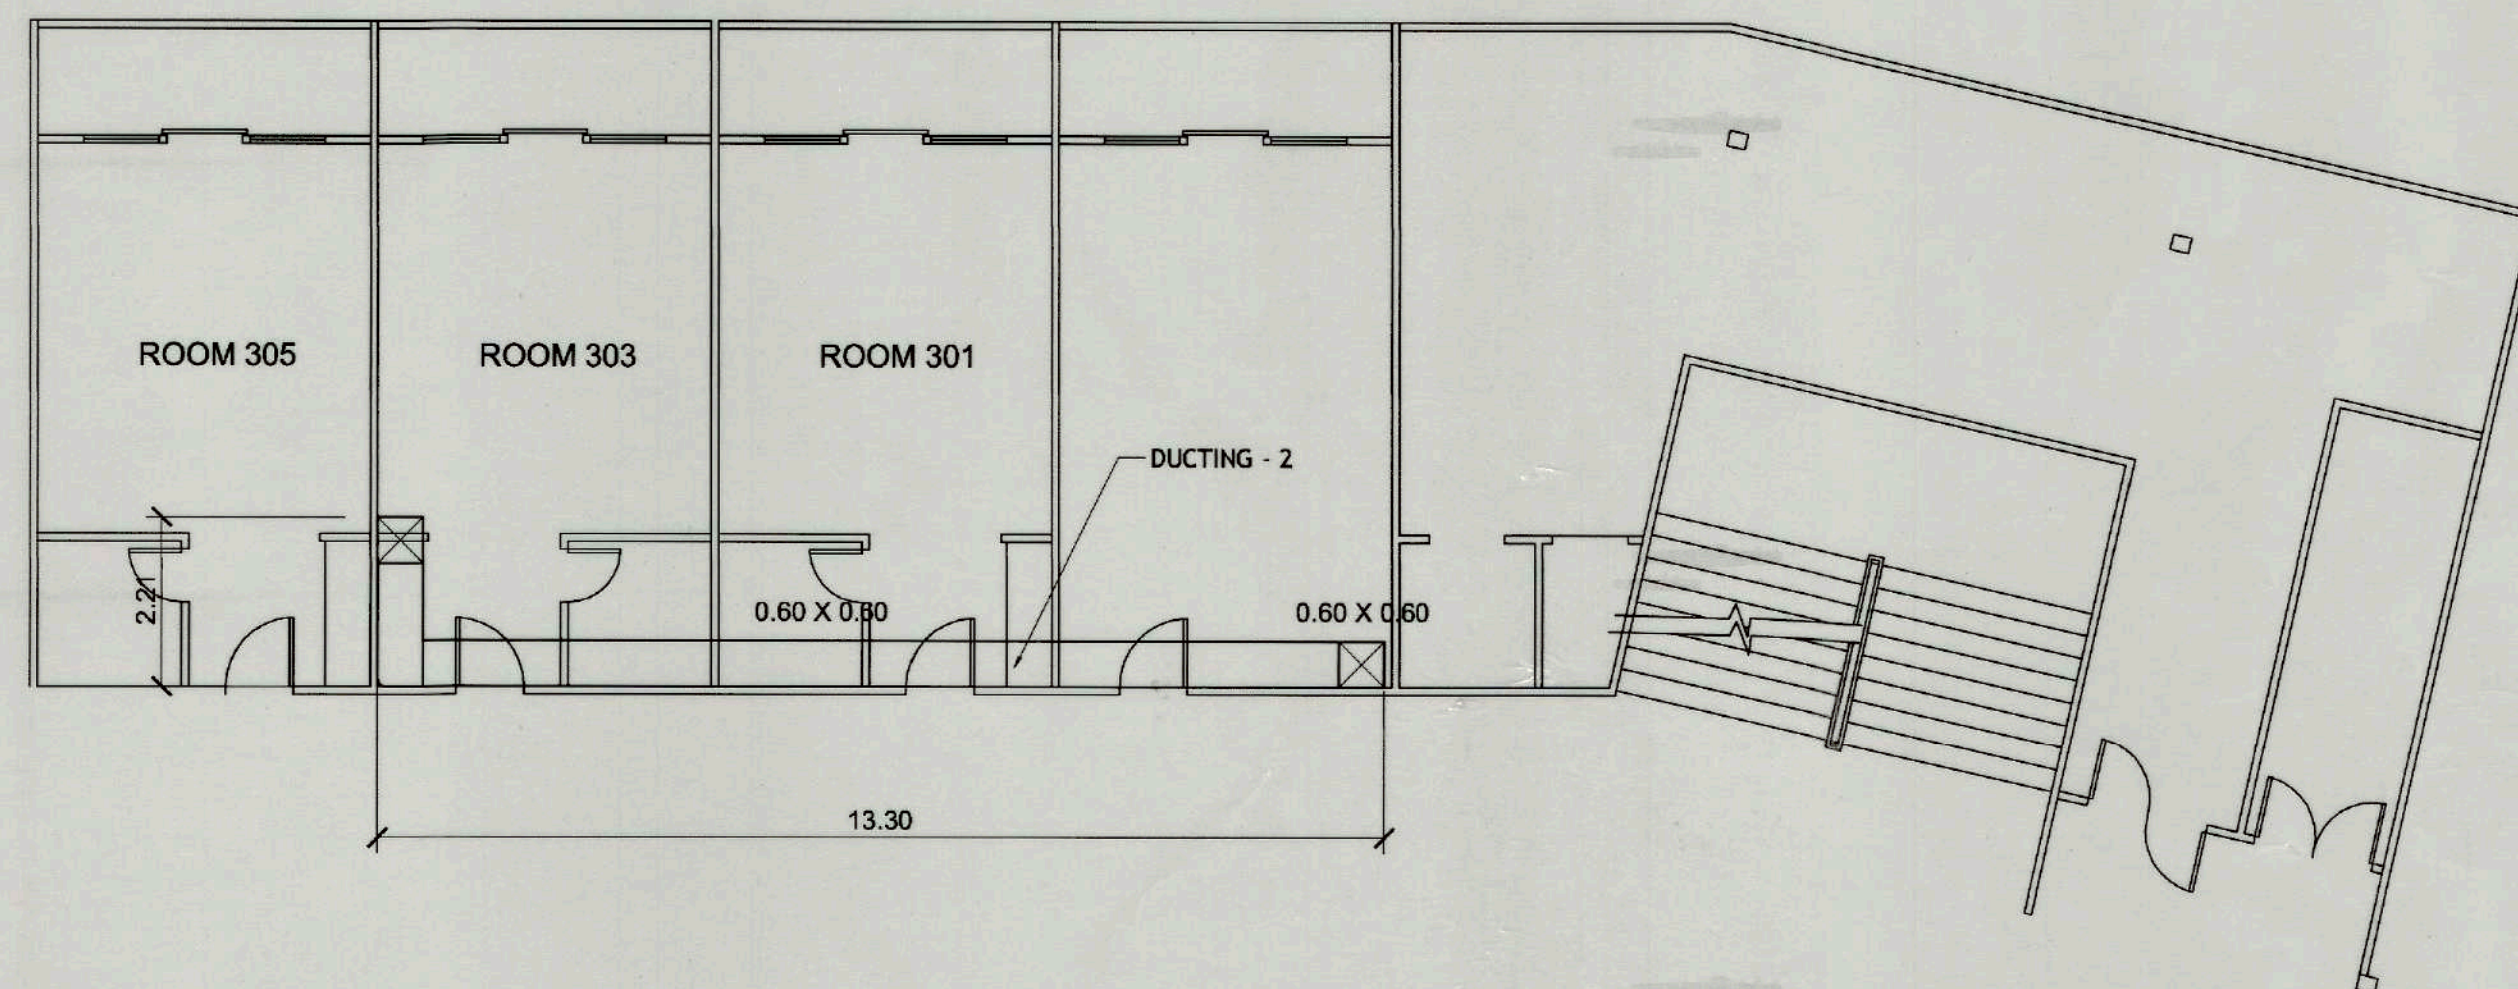

SECOND FLOOR DUCTING LAYOUT NEW BLDG. (PROPOSED)

SCALE


1 : 100 MTS

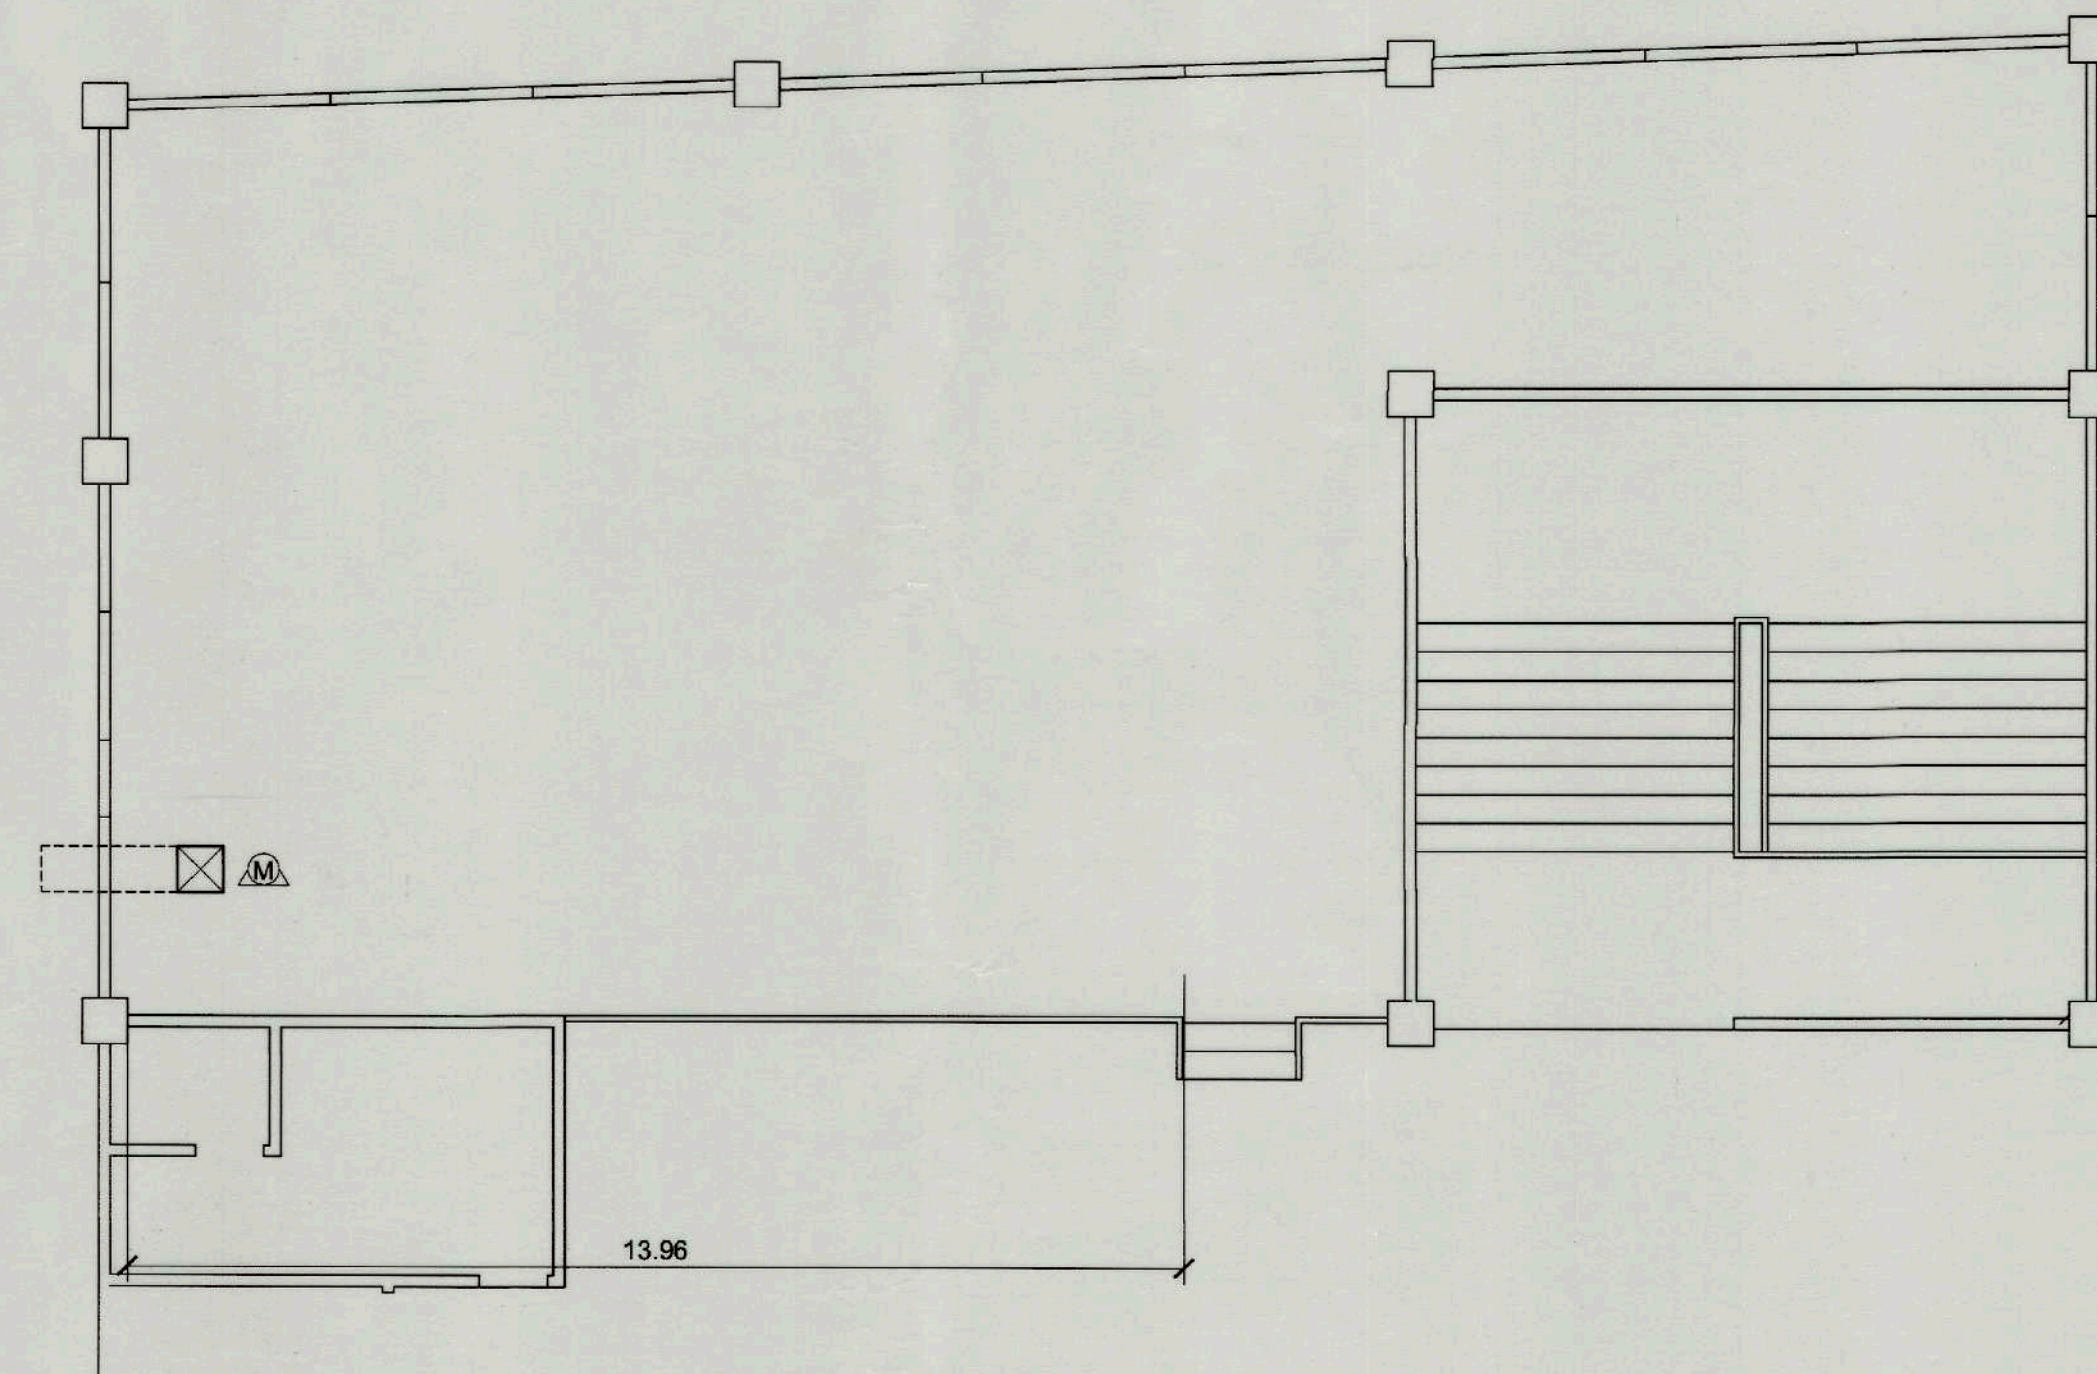

ROOF DECK DUCTING LAYOUT (PROPOSED)

SCALE


1 : 100 MTS

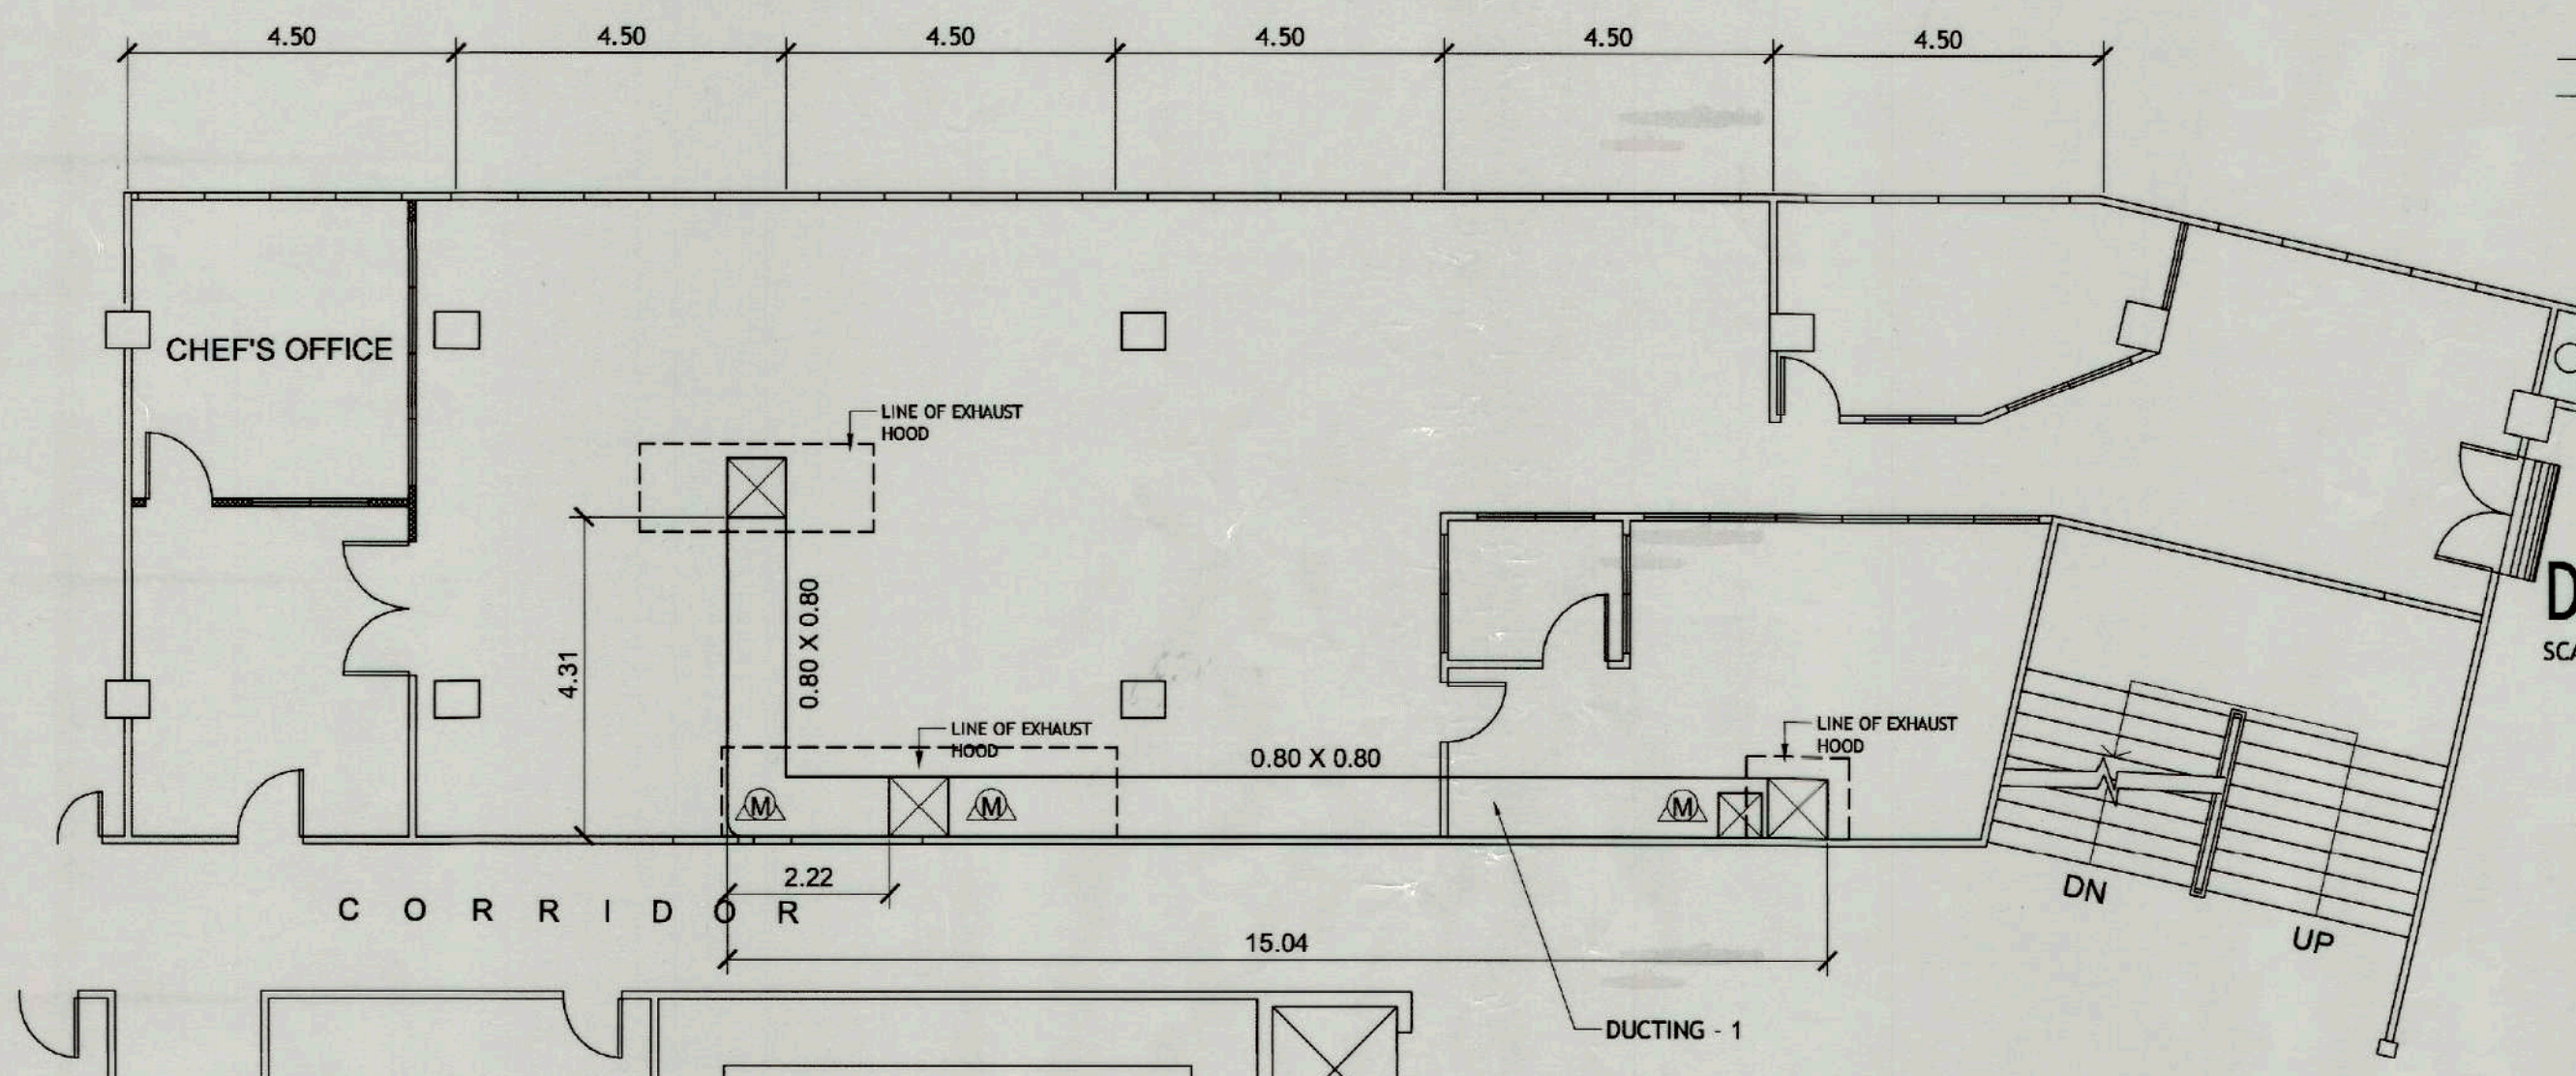

KITCHEN DUCTING LAYOUT (PROPOSED)

SCALE


1 : 100 MTS

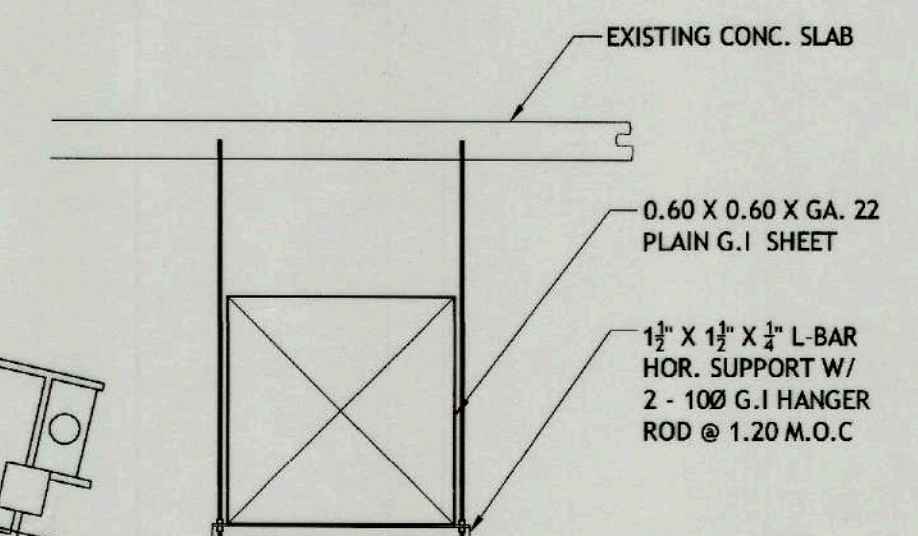

DUCTING - 2 SECTION

SCALE


1 : 20 MTS

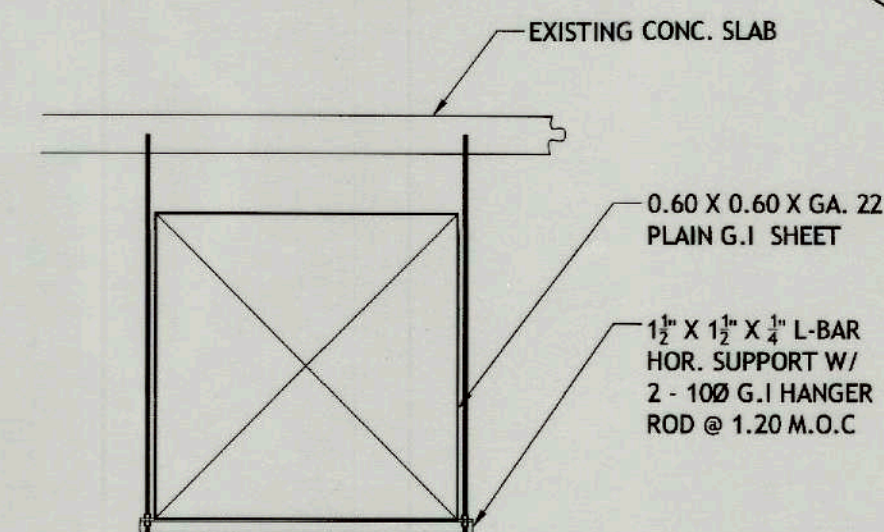

DUCTING - 1 SECTION

SCALE

1 : 20 MTS

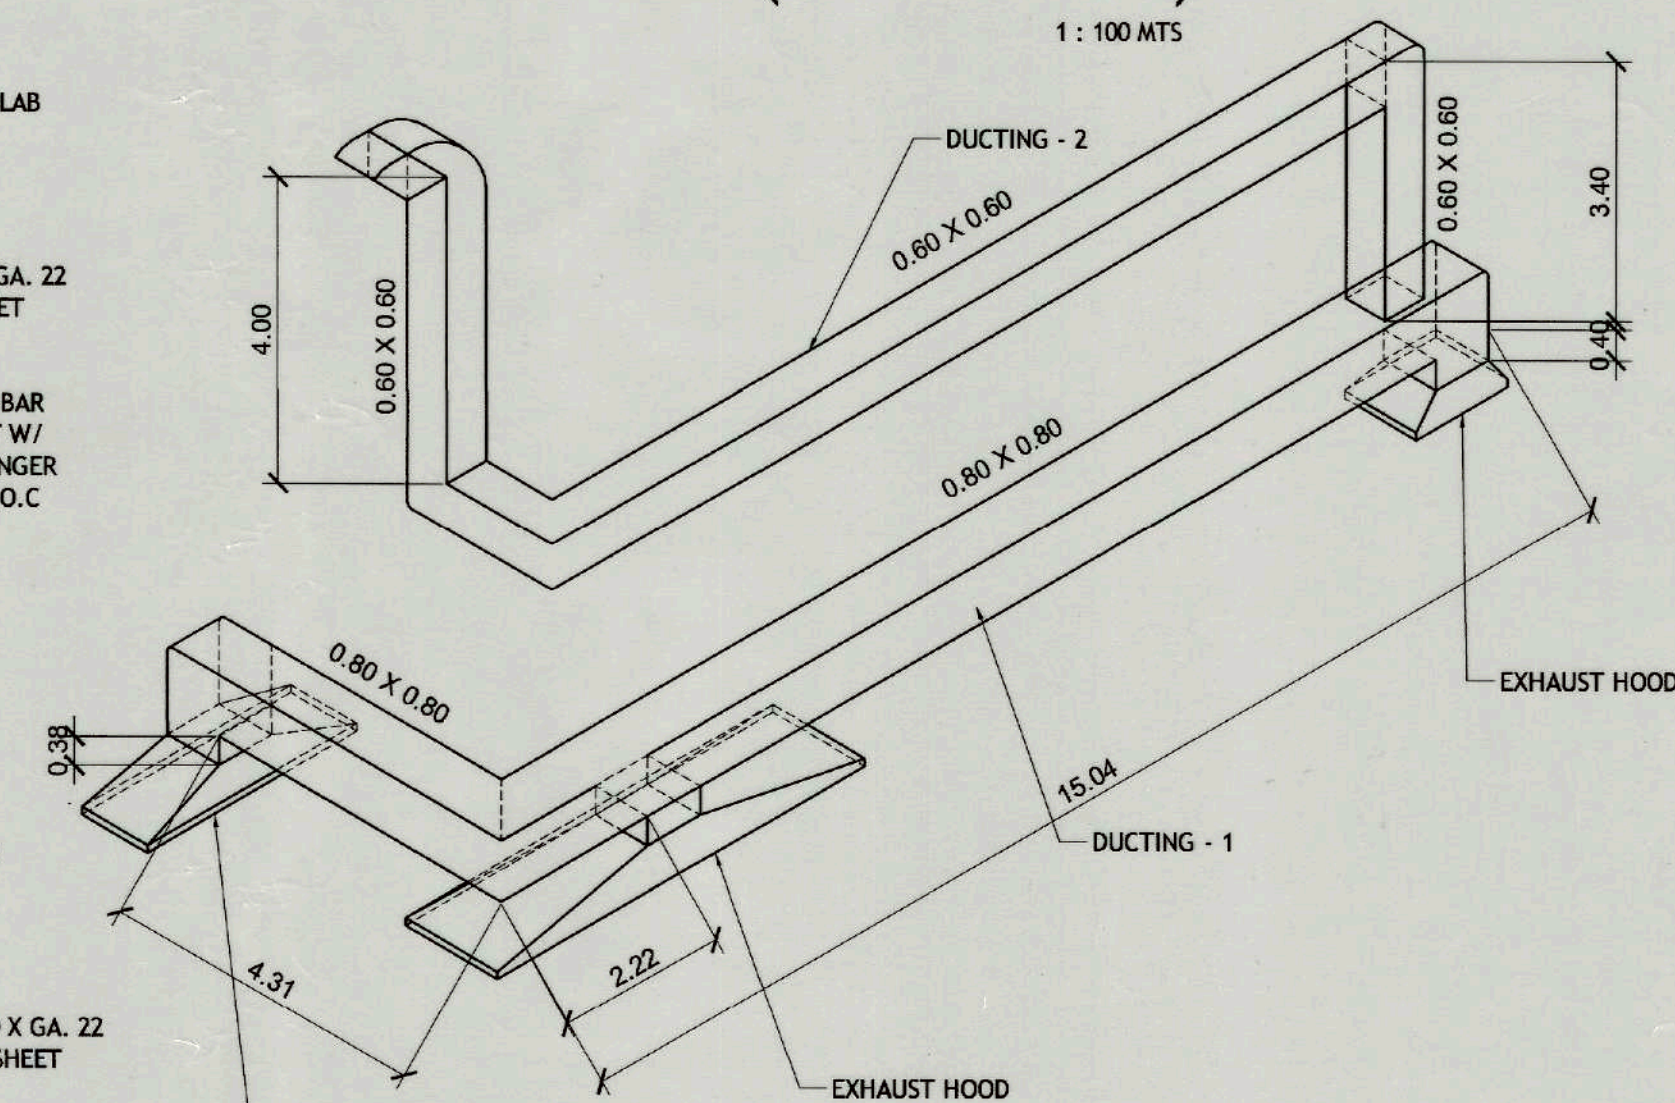

EXHAUST DUCTING ISOMETRIC

SCALE

1 : 100 MTS

CONFORME :

*Marlon Prieto*  
MARLON PRIETO  
Resident Manager  
Banaue Hotel & Youth Hostel



**TIEZA**  
TOURISM INFRASTRUCTURE  
AND ENTERPRISE ZONE AUTHORITY  
142 AMORSOLO ST. LEGASPI VILLAGE  
MAKATI CITY

PROJECT TITLE/LOCATION

EMERGENCY WORKS FOR COMPLIANCE  
WITH FIRE DEPARTMENT REQUIREMENT

BANAUE,

IFUGAO

PROJECT EVALUATION AND PLANNING DEPARTMENT

PREPARED BY:

JEFFREY P. HERNANDEZ

DRAWN BY: O.B. SAN JUAN  
DATE:

CHECKED BY:

RADY E. ADAME

OFFICER IN CHARGE  
PROJECT PLANNING & DESIGN DIVISION

REVIEWED BY:

AMELITA S. CAGANDA

OFFICER IN CHARGE  
PROJECT EVALUATION & PLANNING DEPARTMENT

RECOMMENDING APPROVAL:

NESTOR M. DOMALANTA

ASSISTANT CHIEF OPERATING OFFICER  
Architectural & Engineering Services Sector

APPROVED BY:

POCHOLO J. D. PARAGAS

CHIEF OPERATING OFFICER

SHEET CONTENTS:

AS SHOWN

R.A. 545

SHEET NO.


THIS DRAWING IS  
THE PROPERTY OF  
TOURISM ENTERPRISE  
ZONE AUTHORITY AND  
CANNOT BE REPRO-  
DUCED WITHOUT  
THEIR CONSENT.

M 1  
1 23


REVISIONS:

CAR-17-04



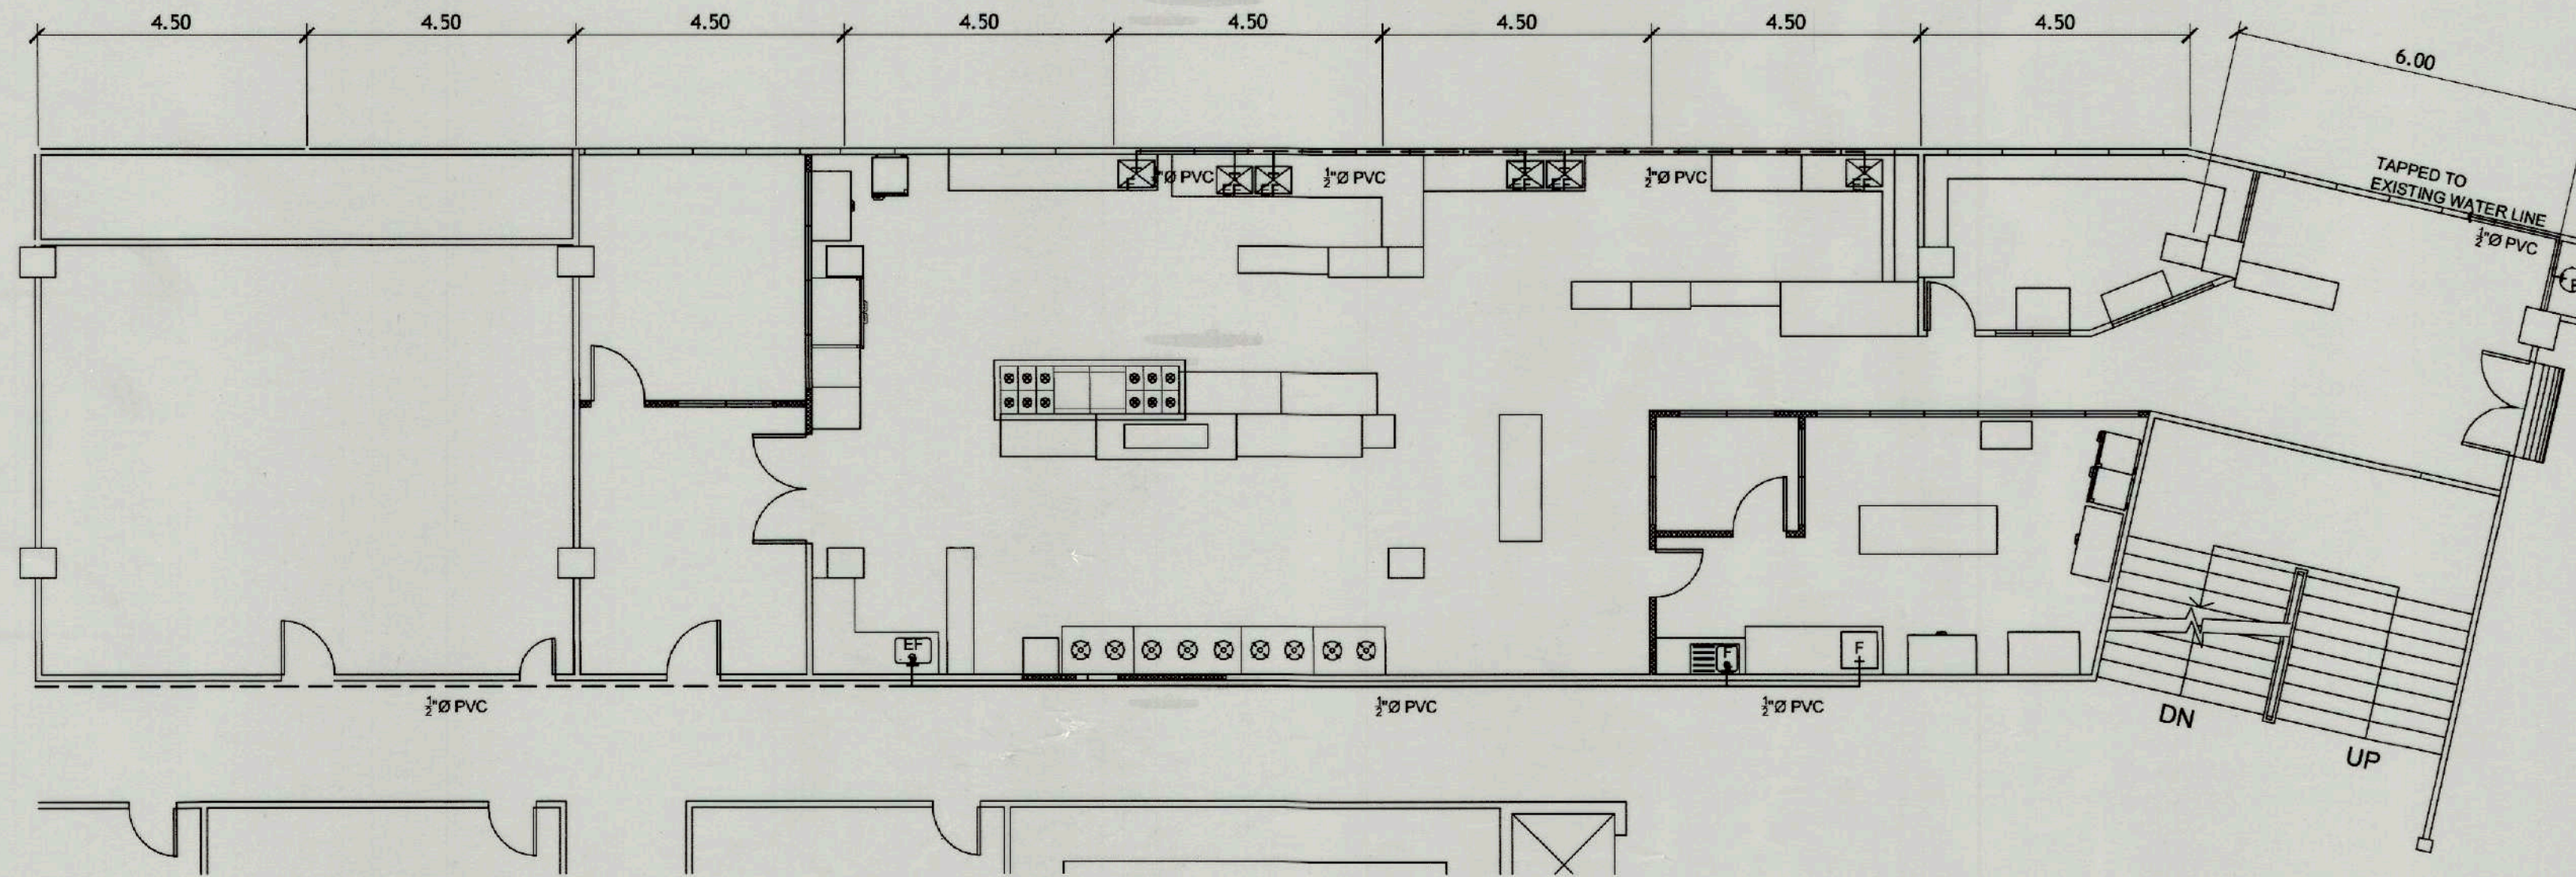

**KITCHEN WATER LINE LAYOUT**  
SCALE 1 : 100 MTS

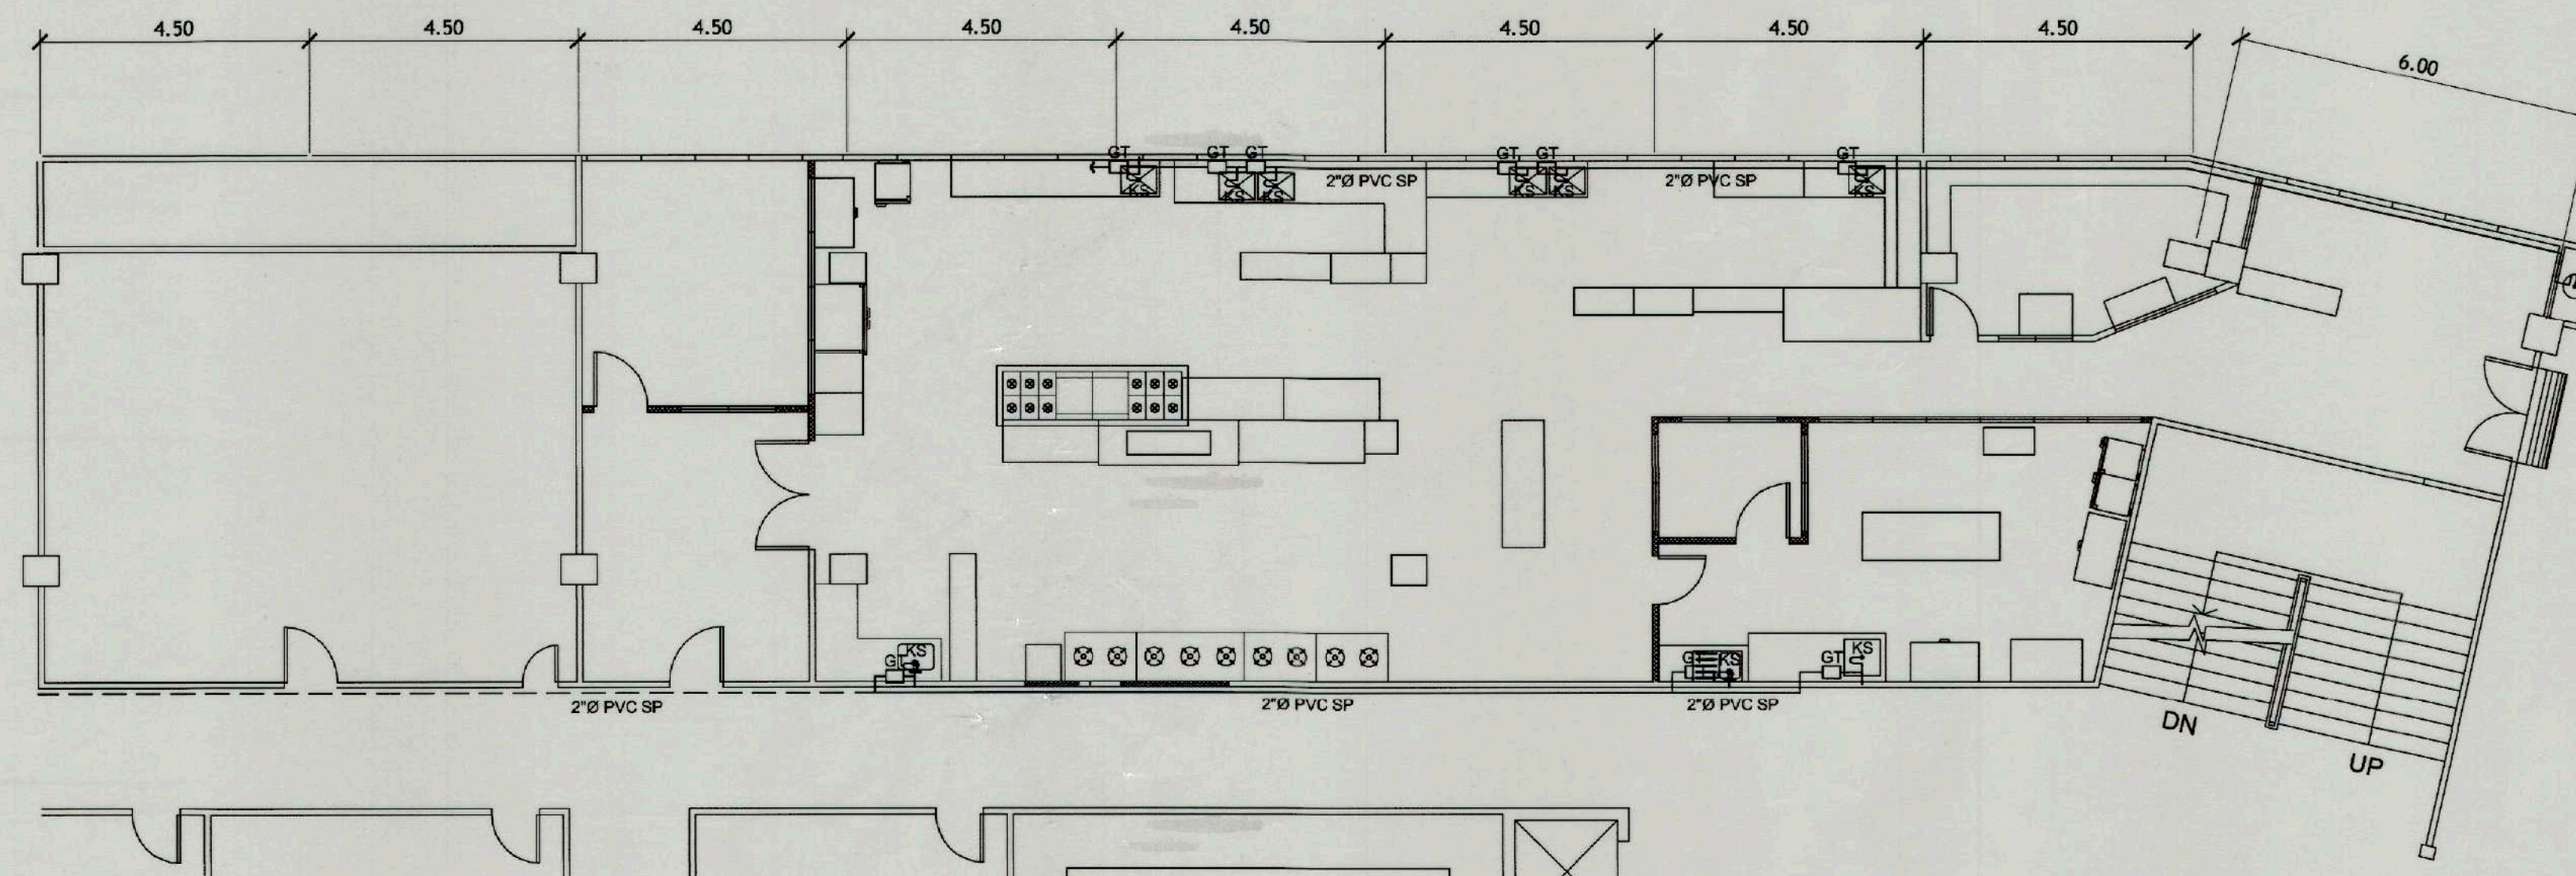

**KITCHEN SEWER LINE LAYOUT**  
SCALE 1 : 100 MTS

**LEGEND:**

- F FAUCET
- KS KITCHEN SINK
- SP SEWER PIPE
- GT GREASE TRAP
- PVC POLYVINYL CHLORIDE
- VP VENT PIPE
- VTC VENT THRU CEILING
- EXISTING WATER LINE
- PROPOSED WATER LINE
- EXISTING SEWER LINE
- PROPOSED SEWER LINE

|                                                                             |                                                                                                                   |   |   |   |    |
|-----------------------------------------------------------------------------|-------------------------------------------------------------------------------------------------------------------|---|---|---|----|
| CONFORME :                                                                  |                                                                                                                   |   |   |   |    |
| <br><b>MARLON PRIETO</b><br>Resident Manager<br>Banaue Motel & Youth Hostel |                                                                                                                   |   |   |   |    |
| SHEET CONTENTS:                                                             | R.A. 545                                                                                                          |   |   |   |    |
| AS SHOWN                                                                    | THIS DRAWING IS THE PROPERTY OF TOURISM ENTERPRISE ZONE AUTHORITY AND CANNOT BE REPRODUCED WITHOUT THEIR CONSENT. |   |   |   |    |
| REVISIONS:                                                                  | <table border="1"> <tr> <td>P</td> <td>1</td> </tr> <tr> <td>2</td> <td>23</td> </tr> </table>                    | P | 1 | 2 | 23 |
| P                                                                           | 1                                                                                                                 |   |   |   |    |
| 2                                                                           | 23                                                                                                                |   |   |   |    |

| TIEZA<br>TOURISM INFRASTRUCTURE<br>AND ENTERPRISE ZONE AUTHORITY<br>142 AMORSOLO ST. LEGASPI VILLAGE<br>MAKATI CITY    |  | PROJECT EVALUATION AND PLANNING DEPARTMENT              |                                                               |                                        | RECOMMENDING APPROVAL:                                                           | APPROVED BY:              | SHEET CONTENTS:         | R.A. 545 | SHEET NO. |
|------------------------------------------------------------------------------------------------------------------------|--|---------------------------------------------------------|---------------------------------------------------------------|----------------------------------------|----------------------------------------------------------------------------------|---------------------------|-------------------------|----------|-----------|
| PROJECT TITLE/LOCATION<br><b>EMERGENCY WORKS FOR COMPLIANCE<br/>WITH FIRE DEPARTMENT REQUIREMENT</b><br>BANAUE, IFUGAO |  | PREPARED BY:<br><br>JOHN DOMINGO                        | CHECKED BY:<br><br>RADY E. ADAME                              | REVIEWED BY:<br><br>AMELITA S. CAGANDA | <br>NESTOR M. DOMALANTA                                                          | <br>POCHOLO J. D. PARAGAS | AS SHOWN                |          |           |
| DRAWN BY: O.B. SAN JUAN<br>DATE:                                                                                       |  | OFFICER IN CHARGE<br>PROJECT PLANNING & DESIGN DIVISION | OFFICER IN CHARGE<br>PROJECT EVALUATION & PLANNING DEPARTMENT |                                        | ASSISTANT CHIEF OPERATING OFFICER<br>Architectural & Engineering Services Sector |                           | CHIEF OPERATING OFFICER |          |           |

CAR-17-04



# KITCHEN WATER LINE ISOMETRIC


SCALE

1 : 100 MTS

# KITCHEN SEWER LINE ISOMETRIC

SCALE

1 : 100 MTS

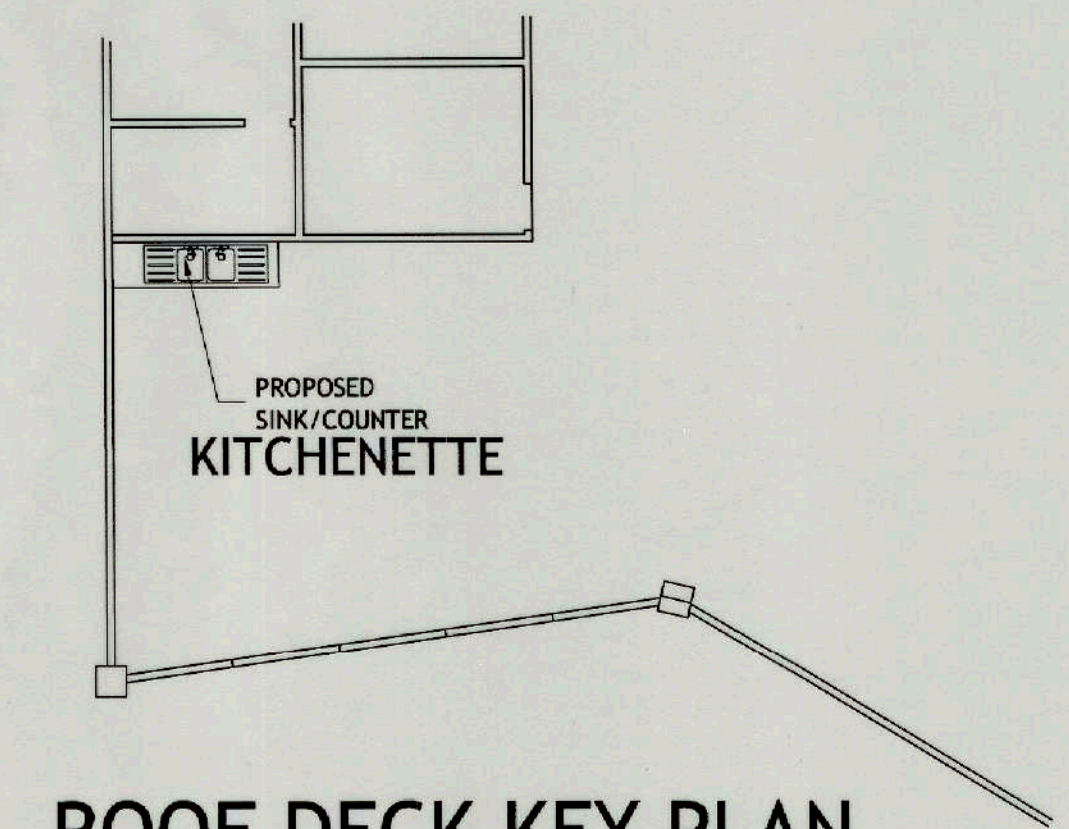


## ROOF DECK KEY PLAN

SCALE

1 : 100 MTS.

## LEGEND:


- F FAUCET
- KS KITCHEN SINK
- SP SEWER PIPE
- G.I.P GALVANIZED IRON PIPE
- PVC POLYVINYL CHLORIDE
- VP VENT PIPE
- VTC VENT HTRU CEILING

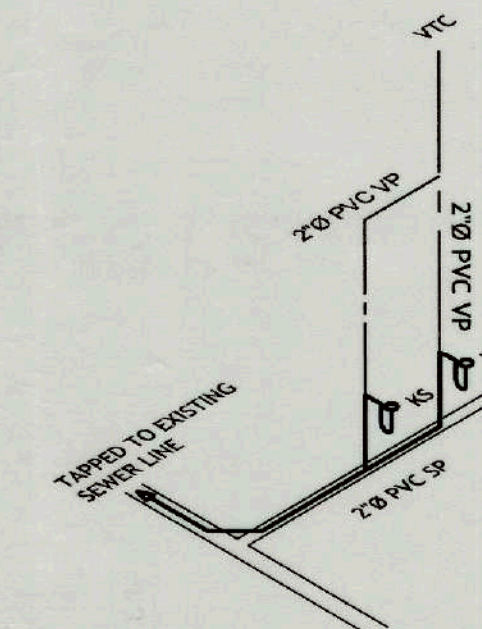

## KITCHENETTE SEWER LINE ISOMETRIC

SCALE


1 : 50 MTS.

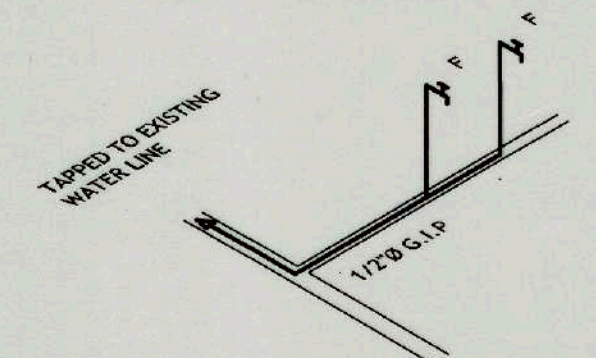

## KITCHENETTE WATER LINE ISOMETRIC

SCALE


1 : 50 MTS.

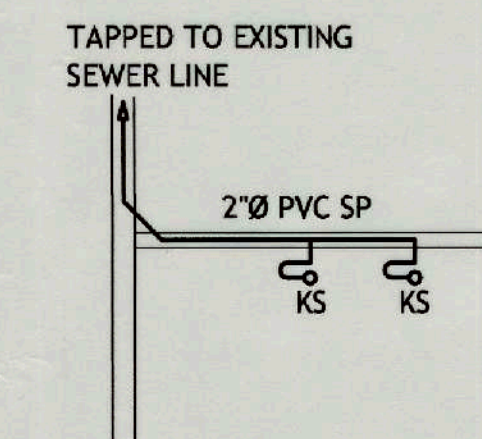

## KITCHENETTE SEWER LINE LAYOUT

SCALE

1 : 50 MTS.

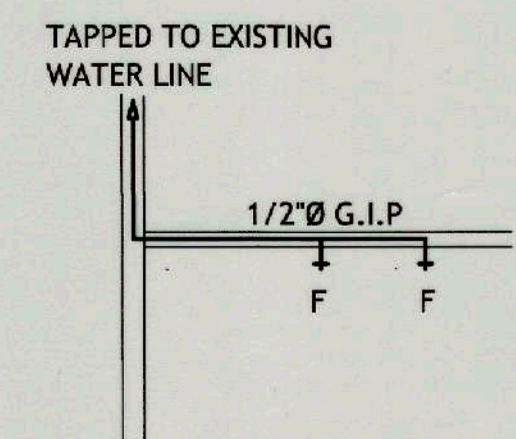

## KITCHENETTE WATER LINE LAYOUT

SCALE

1 : 50 MTS.

CONFORME :

*Marlon Prieto*  
MARLON PRIETO  
Resident Manager  
Banque Hotel & Youth Hostel



**TIEZA**  
TOURISM INFRASTRUCTURE  
AND ENTERPRISE ZONE AUTHORITY  
142 AMORSOLO ST. LEGASPI VILLAGE  
MAKATI CITY

PROJECT TITLE/LOCATION  
EMERGENCY WORKS FOR COMPLIANCE  
WITH FIRE DEPARTMENT REQUIREMENT  
BANAUE, IFUGAO

PROJECT EVALUATION AND PLANNING DEPARTMENT  
PREPARED BY: JOHN B. DOMINGO  
CHECKED BY: RADY E. ADAME  
REVIEWED BY: AMELITA S. CAGANDA  
DATE: 01.08.2023  
OFFICER IN CHARGE  
PROJECT PLANNING & DESIGN DIVISION

RECOMMENDING APPROVAL:  
NESTOR M. DOMALANTA  
ASSISTANT CHIEF OPERATING OFFICER  
Architectural & Engineering Services Sector

APPROVED BY:  
POCHOLO J. D. PARAGAS  
CHIEF OPERATING OFFICER

SHEET CONTENTS:  
AS SHOWN  
REVISIONS:

R.A. 545  
THIS DRAWING IS  
THE PROPERTY OF  
TOURISM ENTERPRISE  
ZONE AUTHORITY AND  
CANNOT BE REPRODUCED  
WITHOUT  
THEIR CONSENT.

SHEET NO.  
P 2  
2 23

CAR-17-04